


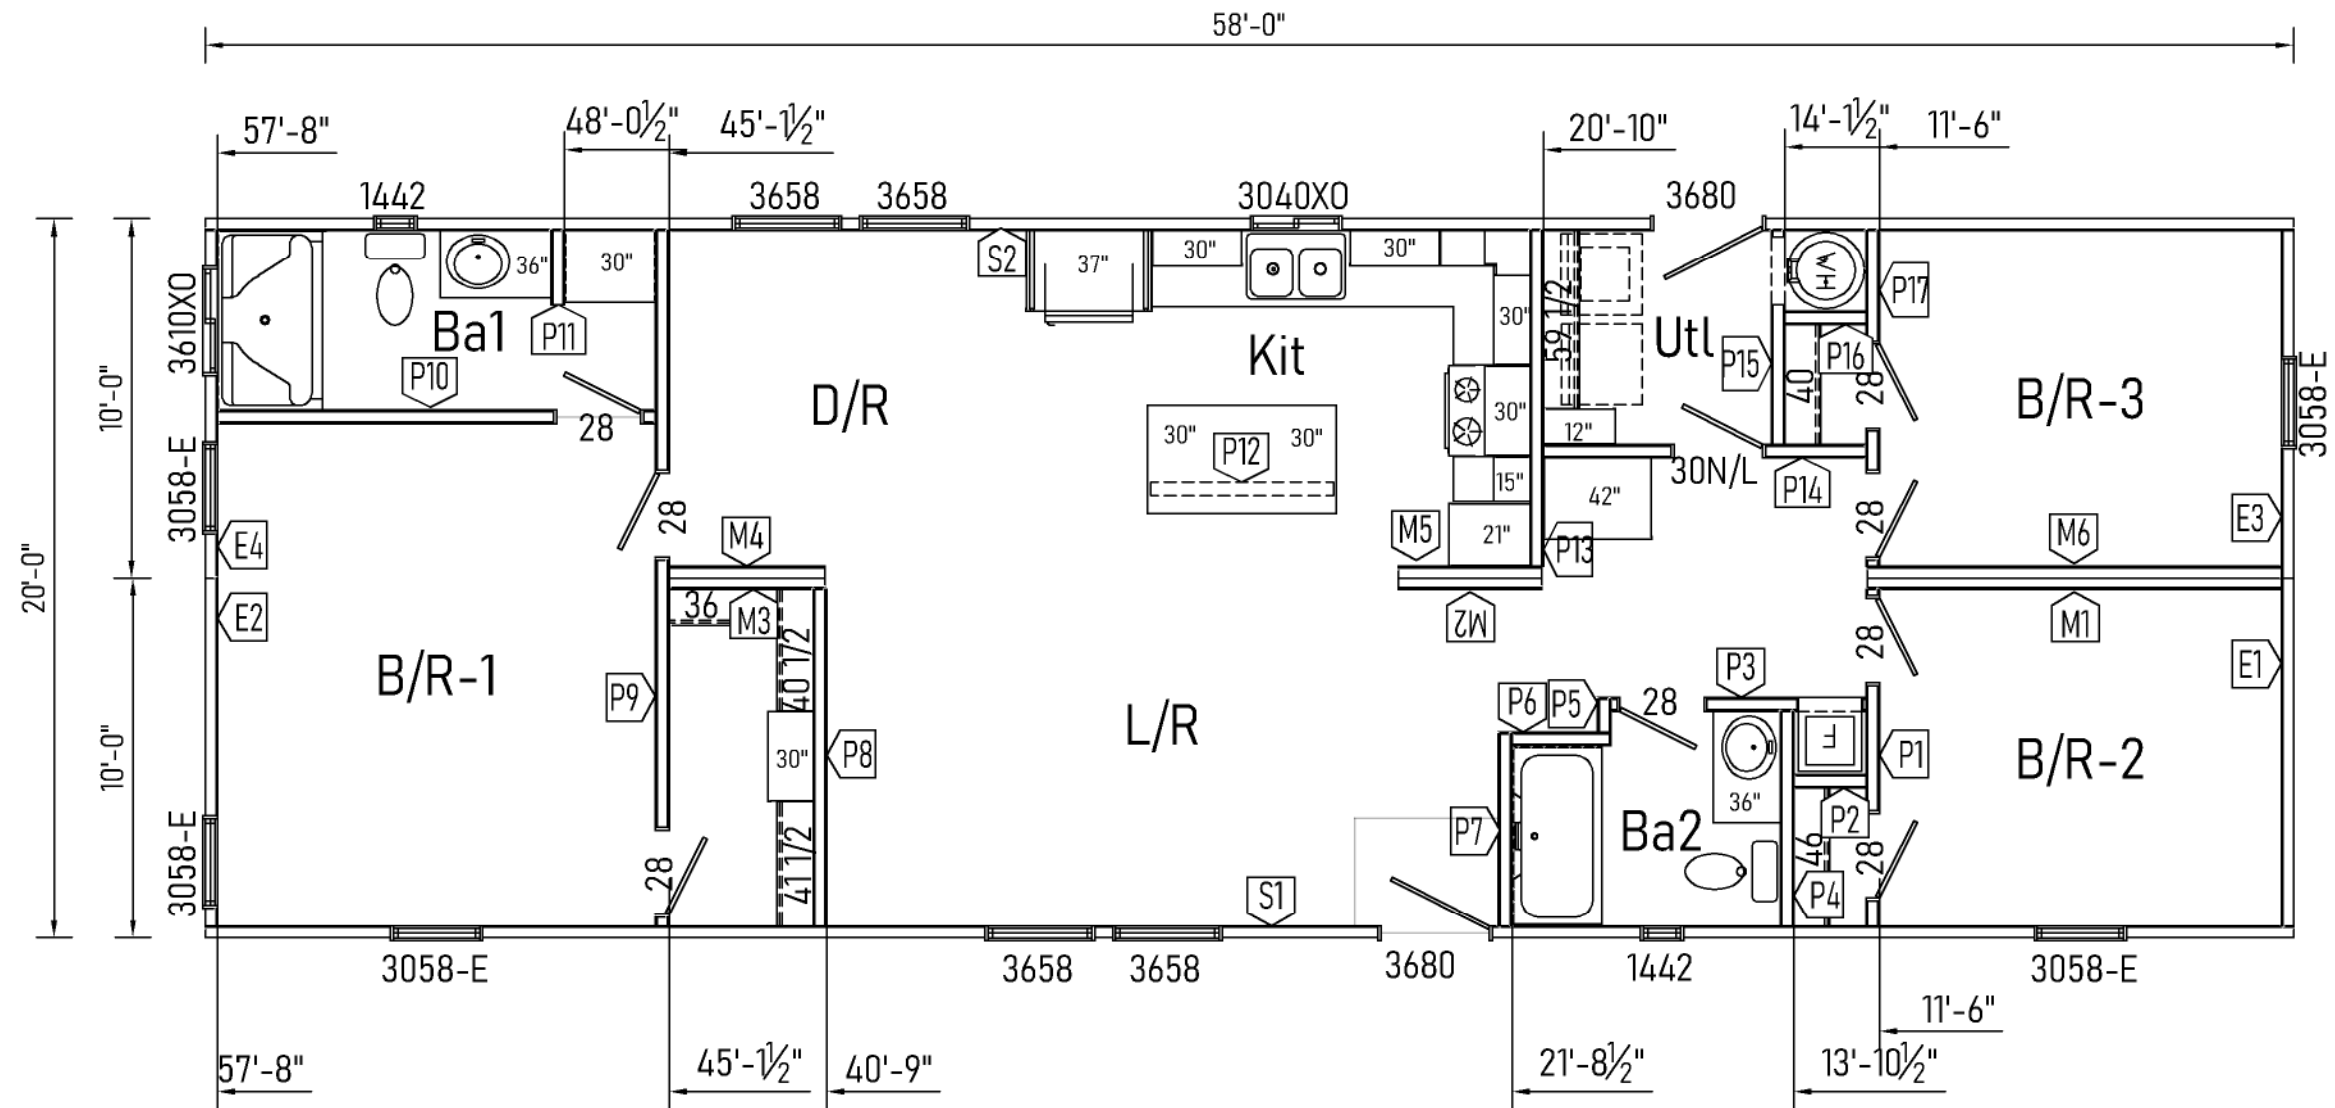

Ø 4-1/4" DIA. DRYER VENT CENTER LINE
HEADER HGTS. PER 10-2.4, 10-2.5, 10-2.6

Builder: 130 Cavco-Litchfield

Title: Floor Plan

Address: 1300 S Litchfield Rd. Bldg. 260
Goodyear, AZ 85338

Revisions
Drawn By:
KW

Scale: 3/16" = 1'-0"
Date: 10/29/2025
Reference:

Cust: -
Dir: -
S/N: .

Prod. Code: SZ
Number: 20583A
Pg.: FP

Order/Plan Number:
Run:

25-130520583A