



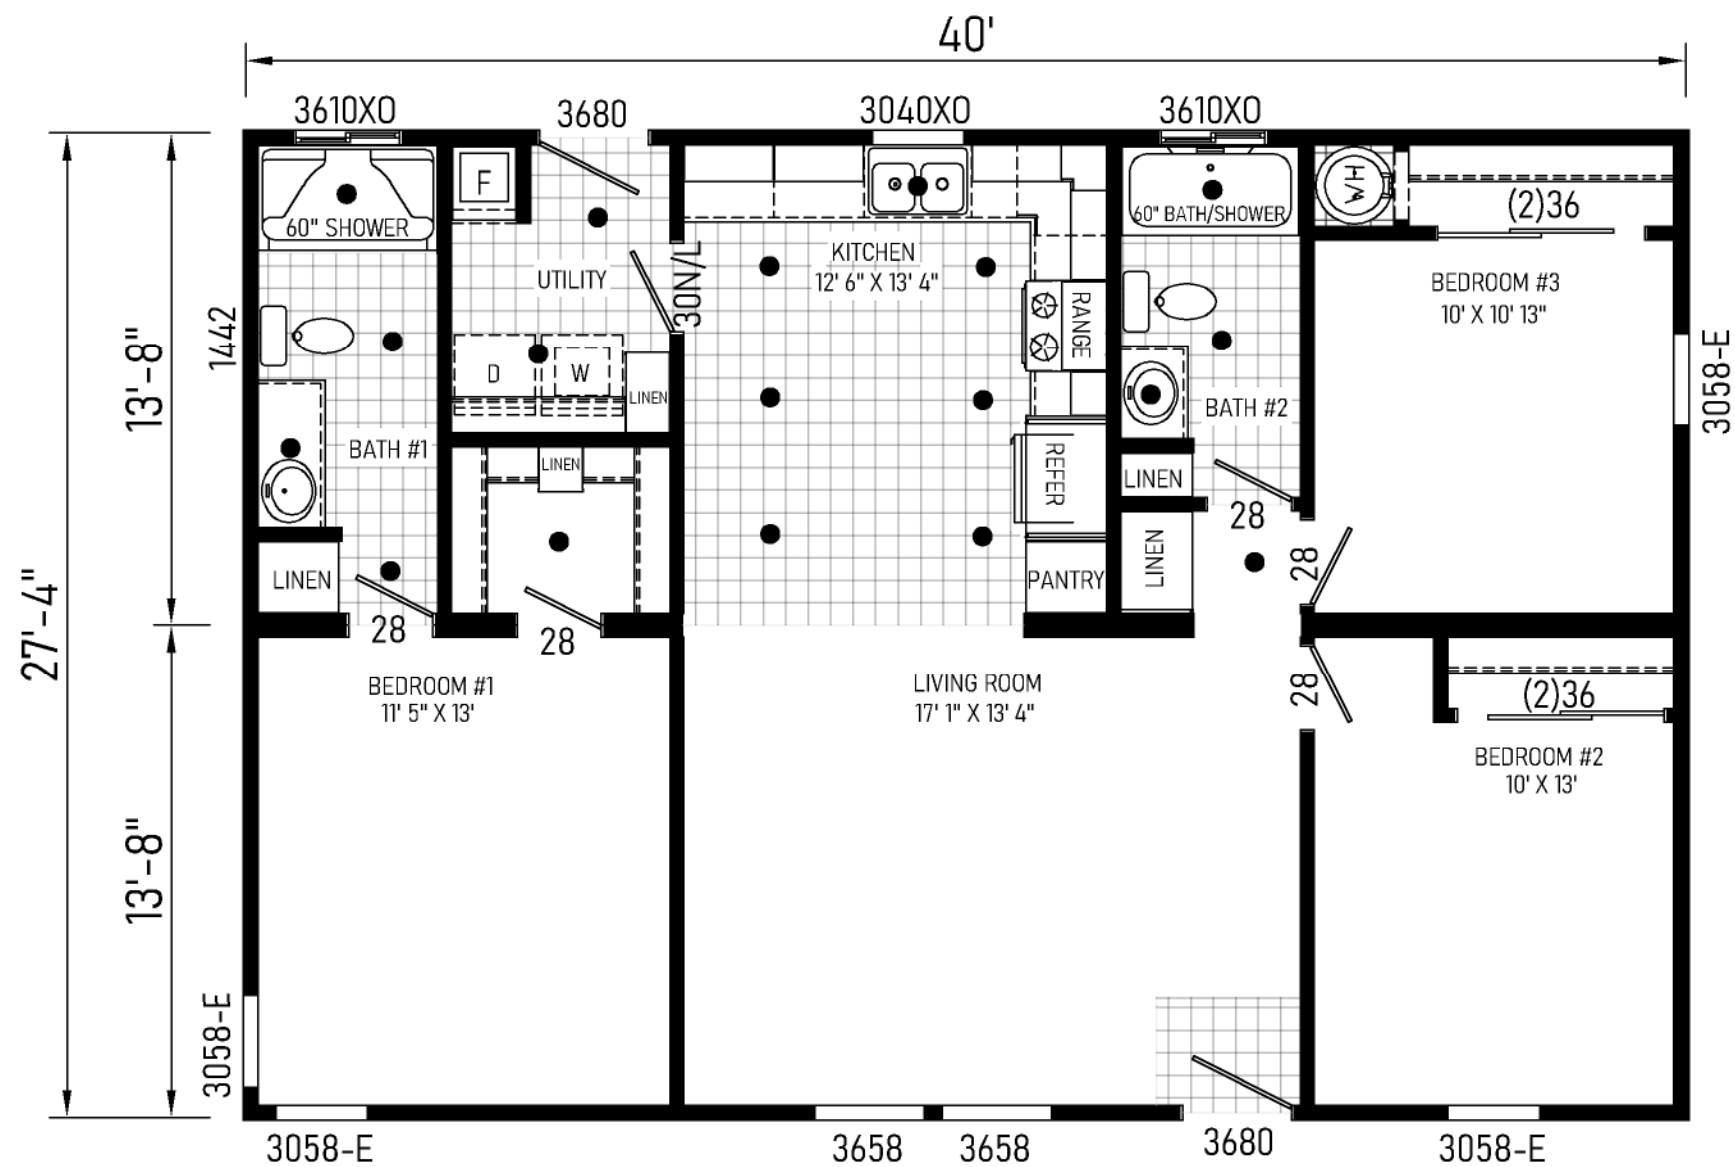

SZ28403A . Approx. 1090 Sq. Ft.

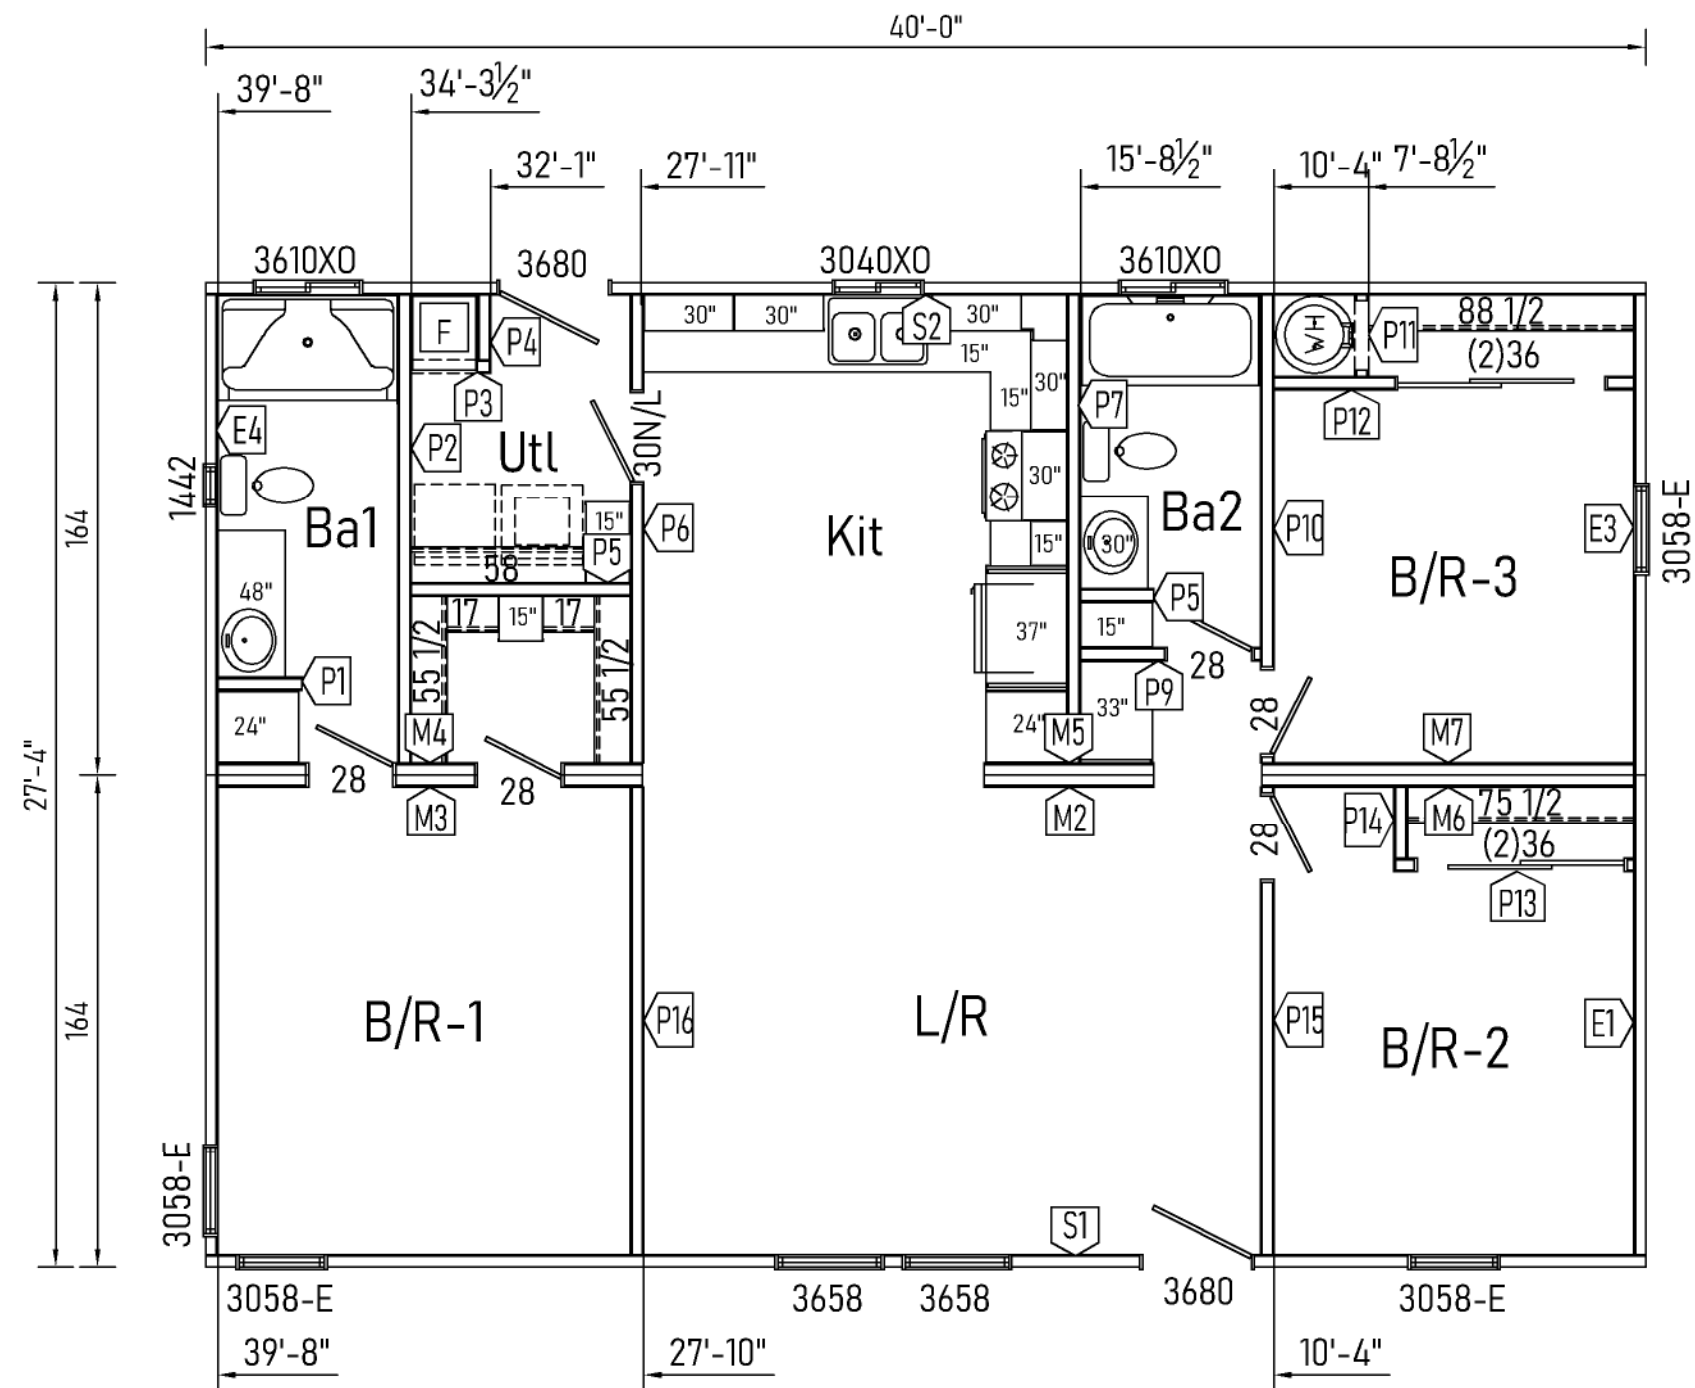

4-1/4" DIA. DRYER VENT CENTER LINE
HEADER HGTS. PER 10-2.4, 10-2.5, 10-2.6

Builder: 130 Cavco-Litchfield

Title: Floor Plan

Address: 1300 S Litchfield Rd. Bldg. 260
Goodyear, AZ 85338

Revisions

Scale: 3/16" = 1'-0"

Date: 11/03/2025

Cust: -

Dir: -

S/N: .

Prod. Code: SZ

Number: 28403A

Order/Plan Number:

Pg.: FP

Run:

Run:

