



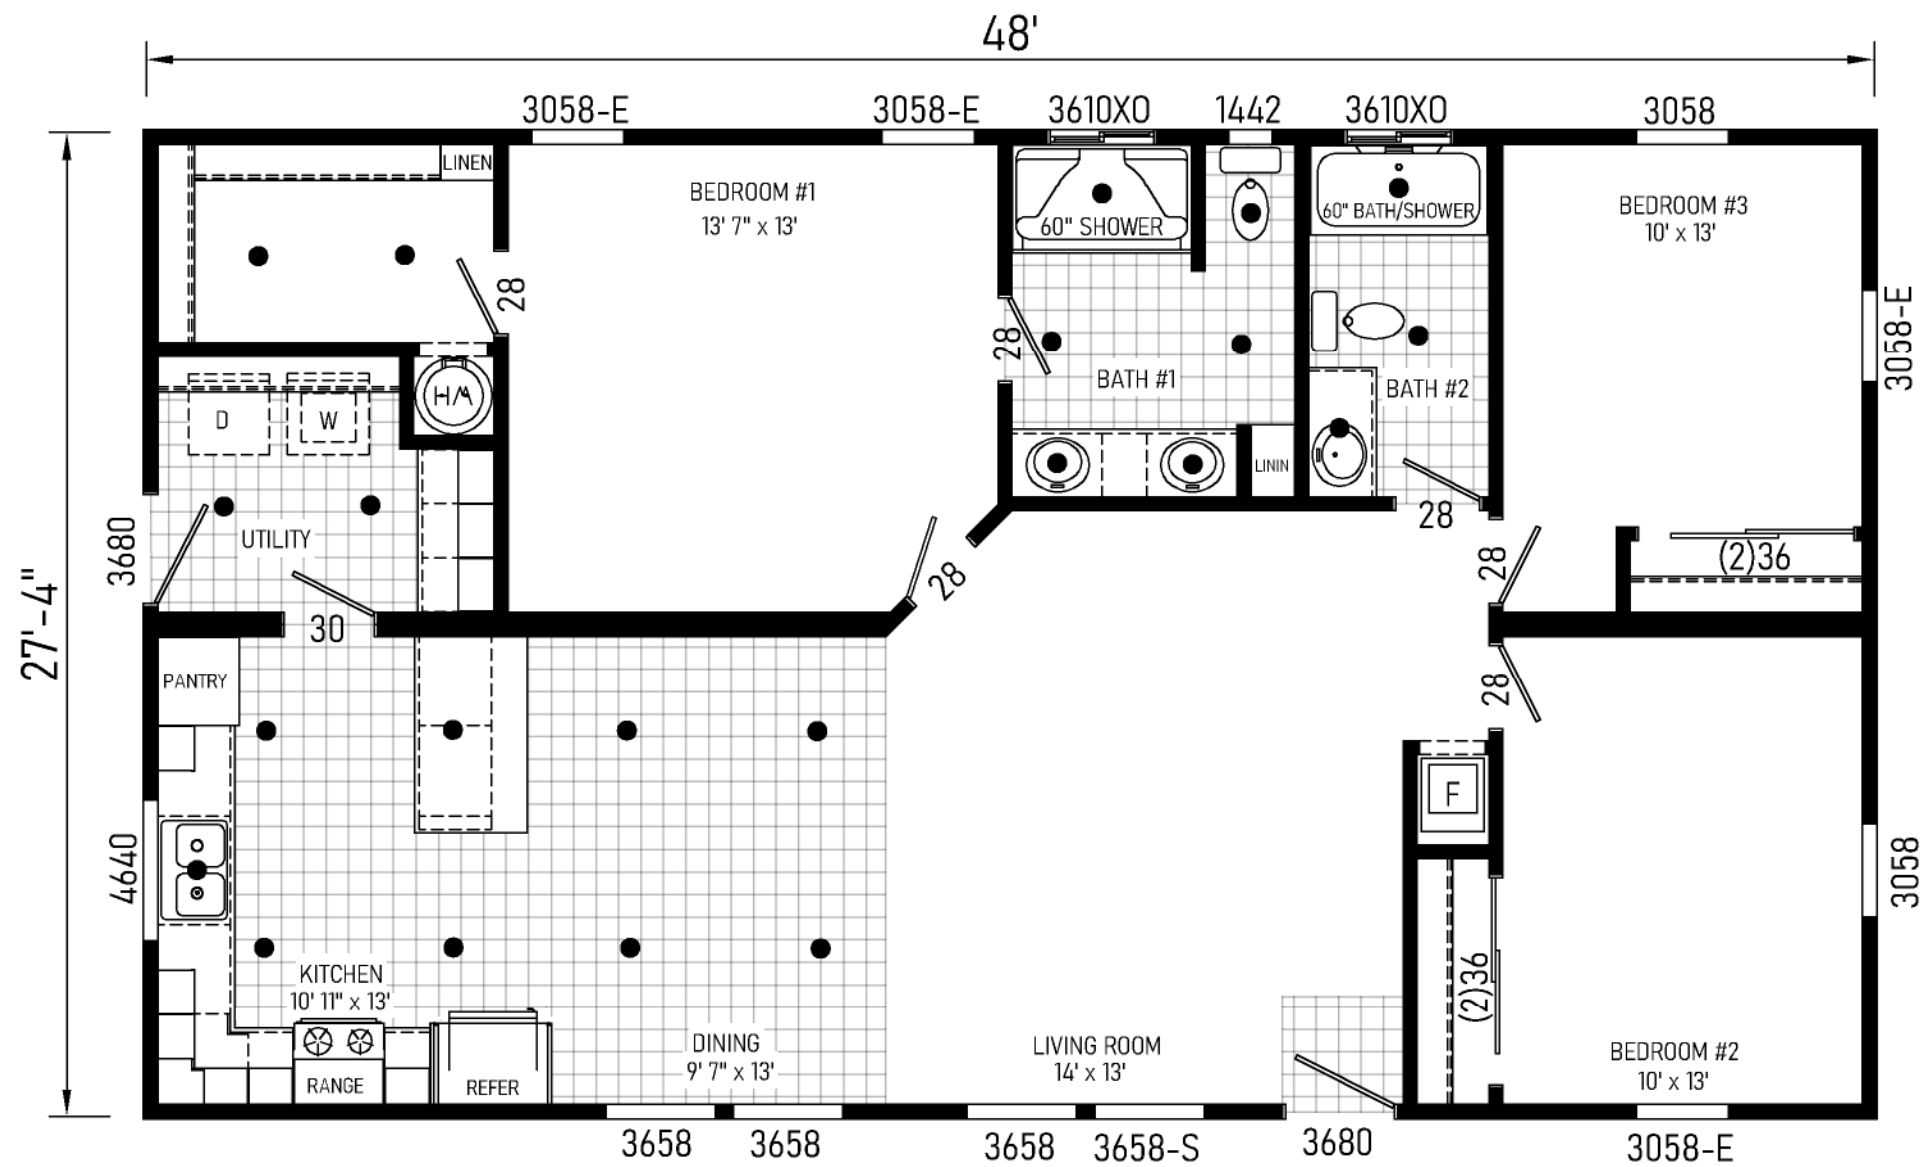

SZ28483A . Approx. 1300 Sq. Ft.

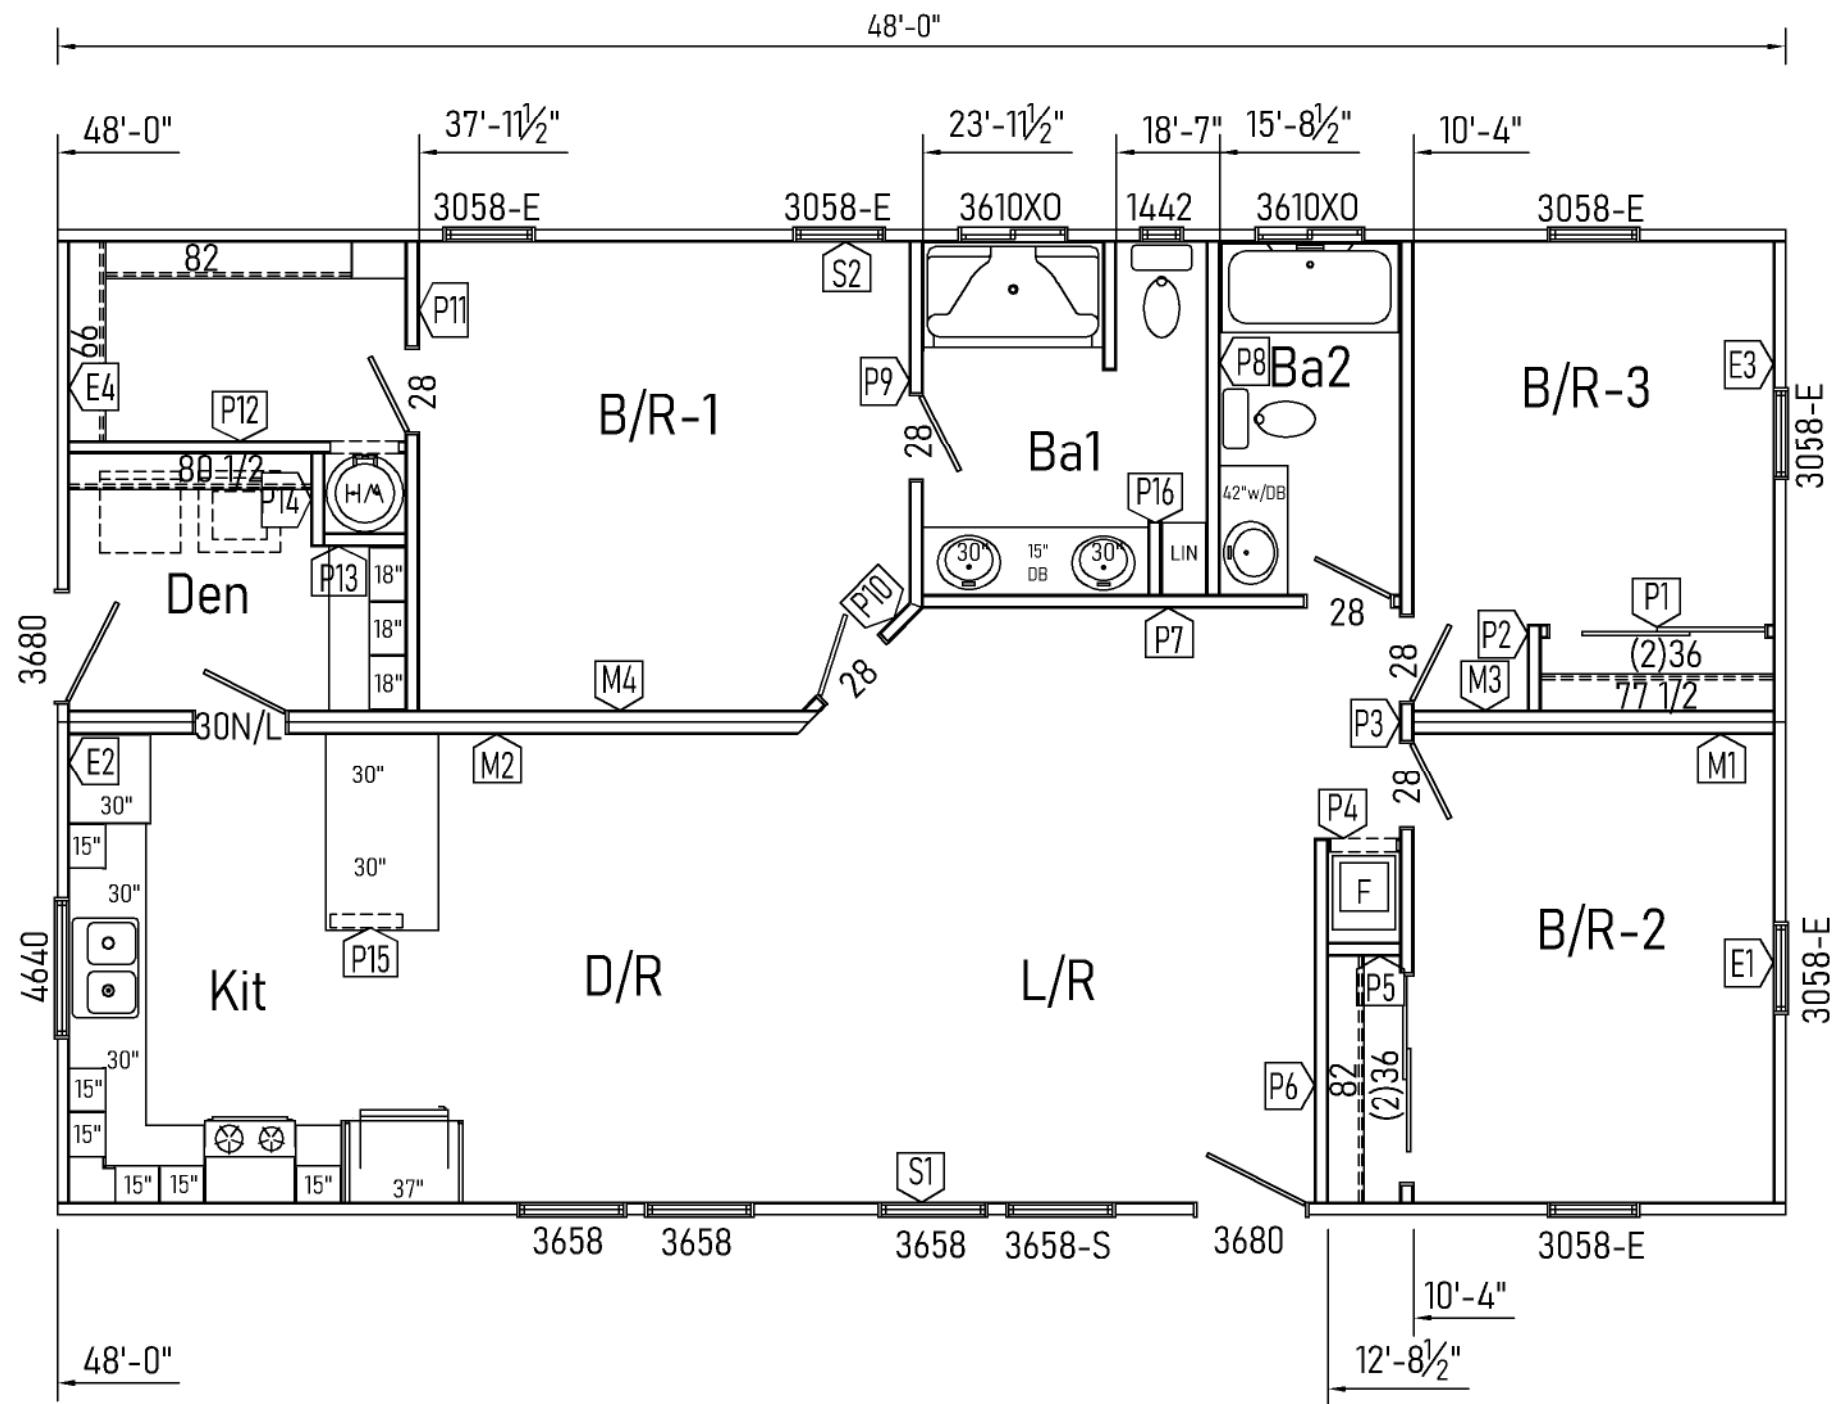

4-1/4" DIA. DRYER VENT CENTER LINE
HEADER HGTS. PER 10-2.4, 10-2.5, 10-2.6

Builder: 130 Cavco-Litchfield	Address: 1300 S Litchfield Rd. Bldg. 260 Goodyear, AZ 85338	Revisions	Scale: 3/16" = 1'-0"	Date: 11/03/2025	Cust: -	Prod. Code: SZ	Number: 28483A	Order/Plan Number:
Title: Floor Plan		Drawn By: KW	Reference:		S/N: .	Pg.: FP	Run:	

25-130S28483A