




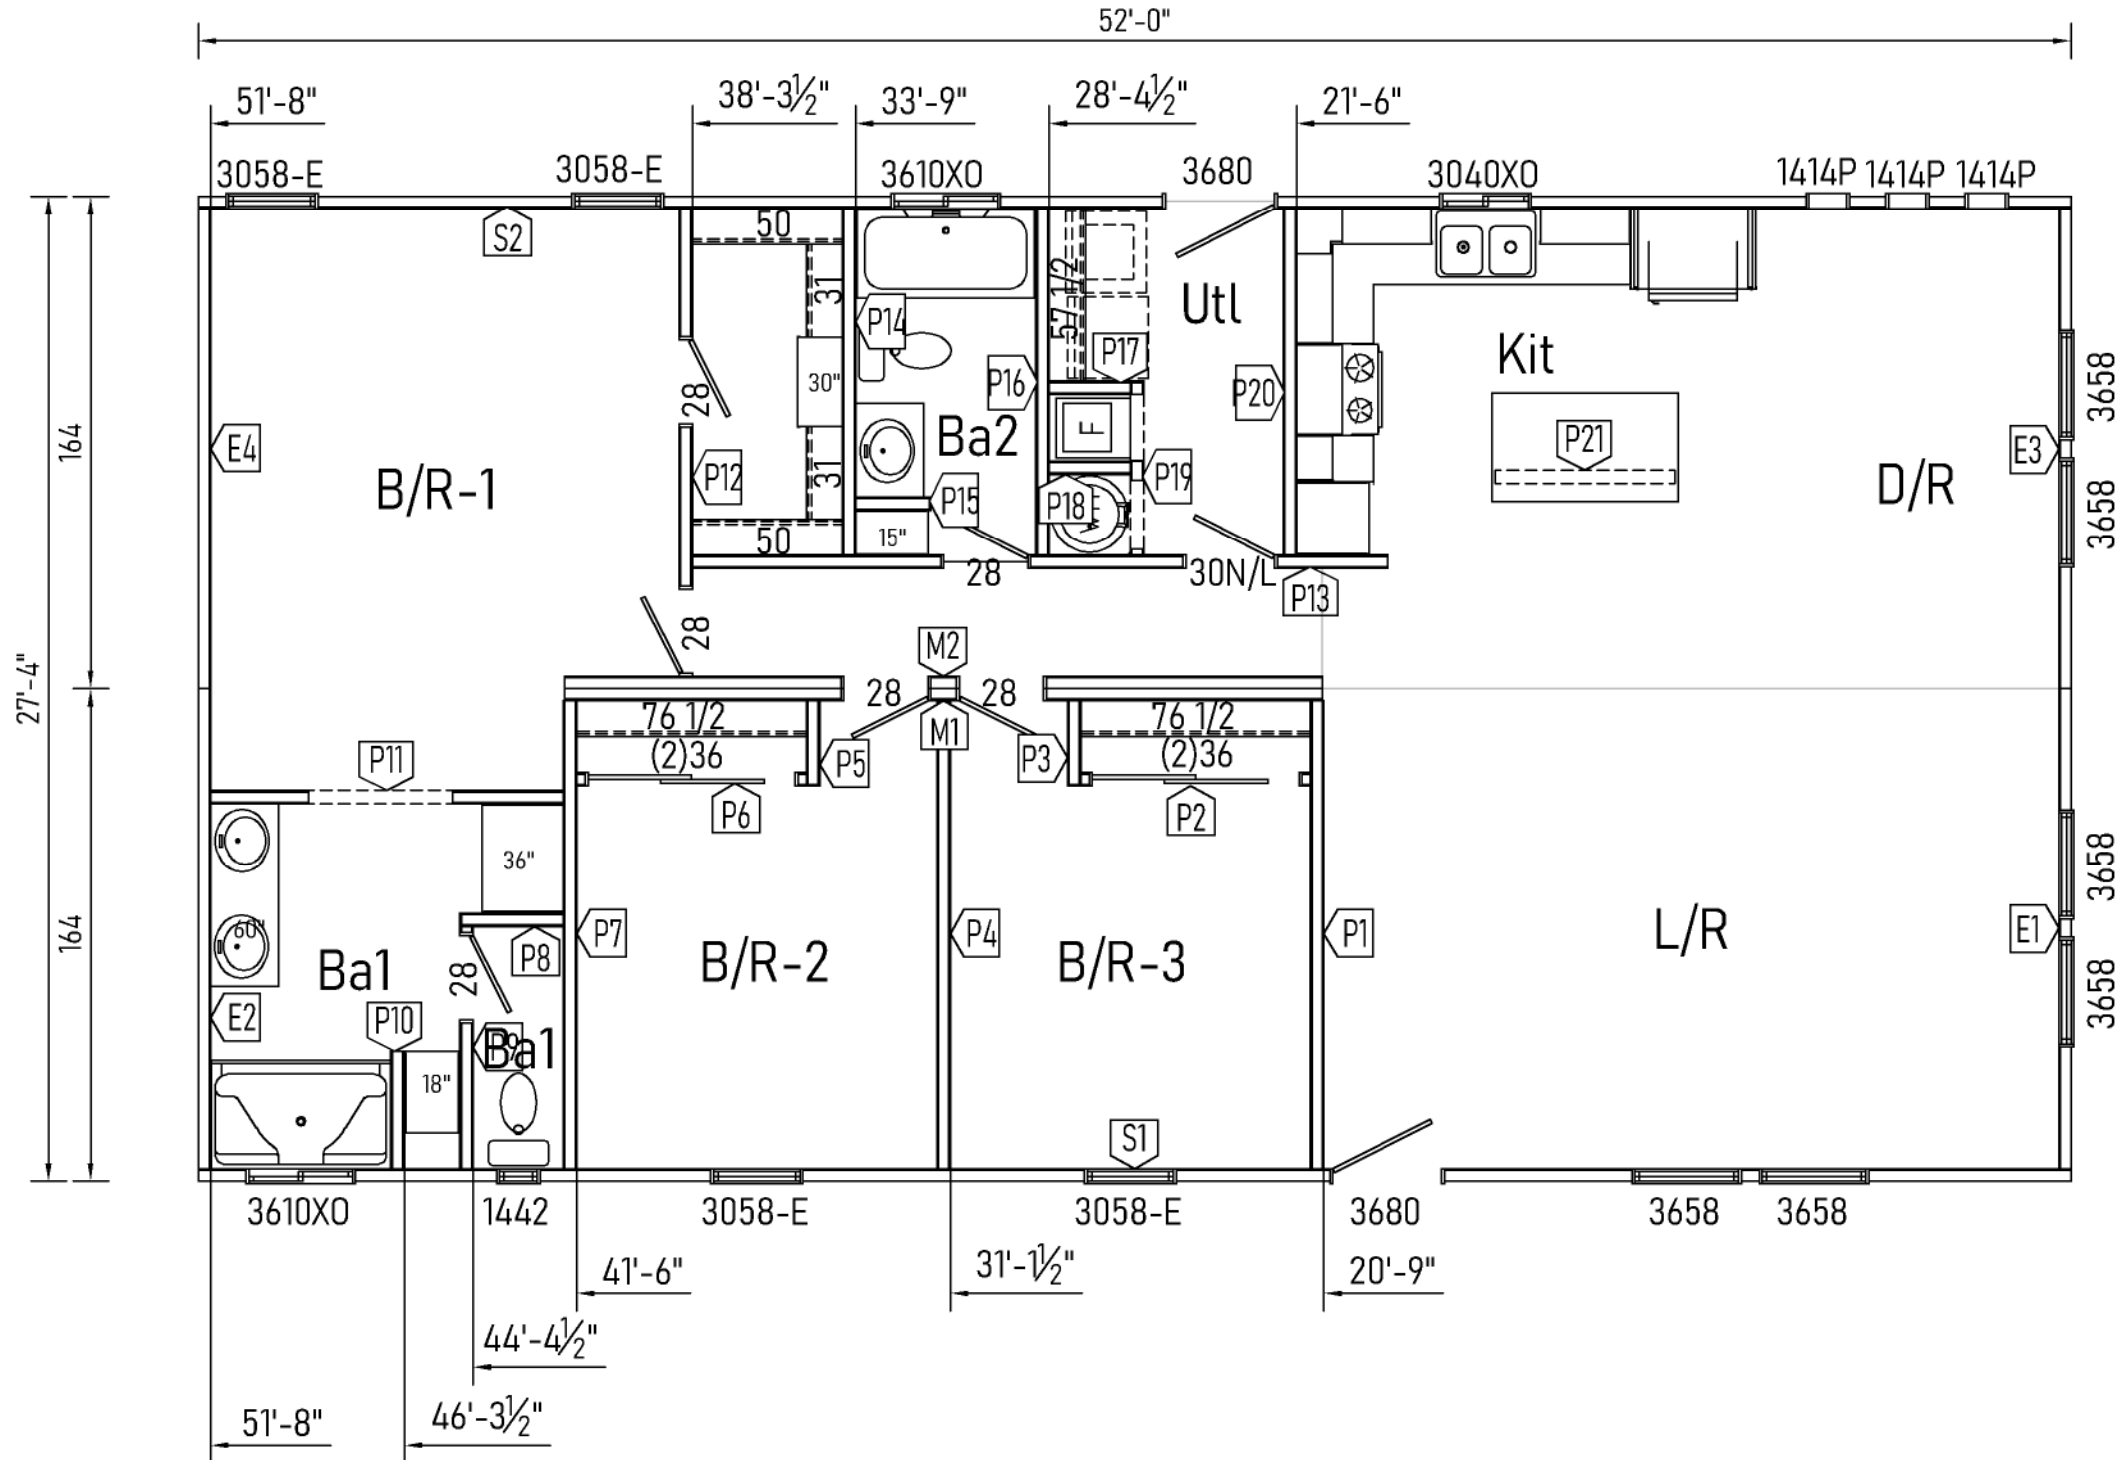

4-1/4" DIA. DRYER VENT CENTER LINE  
HEADER HGTS. PER 10-2.4, 10-2.5, 10-2.6

Builder: 130 Cavco-Litchfield

Title: Floor Plan

Address: 1300 S Litchfield Rd. Bldg. 260  
Goodyear, AZ 85338

Revisions

Scale: 3/16" = 1'-0"

Date: 10/31/2025

Cust: -

Dir: -

S/N: -

Prod. Code: SZ

Number: 28523B

Order/Plan Number: -

Pg.: -

FP

Run: -

25-130S228523B