


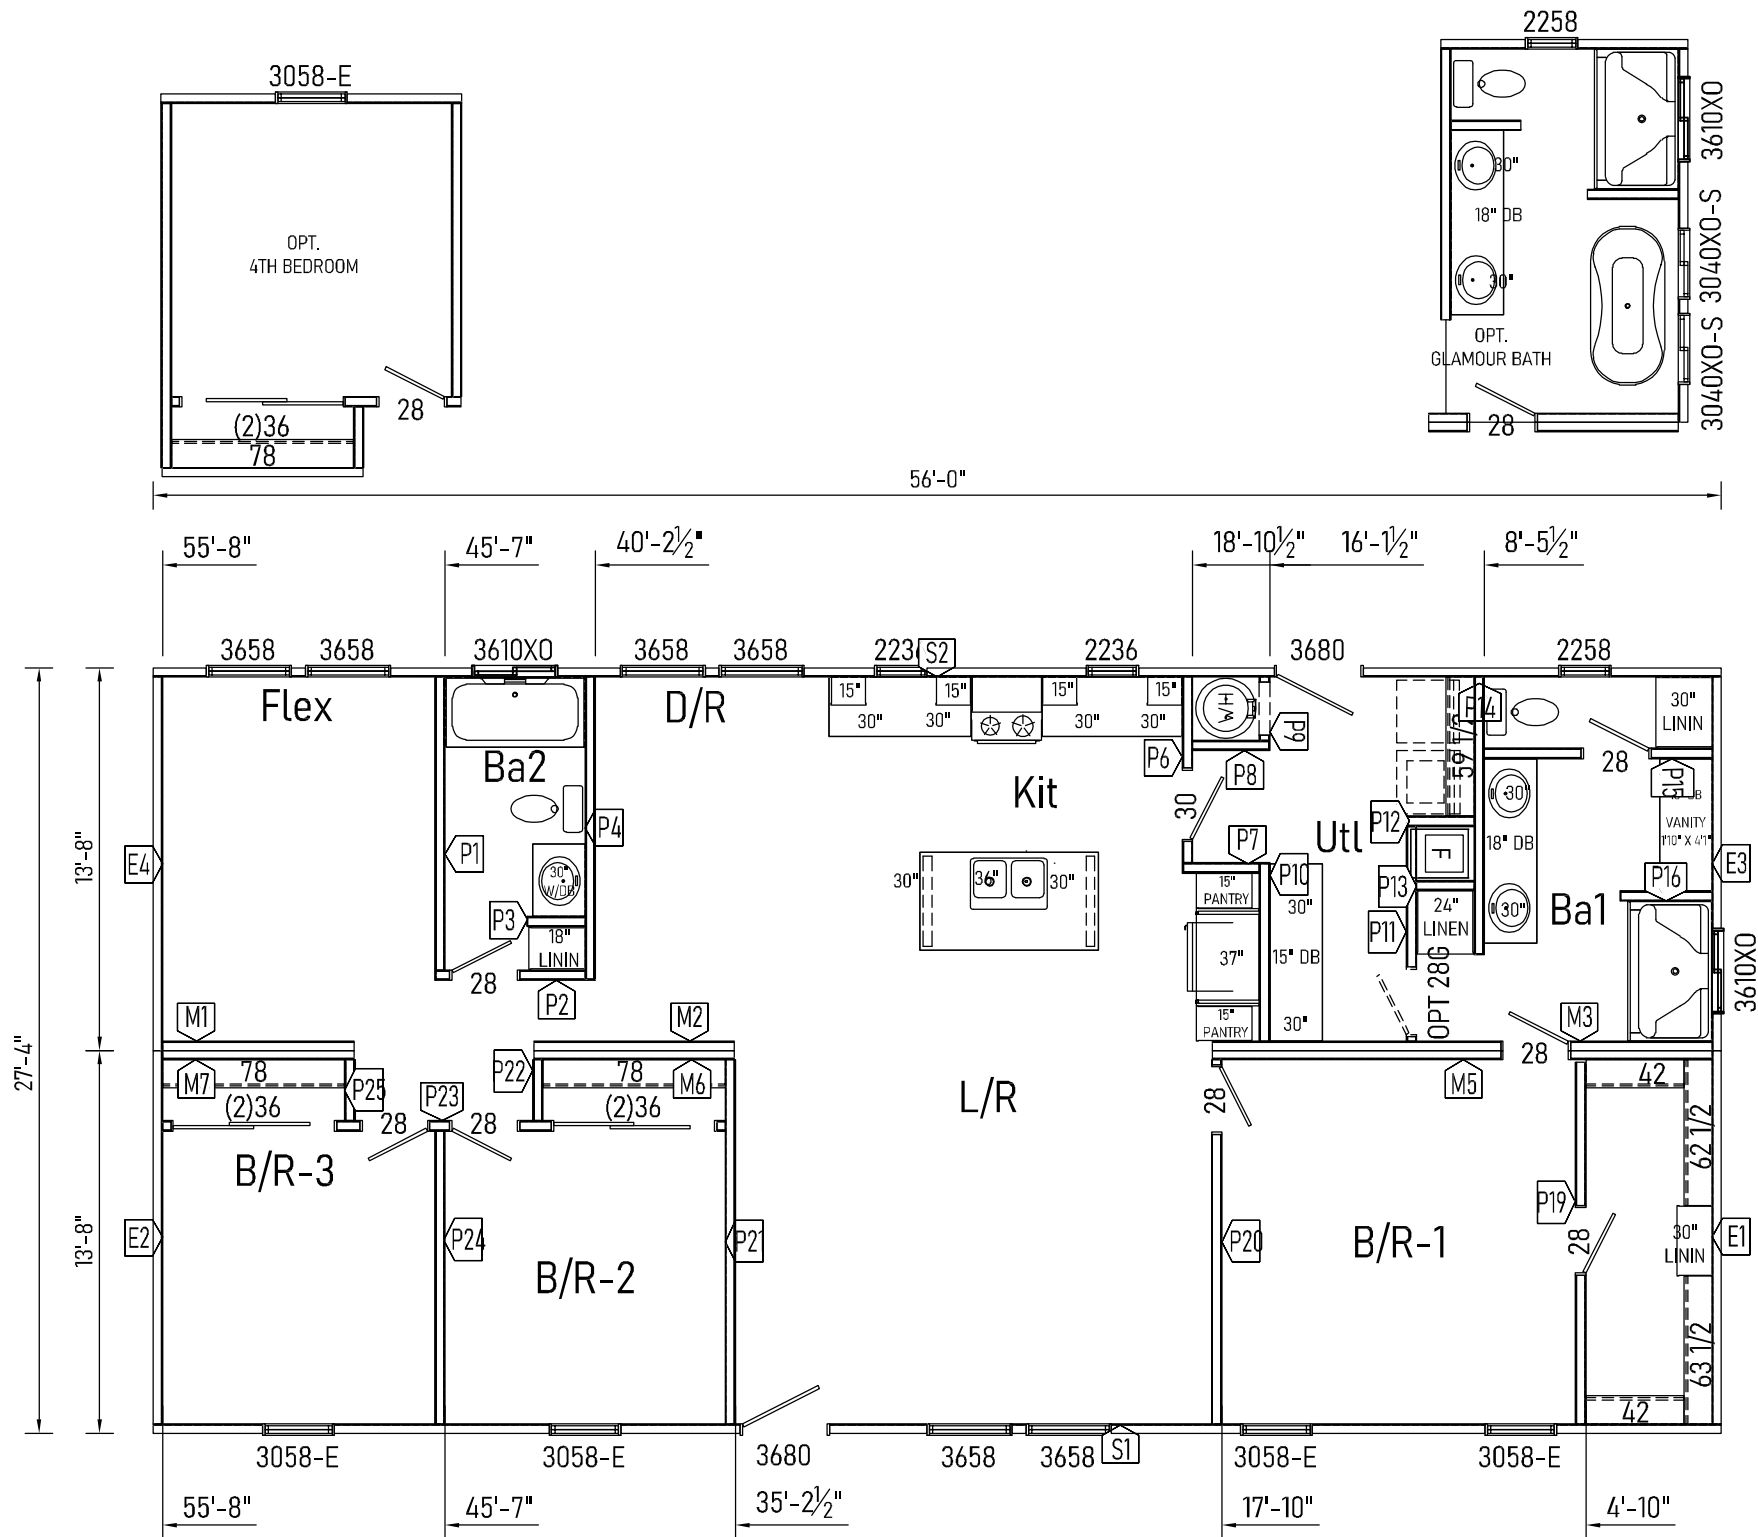

SZ28563A Approx. 1530 Sq. Ft.



Ø 4-1/4" DIA. DRYER VENT CENTER LINE
HEADER HGTS. PER 10-2.4, 10-2.5, 10-2.6

Builder: 130 Cavco-Litchfield	Address: 1300 S Litchfield Rd. Bldg. 260 Goodyear, AZ 85338	Revisions		Scale: 3/16" = 1'-0"	Date: 11/03/2025	Cust: -	Prod. Code: SZ	Number: 28563A	Order/Plan Number:	
		Drawn By: KW		Reference:		Dlr: -	Pg: FP		Run:	

Title: Floor Plan

130S28563A2025-0000000