



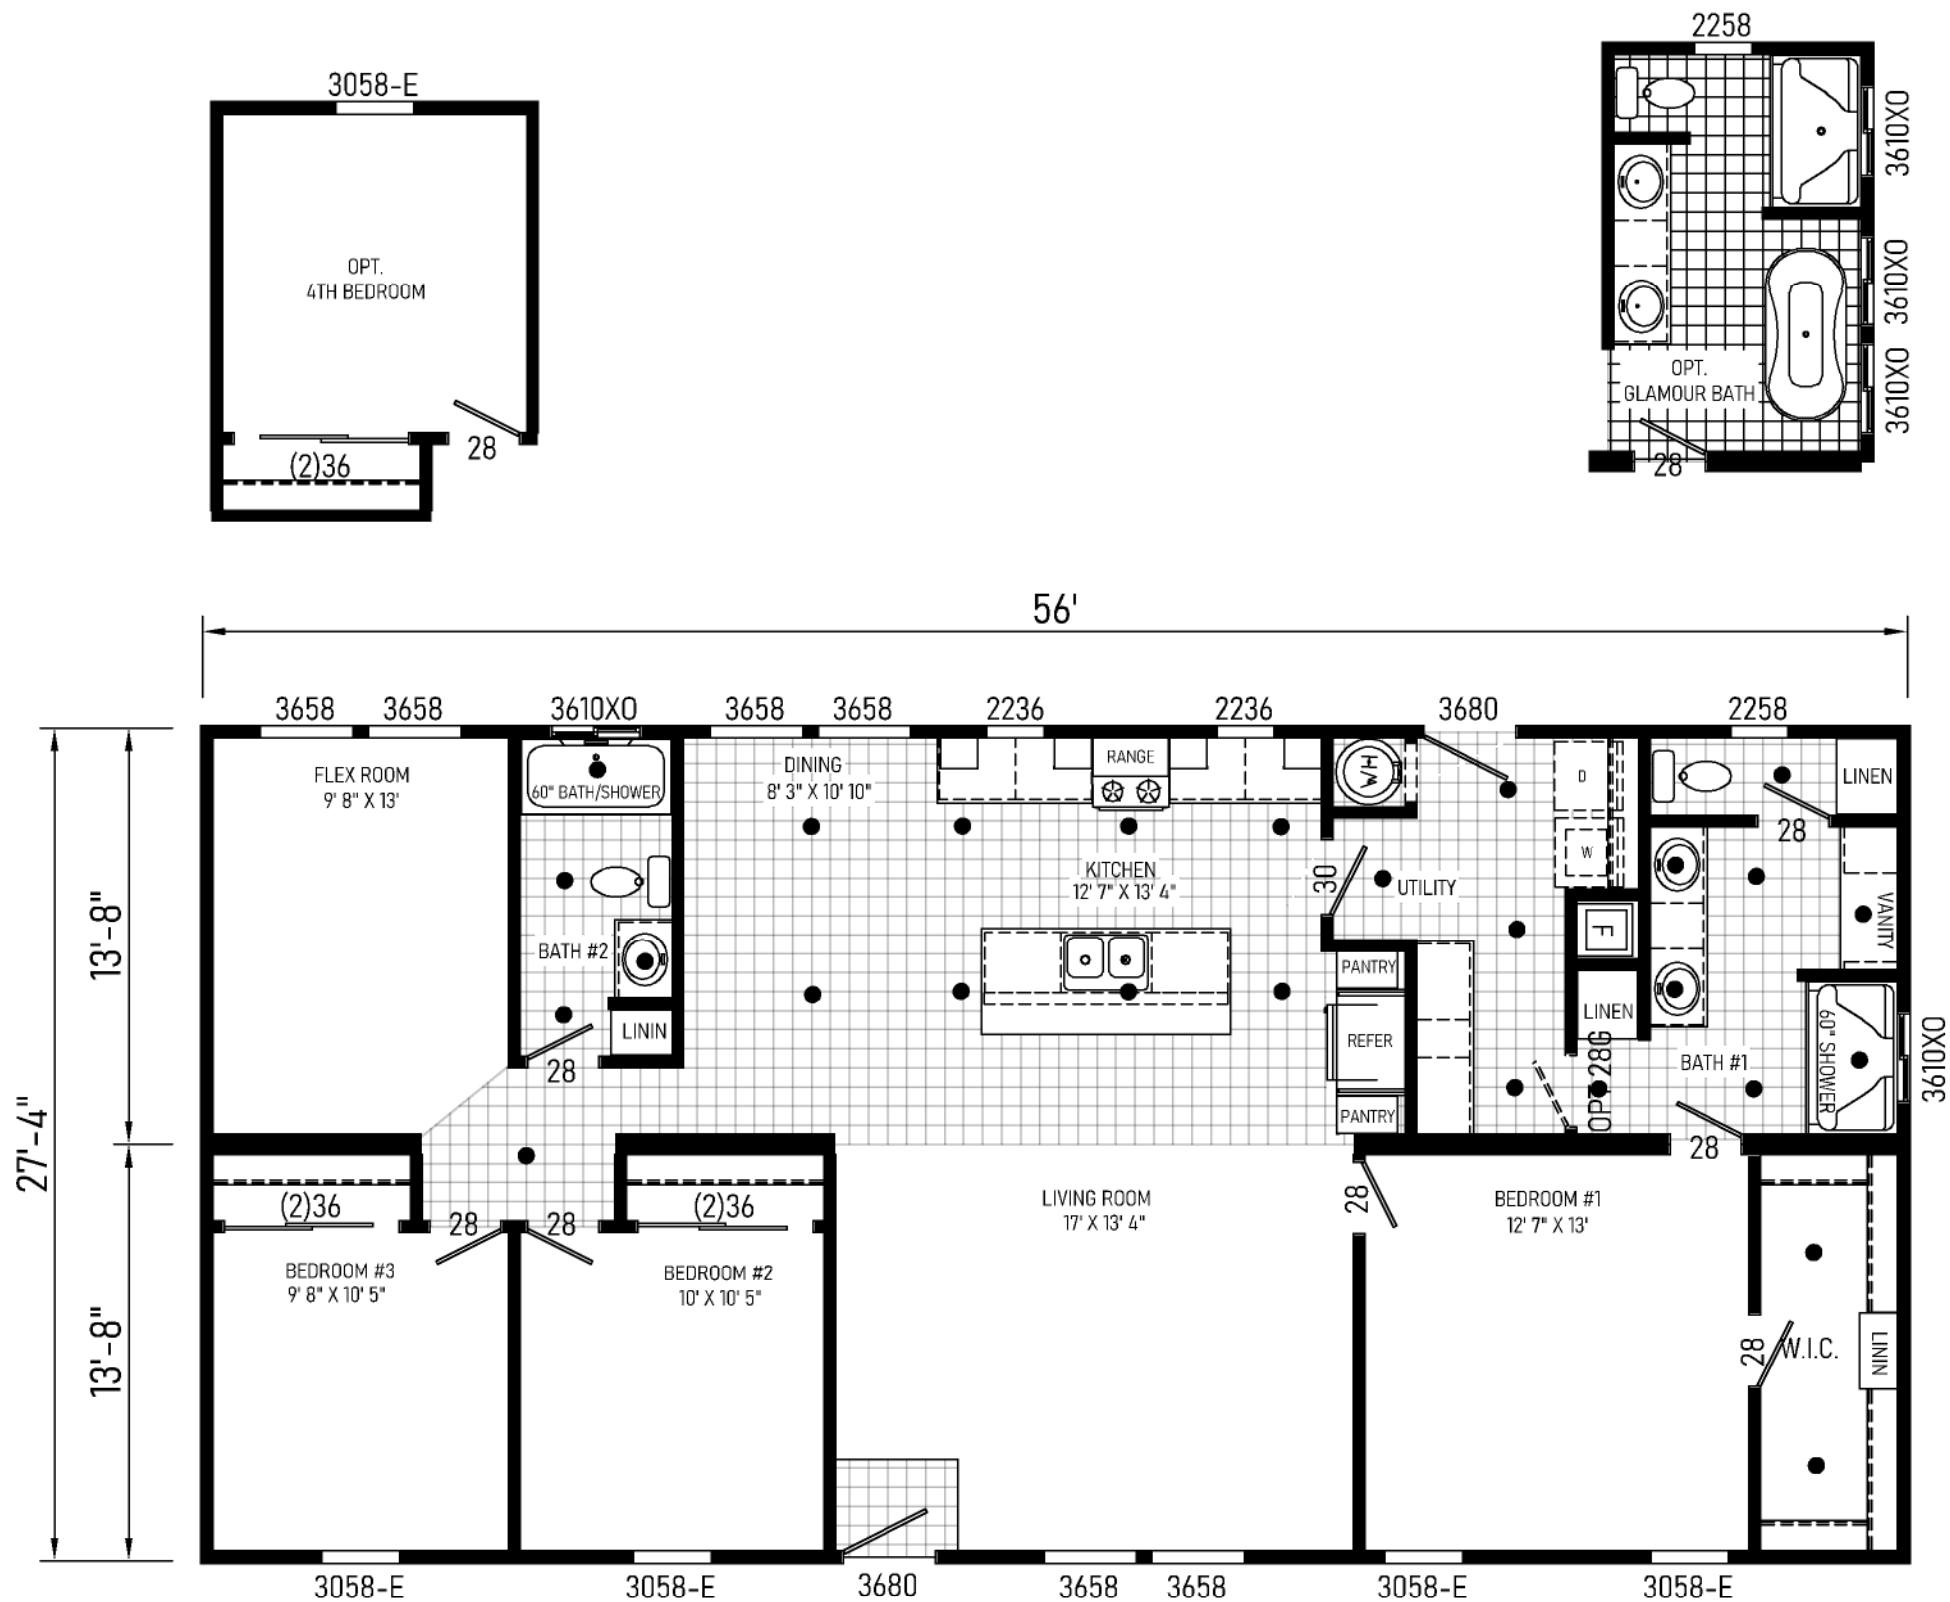

SZ28563B . Approx. 1525 Sq. Ft.

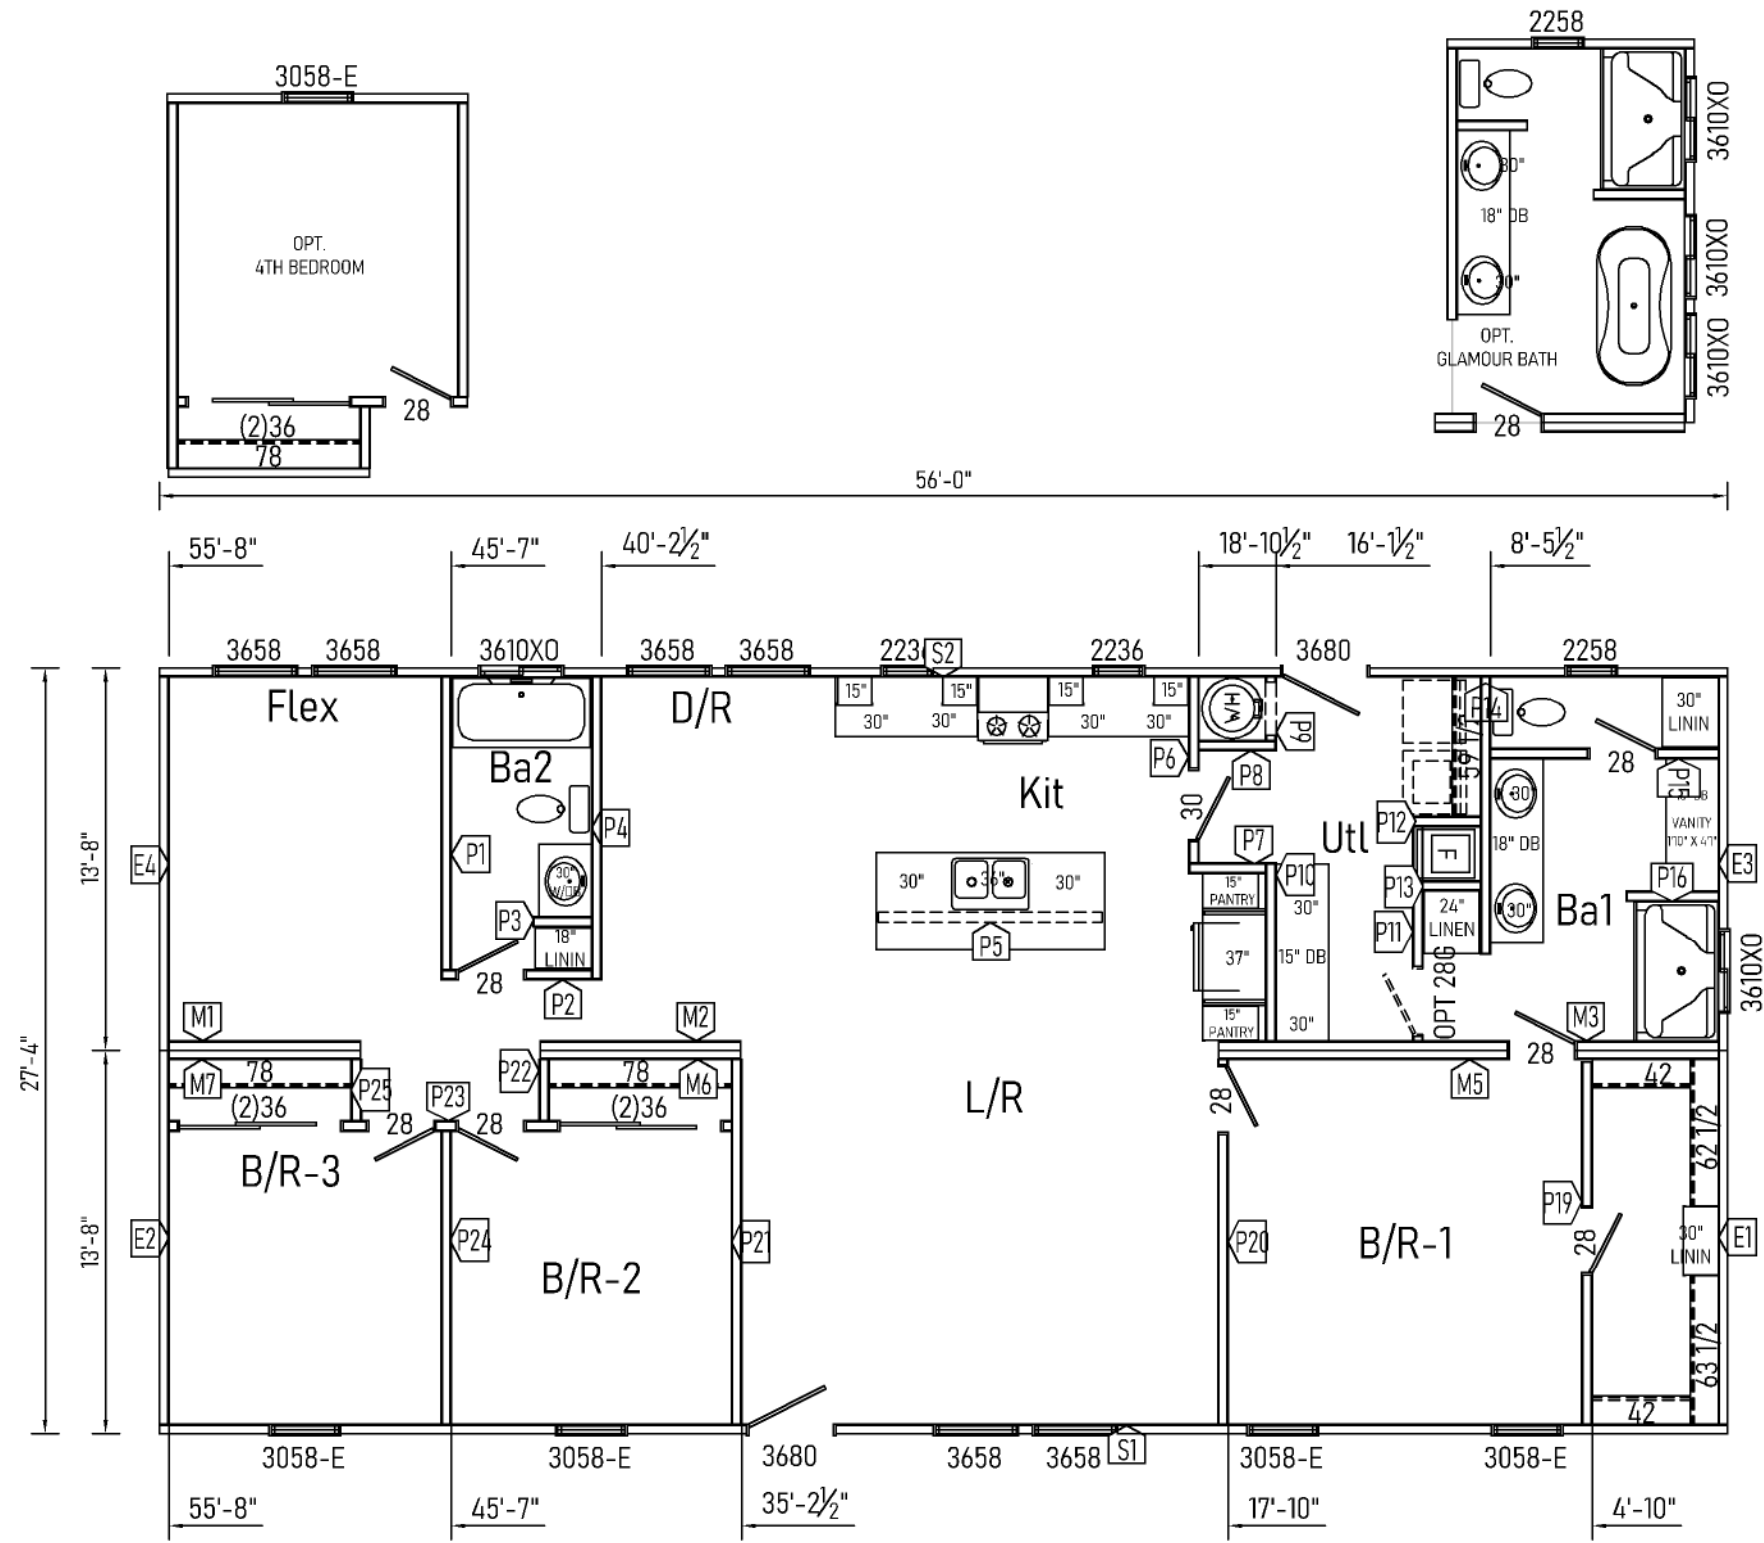

4-1/4" DIA. DRYER VENT CENTER LINE
HEADER HGTS. PER 10-2.4, 10-2.5, 10-2.6

Builder: 130 Cavco-Litchfield		Address: 1300 S Litchfield Rd. Bldg. 260 Goodyear, AZ 85338		Revisions	Scale: 3/16" = 1'-0"	Date: 11/03/2025	Cust: -	Prod. Code: SZ	Number: 28563B	Order/Plan Number:	
Title: Floor Plan		Drawn By: KW			Reference:		Dir: -	Pg.: FP		Run:	
							S/N: .				

25-130SZ28563B