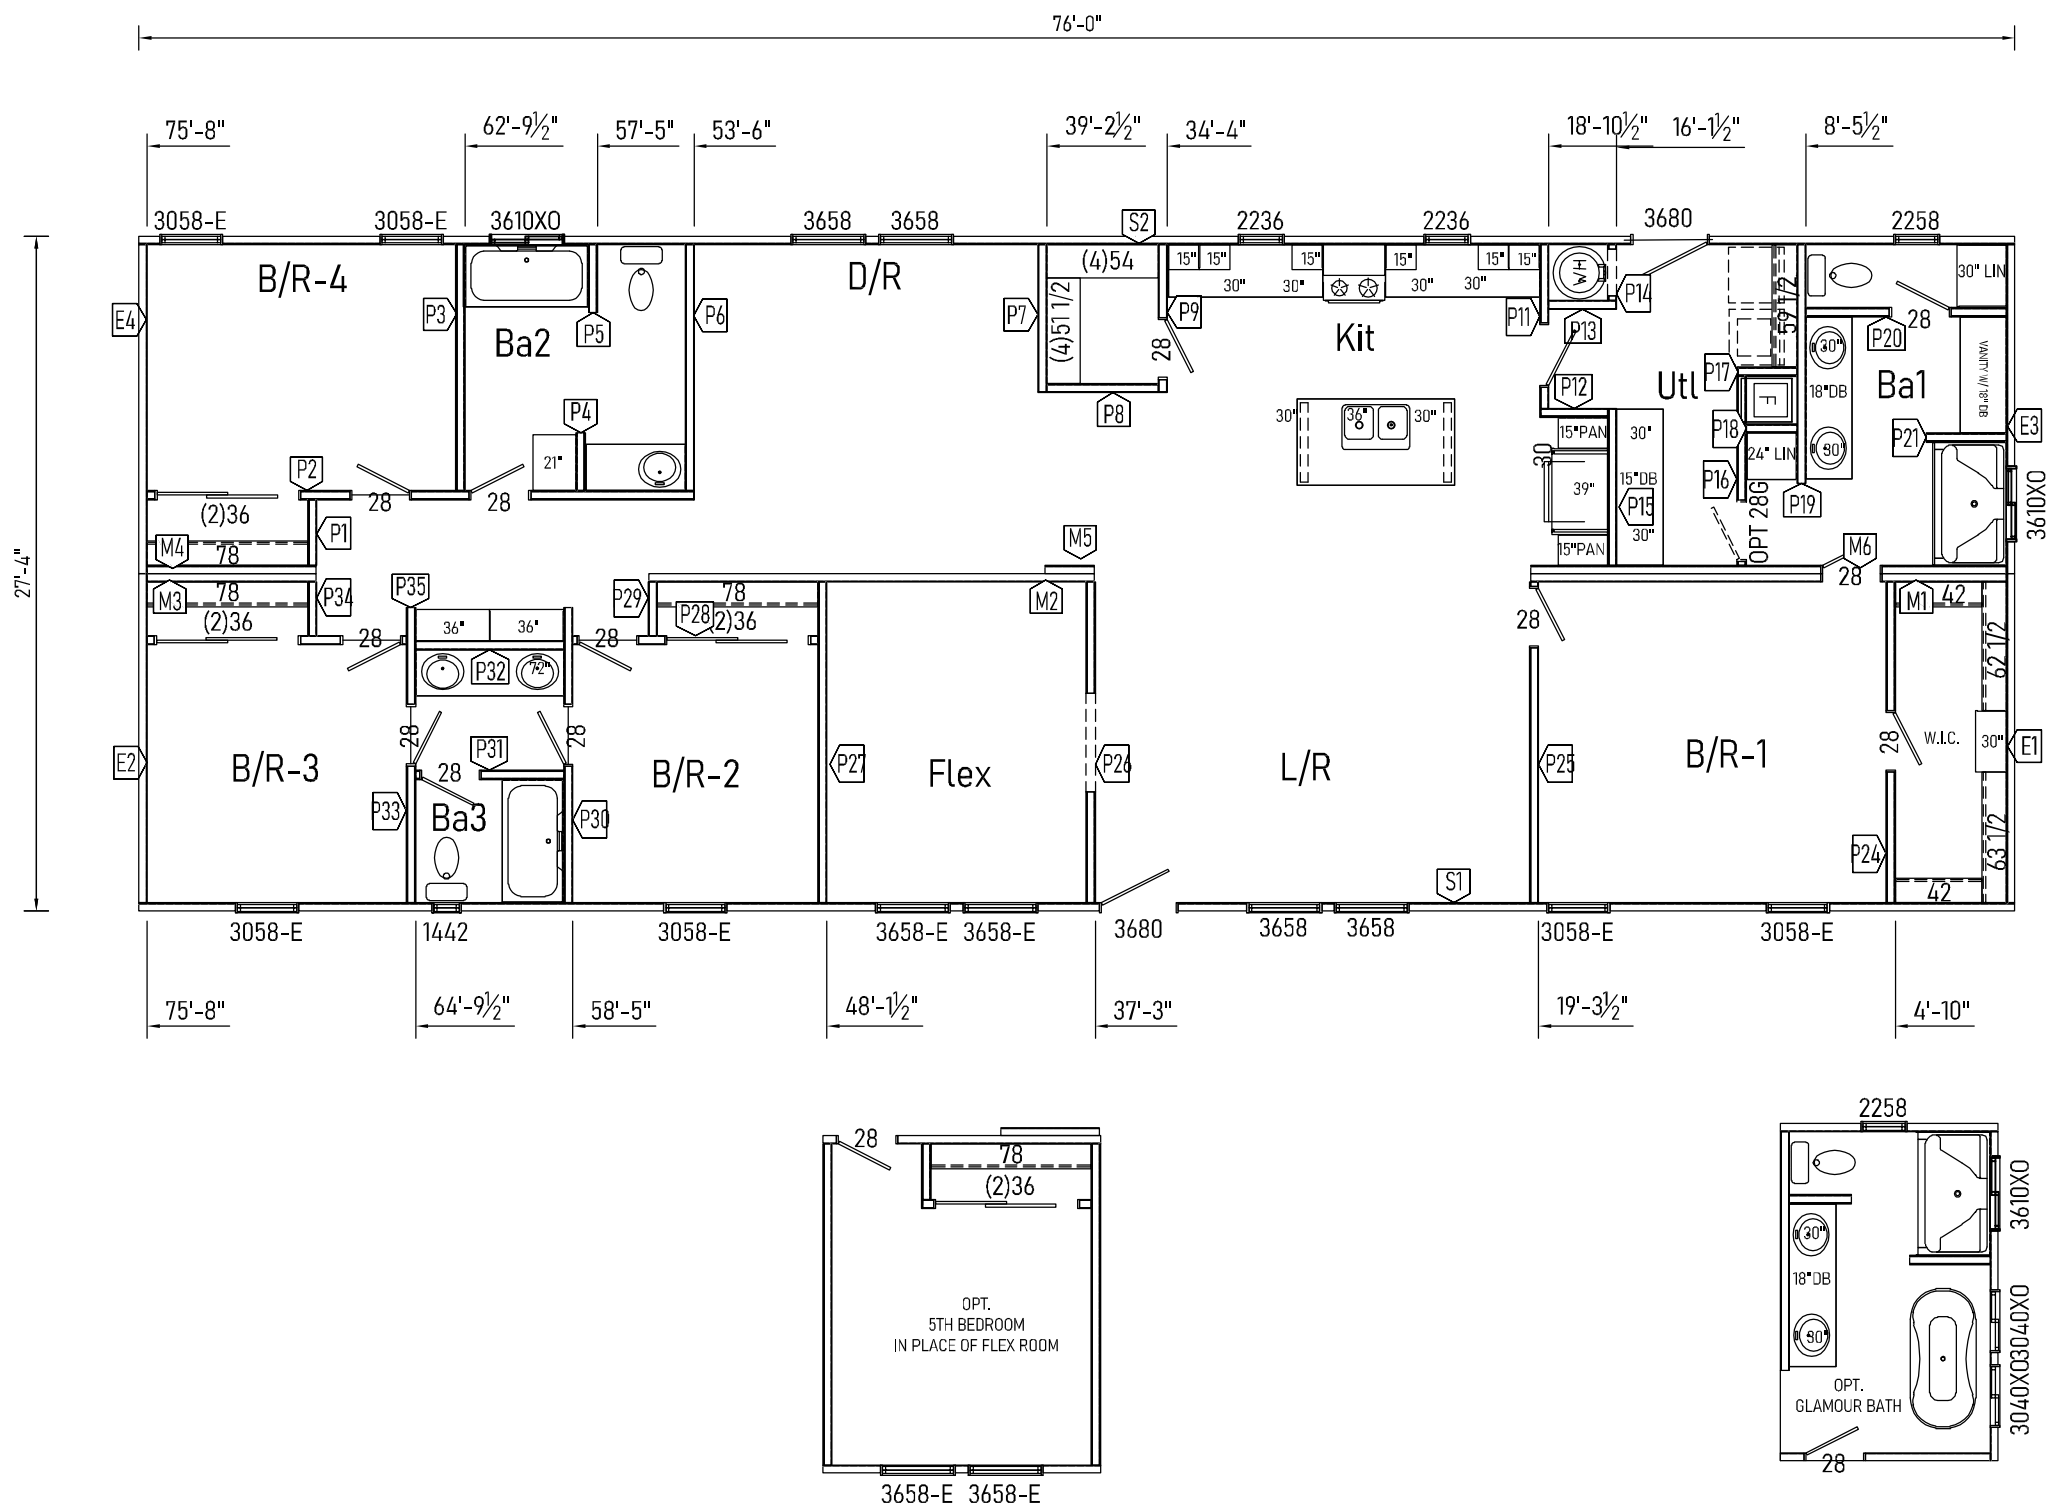


4-1/4" DIA. DRYER VENT CENTER LINE
HEADER HGTS. PER 10-2.4, 10-2.5, 10-2.6

Builder: 130 Cavco-Litchfield

Title: Floor Plan

Address: 1300 S Litchfield Rd. Bldg. 260
Goodyear, AZ 85338

Revisions

Scale: 3/16" = 1'-0"

Drawn By: KW

Date: 11/04/2025

Reference:

Cust: -

Dlr: -

S/N: .

Prod. Code:

SZ

Pg.: FP

Number:

28764A

Run:

Order/Plan Number:

.

Run:

25-1305Z8764A