




GROUND FLOOR  
SCALE 1 : 75

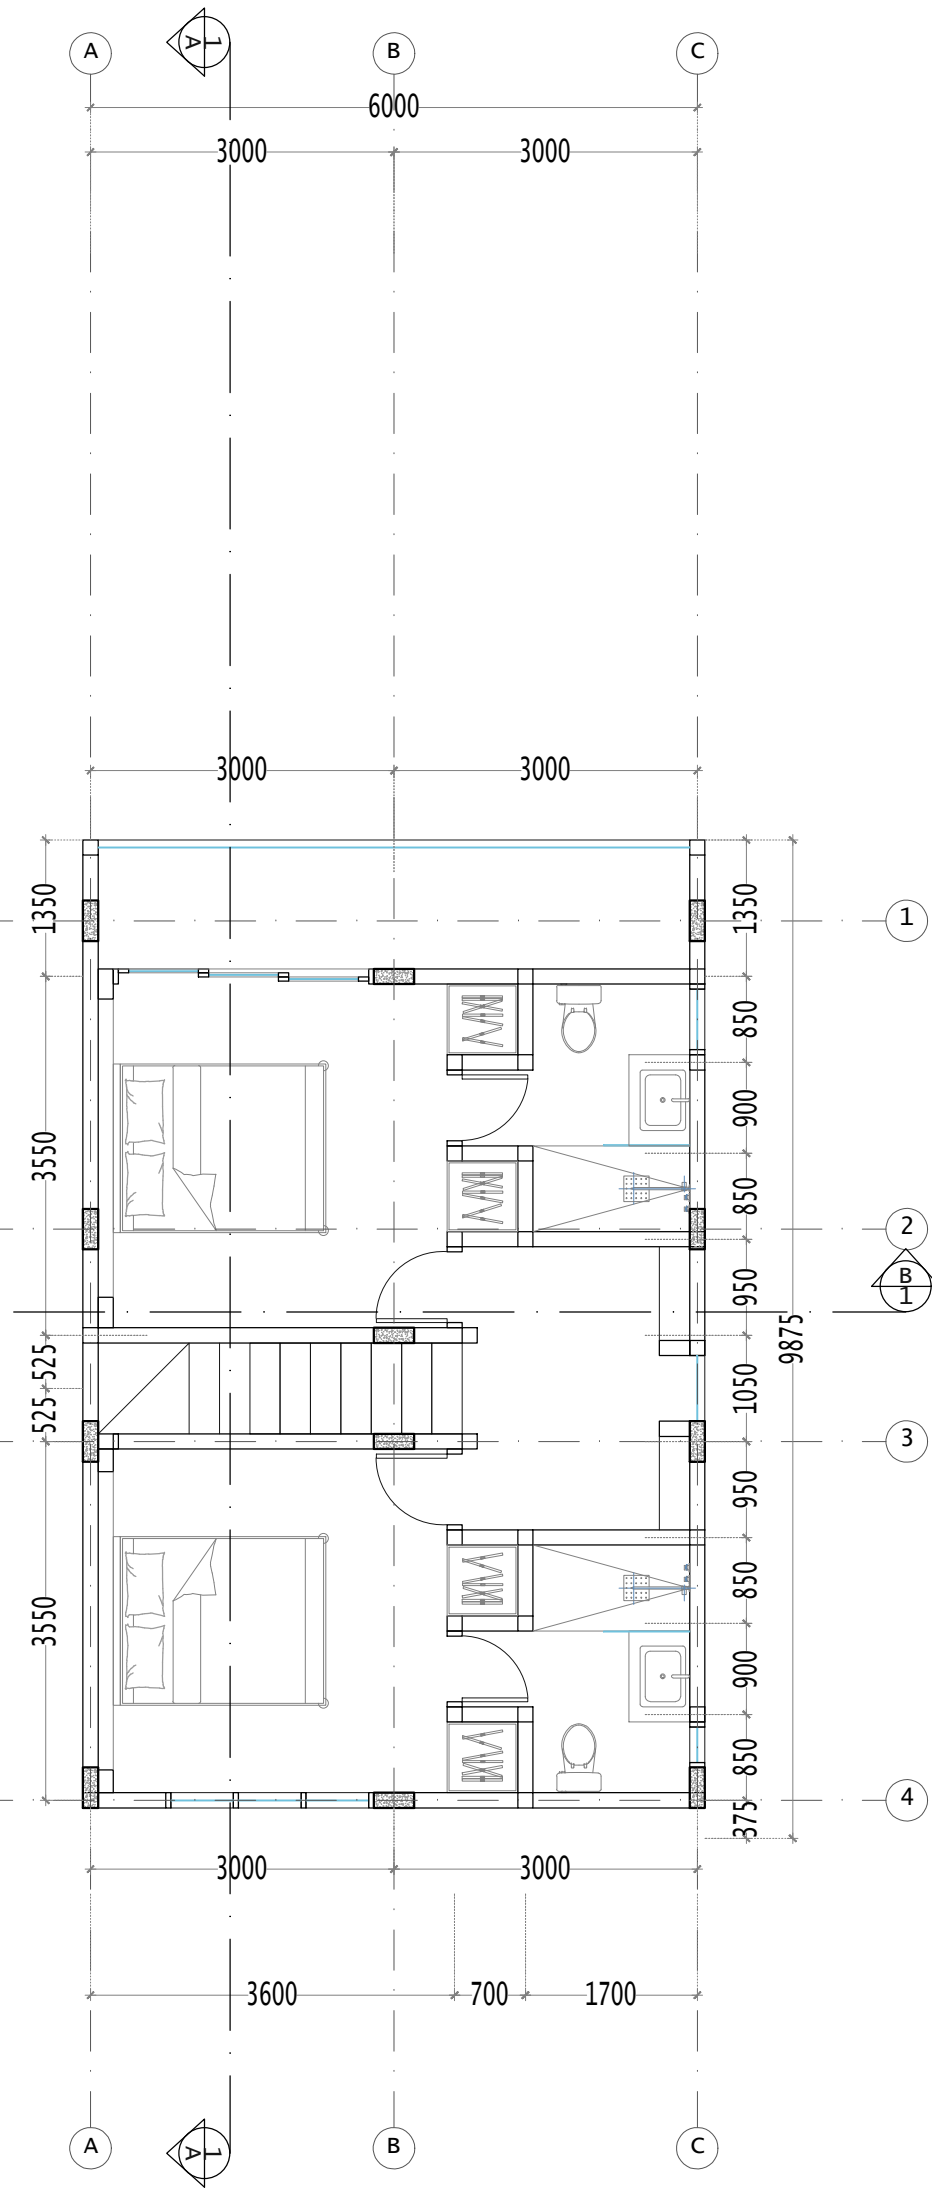



SECOND FLOOR  
SCALE 1 : 75

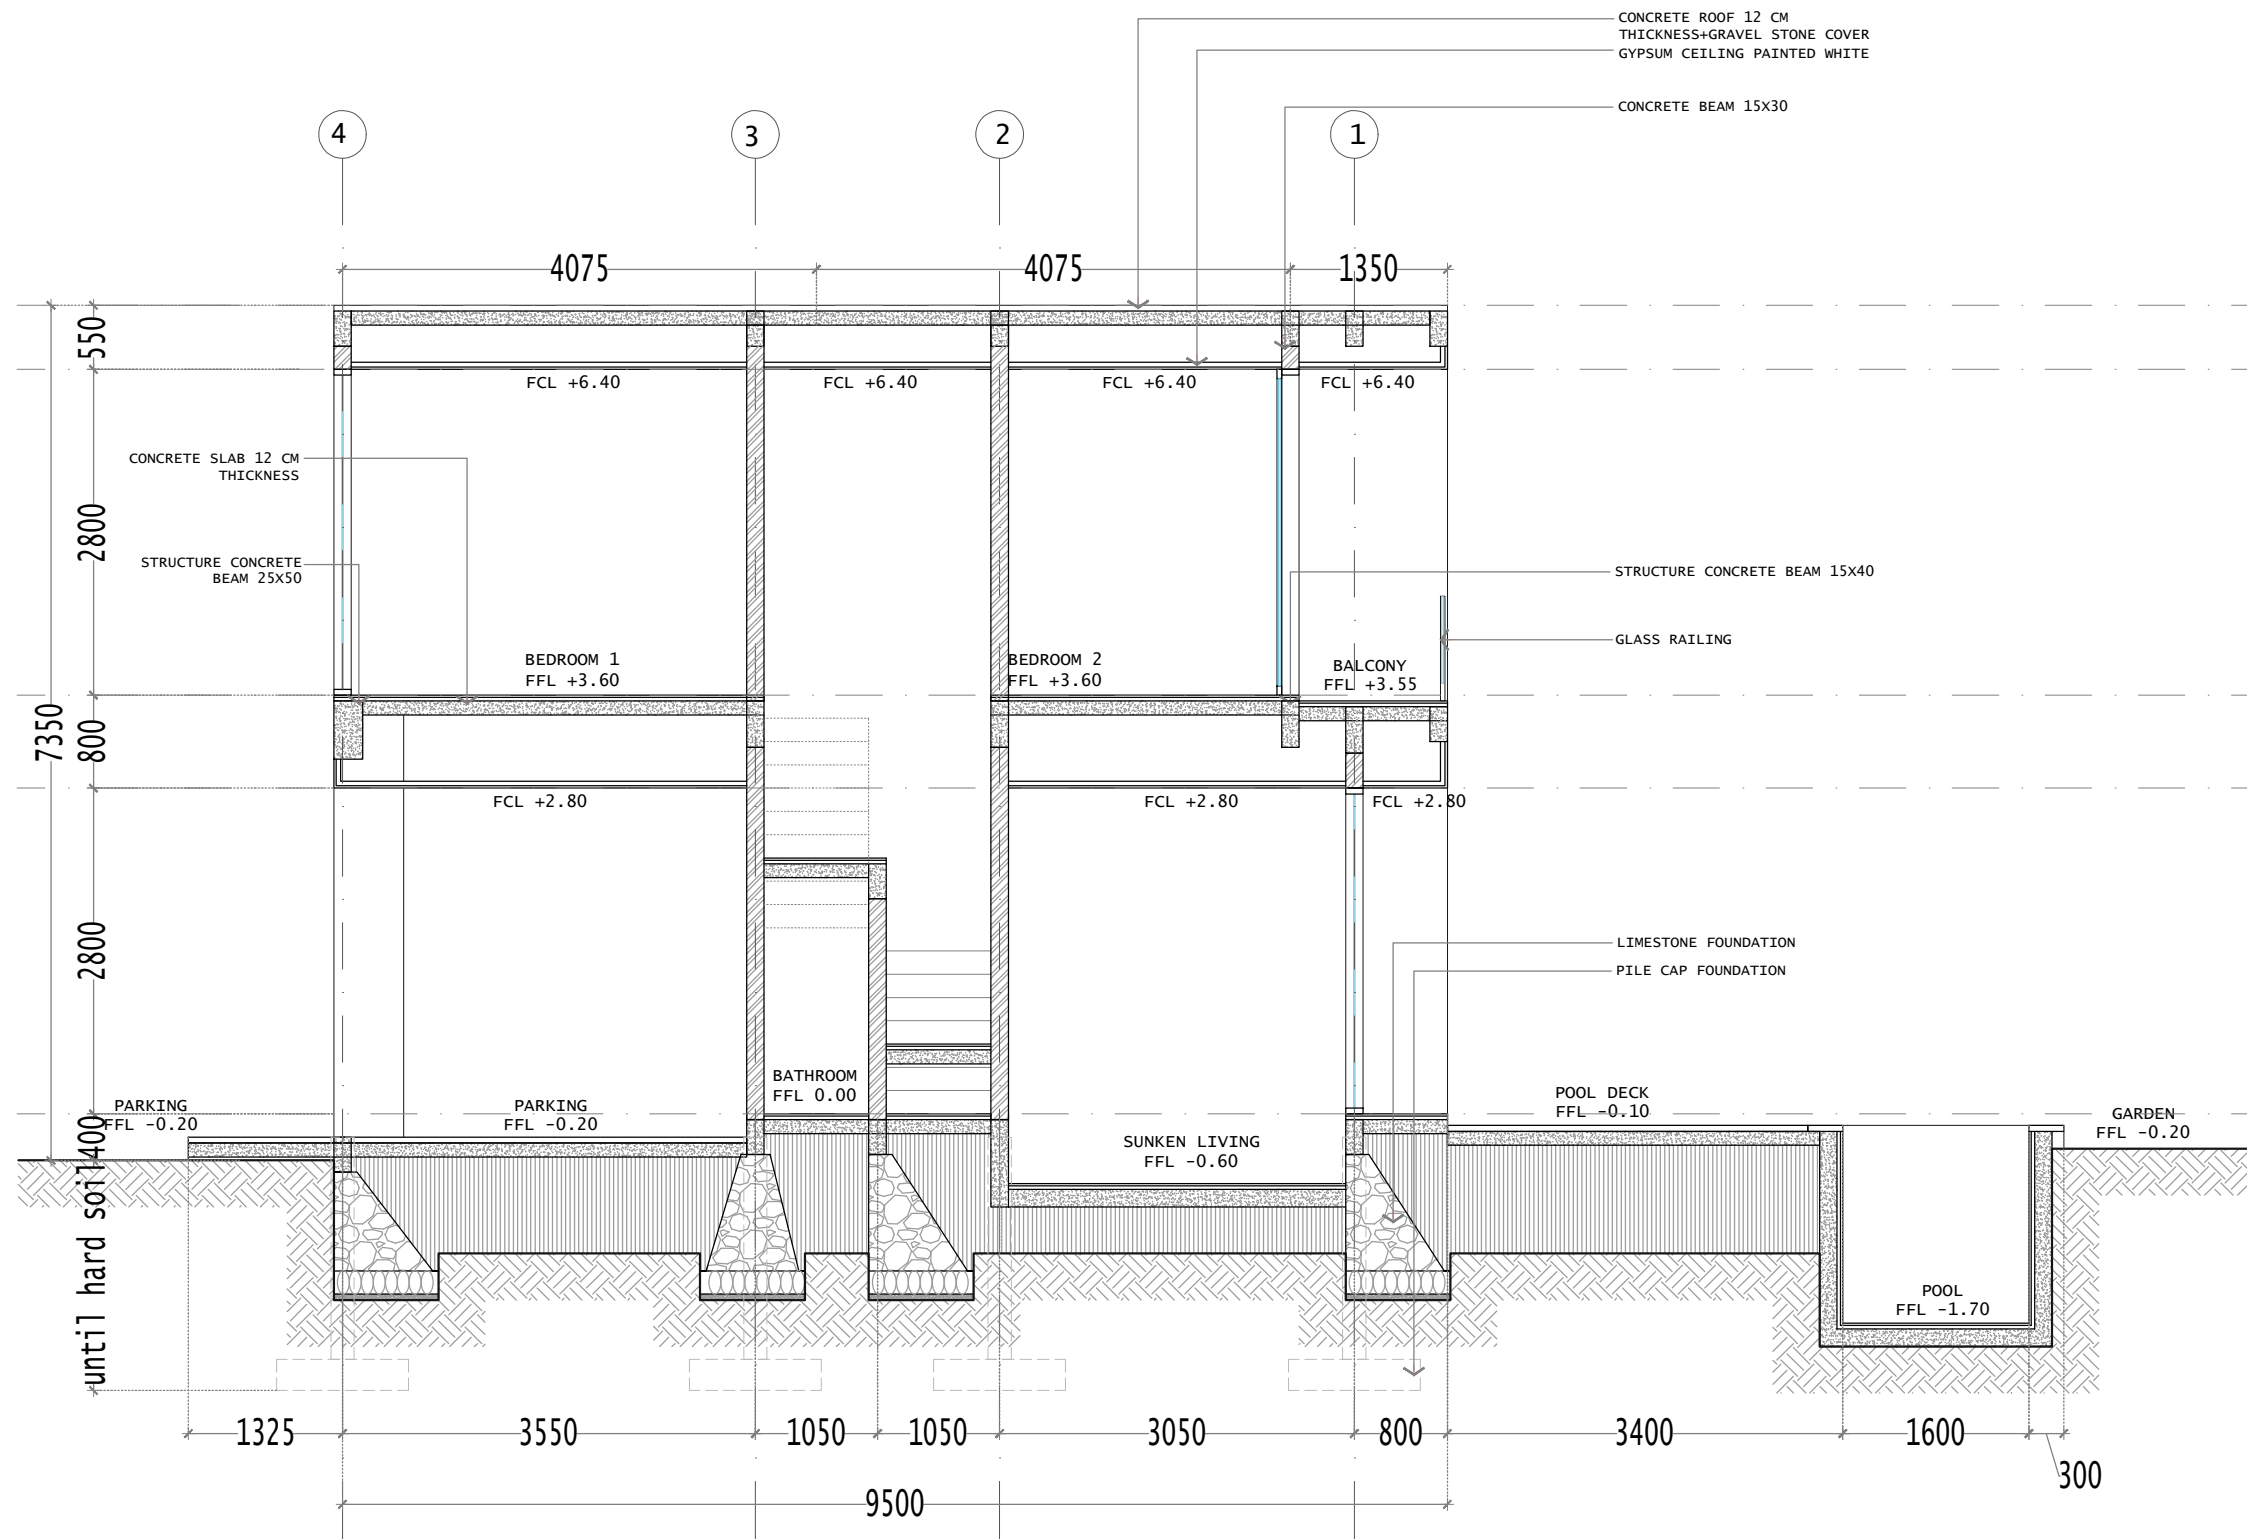


SECTION A-A  
SCALE 1 : 75

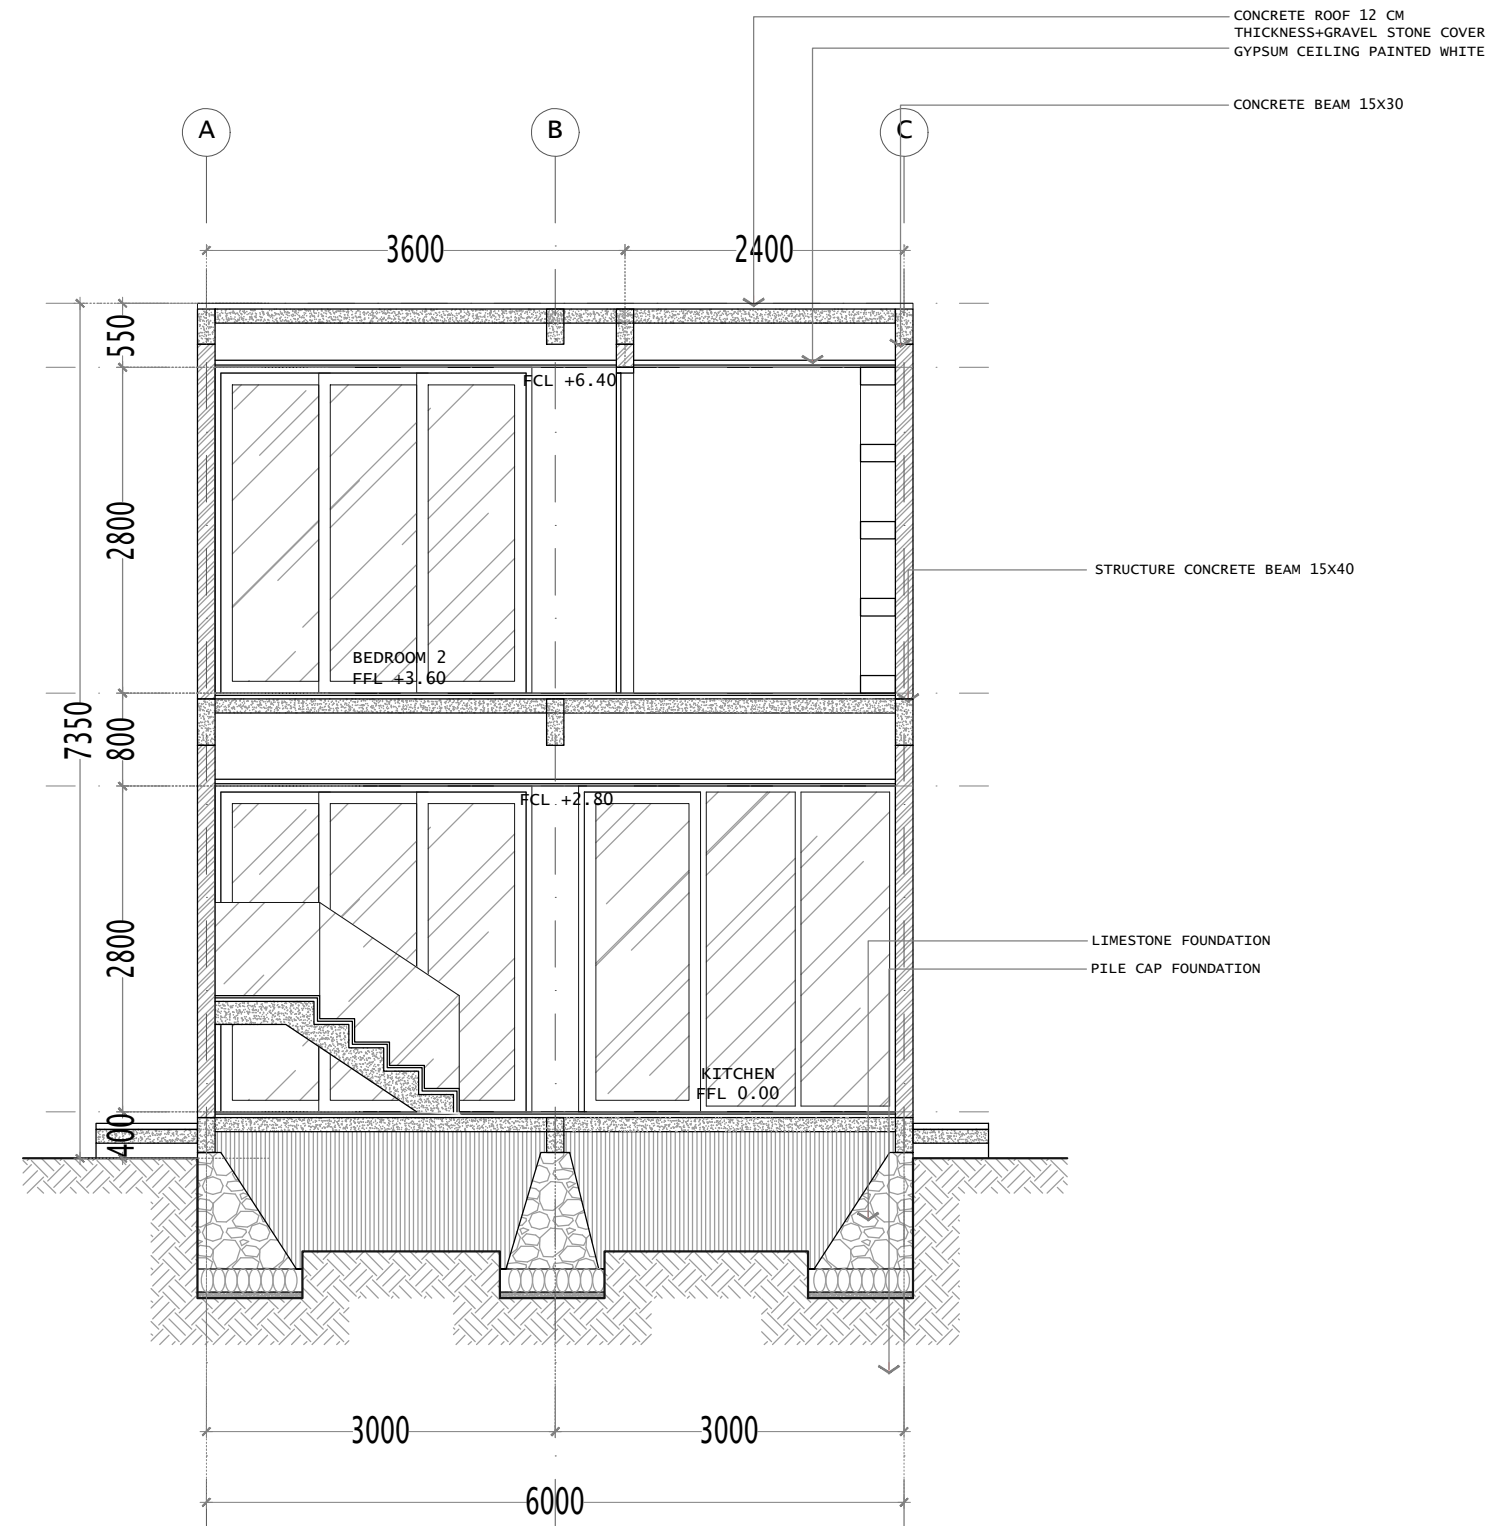


SECTION B-B  
SCALE 1:75

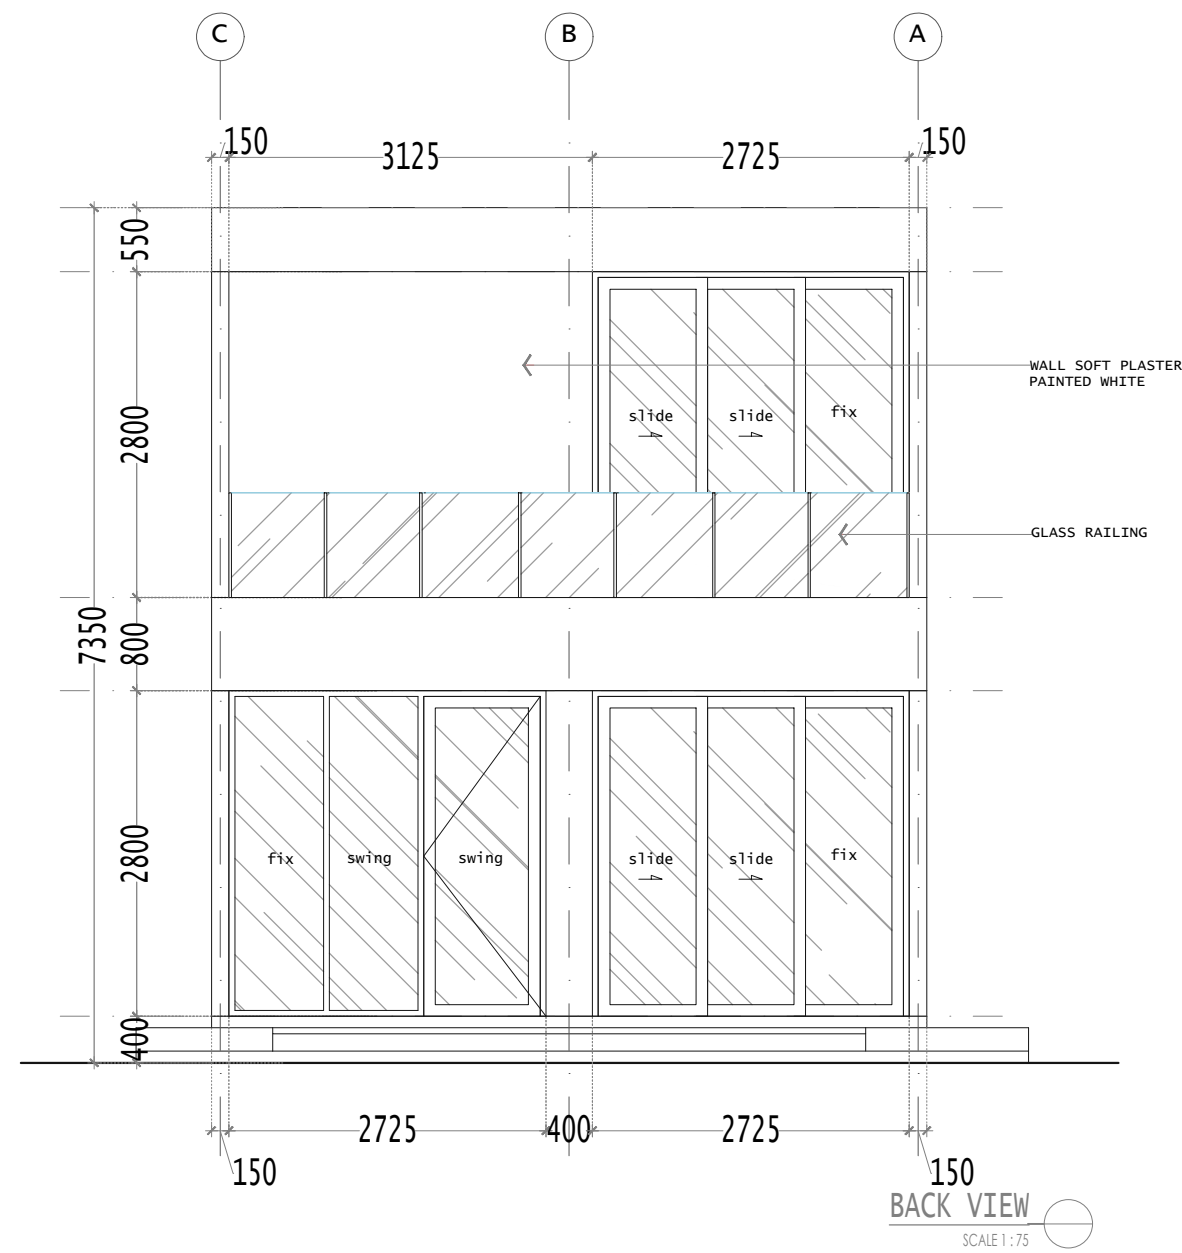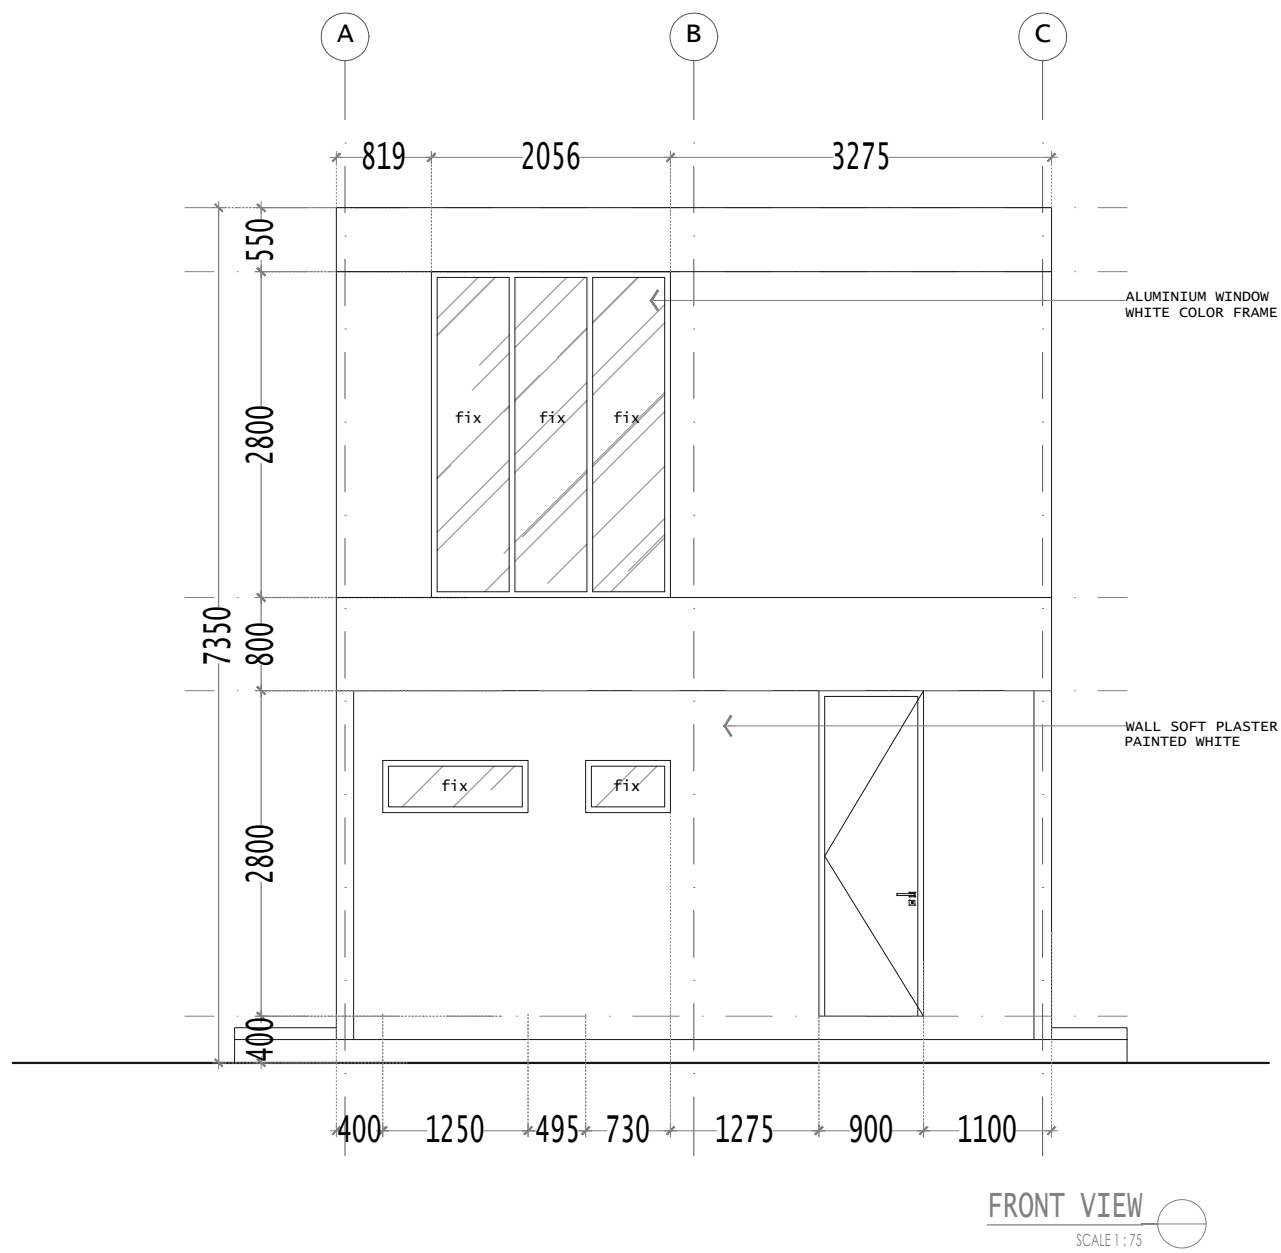

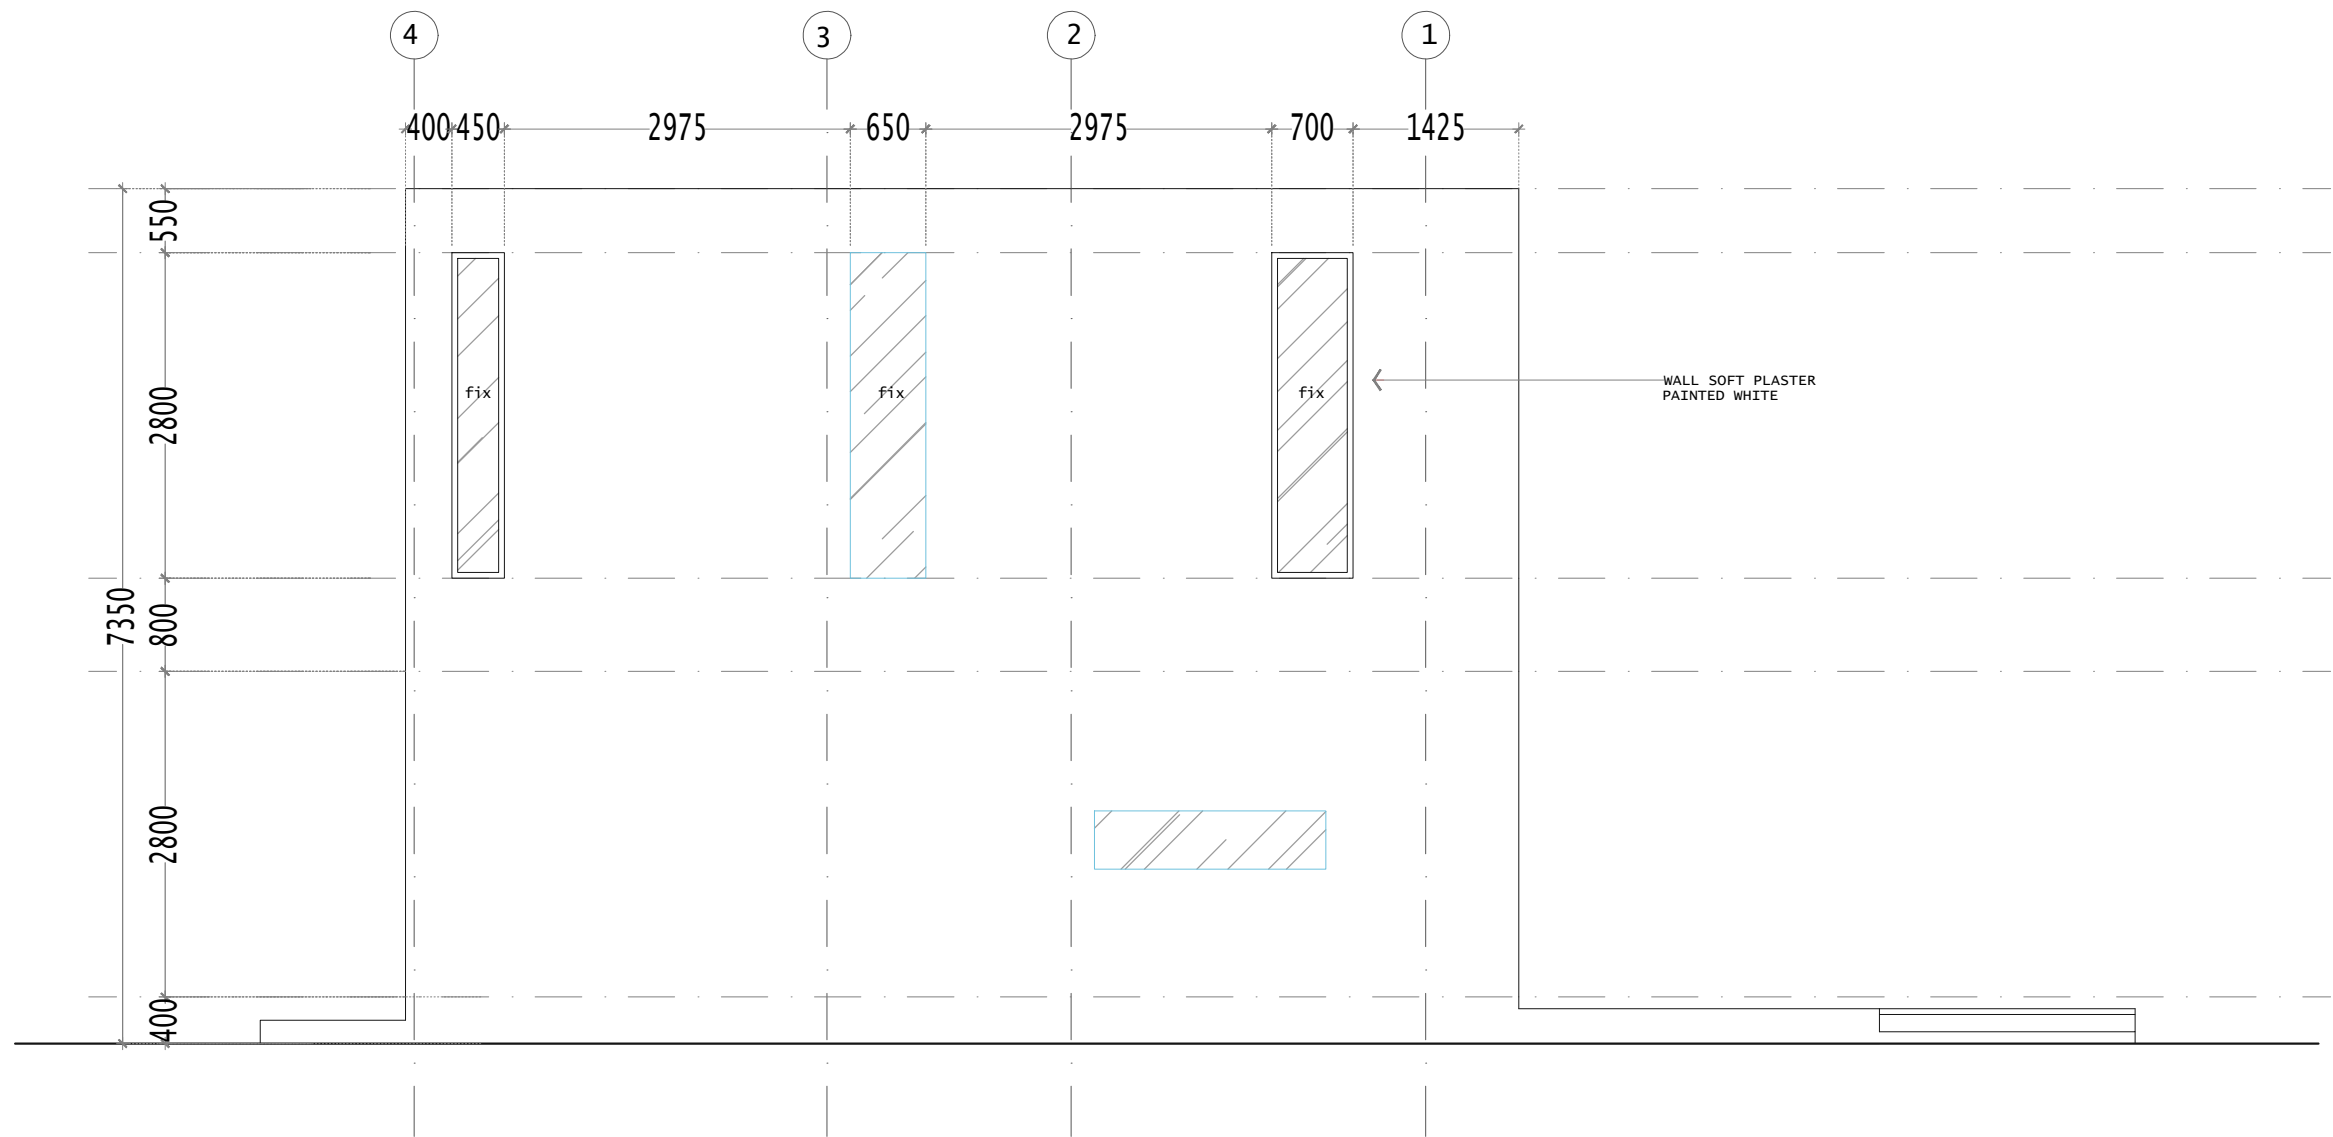


SIDE VIEW  
SCALE 1 : 75

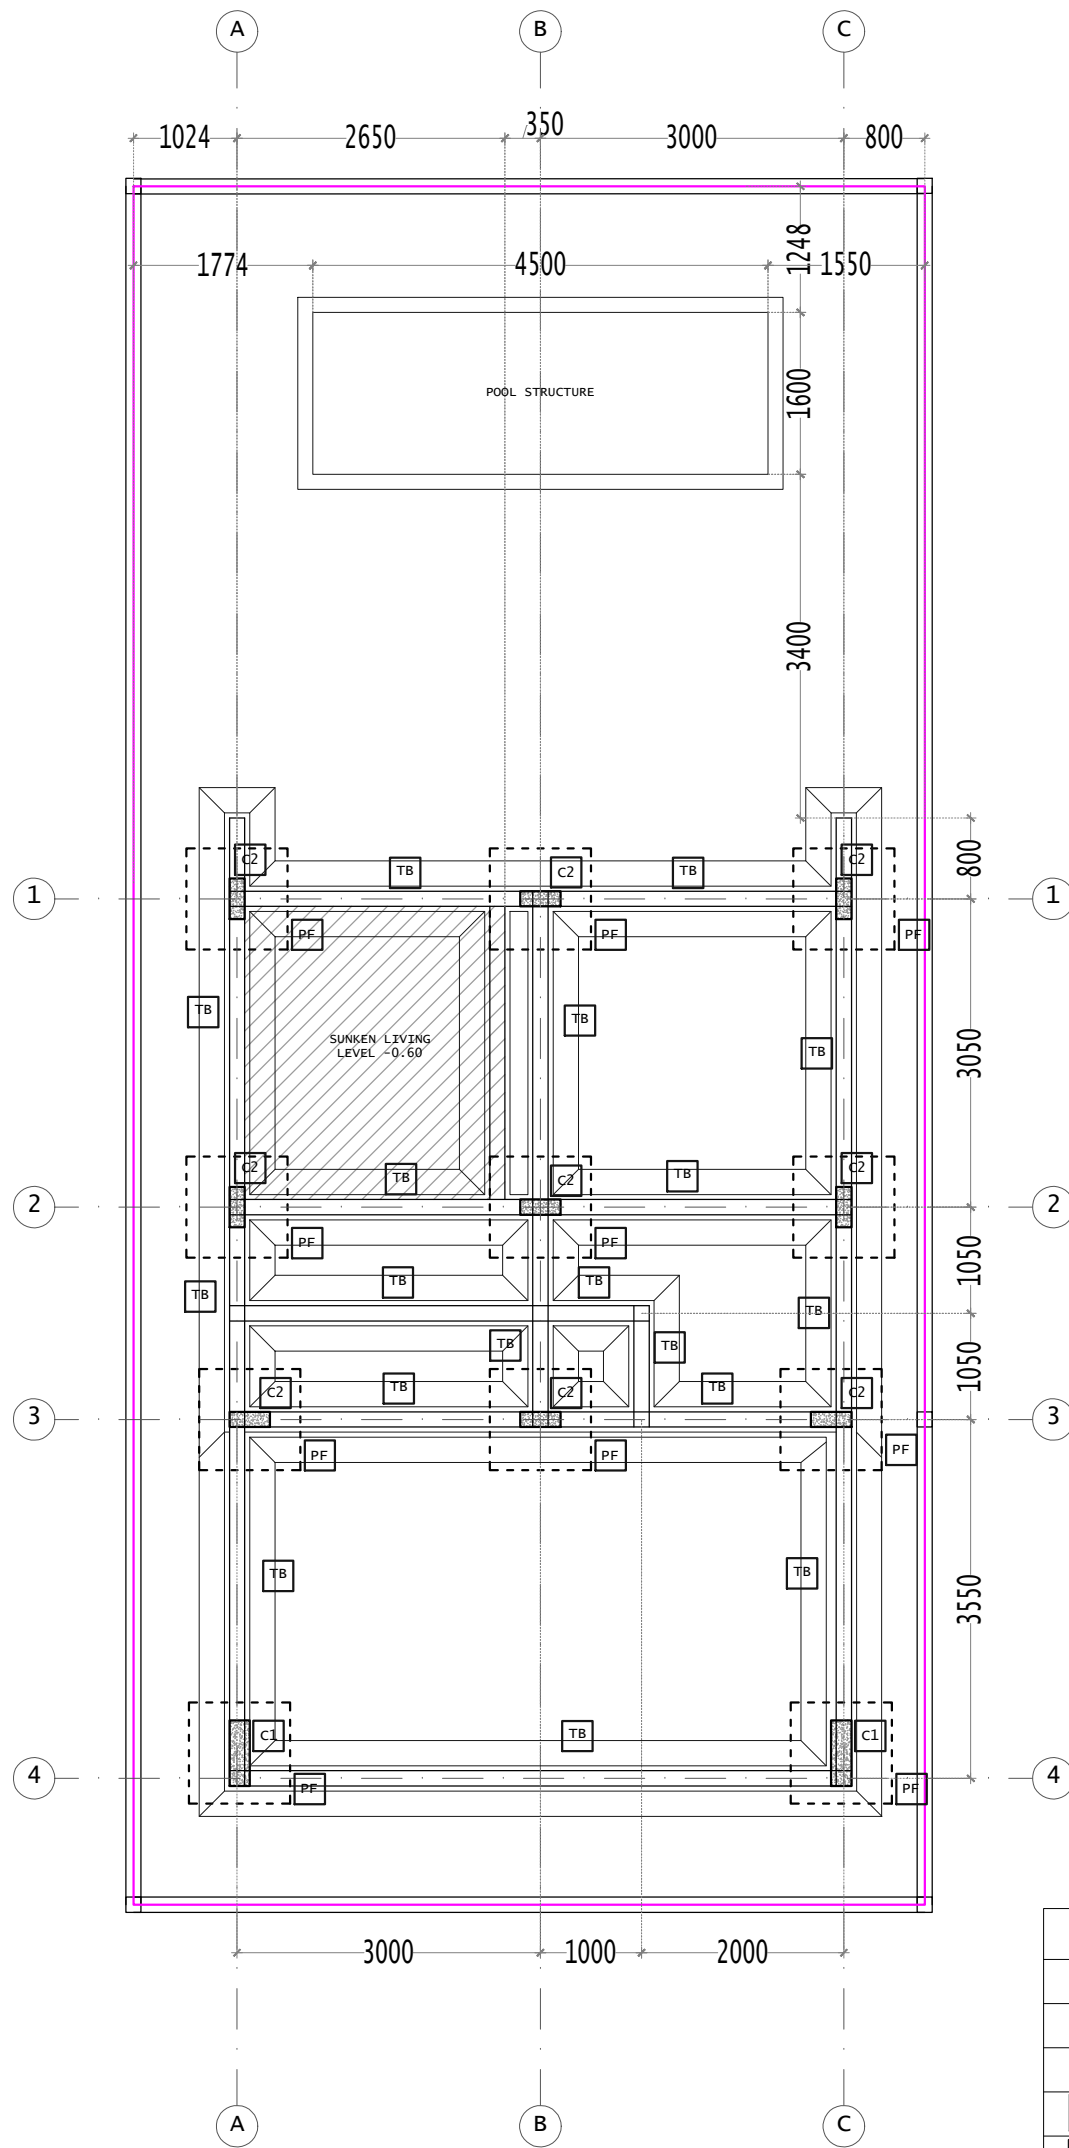


FOUNDATION PLAN  
SCALE 1 : 75

LEGEND	
PF	PILE CAP FOUNDATION
TB	TIE BEAM 15X30
C1	STRUCTURE COLUMN 1 25X65
C2	STRUCTURE COLUMN 2 15X40
B1	STRUCTURE BEAM 1 25X50
B2	STRUCTURE BEAM 2 15X40
B3	STRUCTURE BEAM 3 15X30
<span style="border: 1px solid pink; display: inline-block; width: 10px; height: 10px;"></span>	COLUMN FIRST FLOOR
<span style="border: 1px solid green; display: inline-block; width: 10px; height: 10px;"></span>	COLUMN SECOND FLOOR

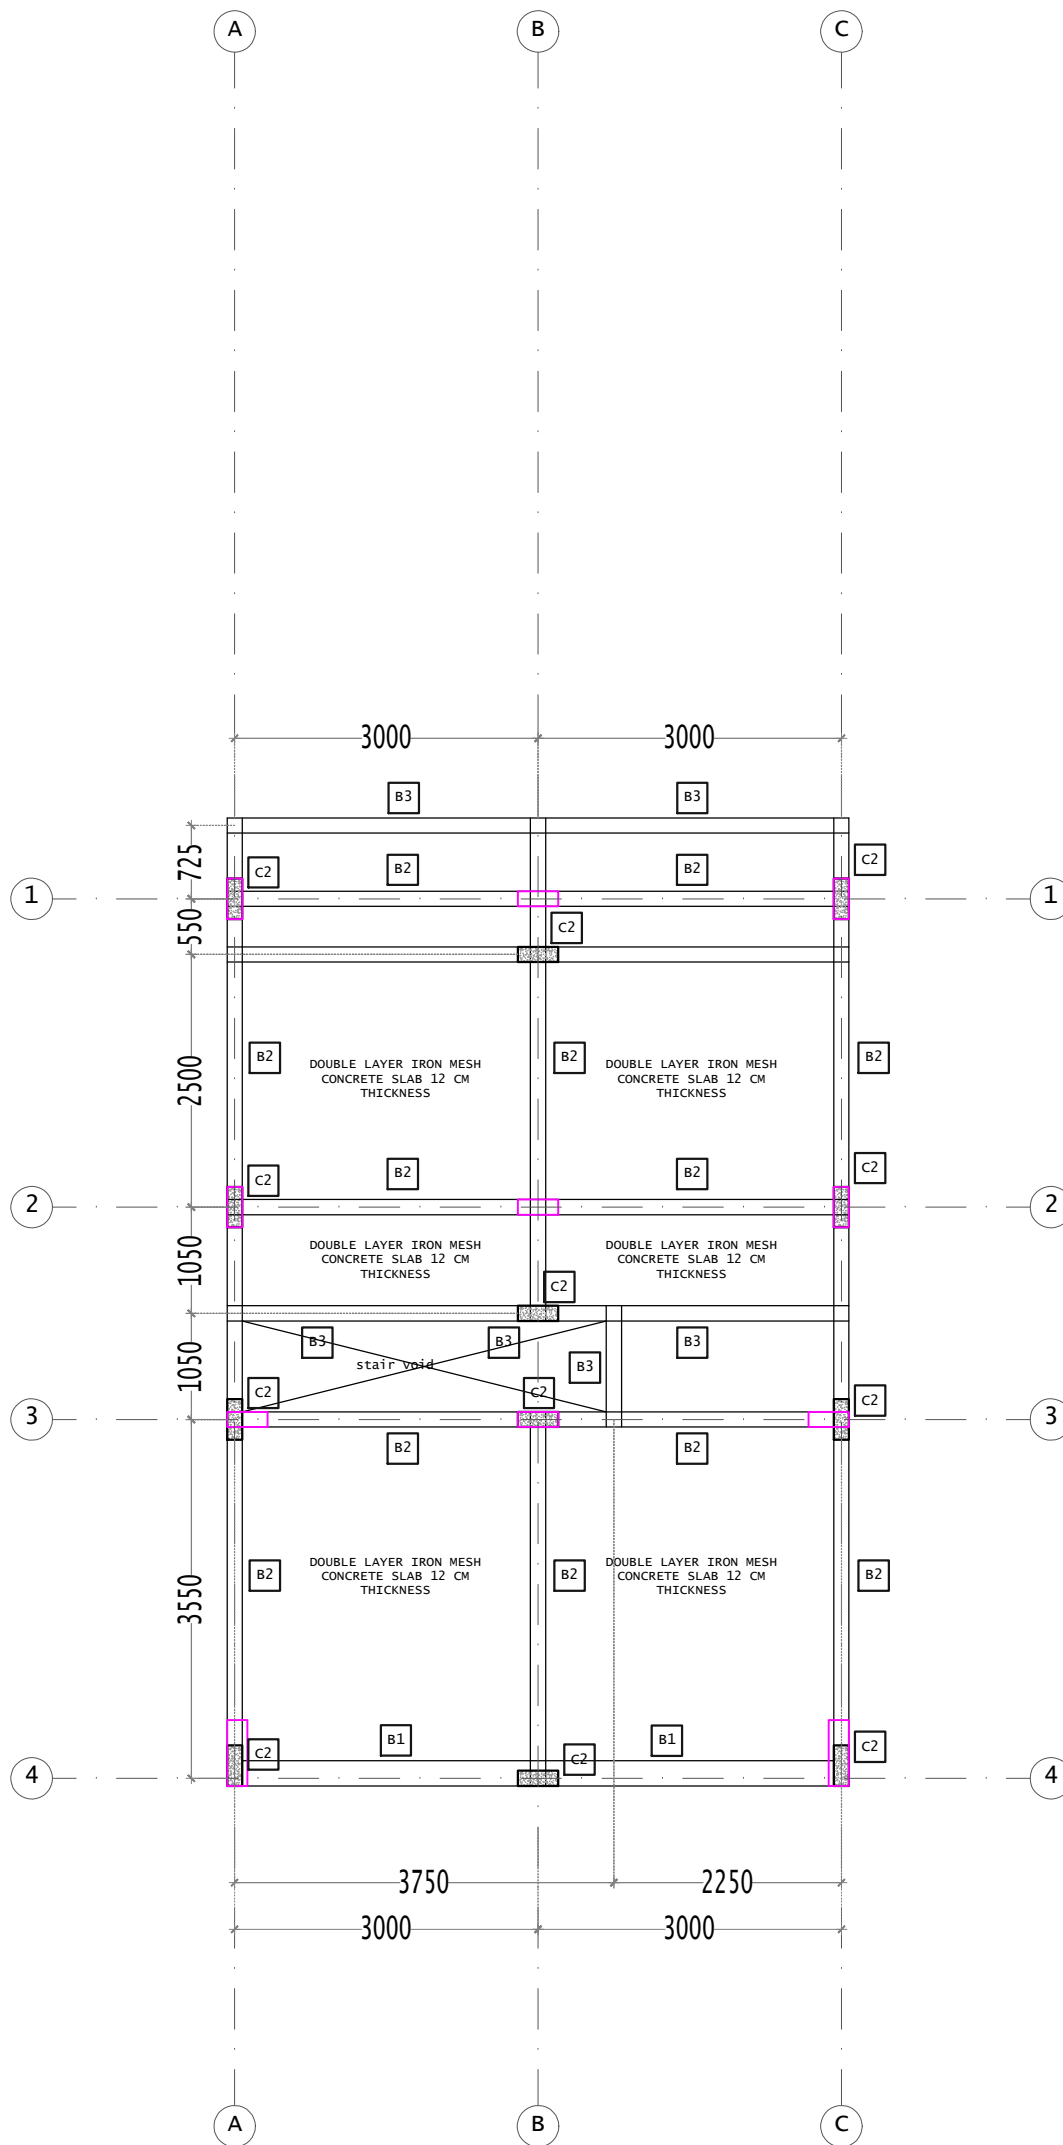





SECOND FLOOR BEAM PLAN  
SCALE 1:75




LEGEND	
PF	PILE CAP FOUNDATION
TB	TIE BEAM 15X30
C1	STRUCTURE COLUMN 1 25X65
C2	STRUCTURE COLUMN 2 15X40
B1	STRUCTURE BEAM 1 25X50
B2	STRUCTURE BEAM 2 15X40
B3	STRUCTURE BEAM 3 15X30
<span style="border: 1px solid pink; display: inline-block; width: 10px; height: 10px;"></span>	COLUMN FIRST FLOOR
<span style="border: 1px solid green; display: inline-block; width: 10px; height: 10px;"></span>	COLUMN SECOND FLOOR

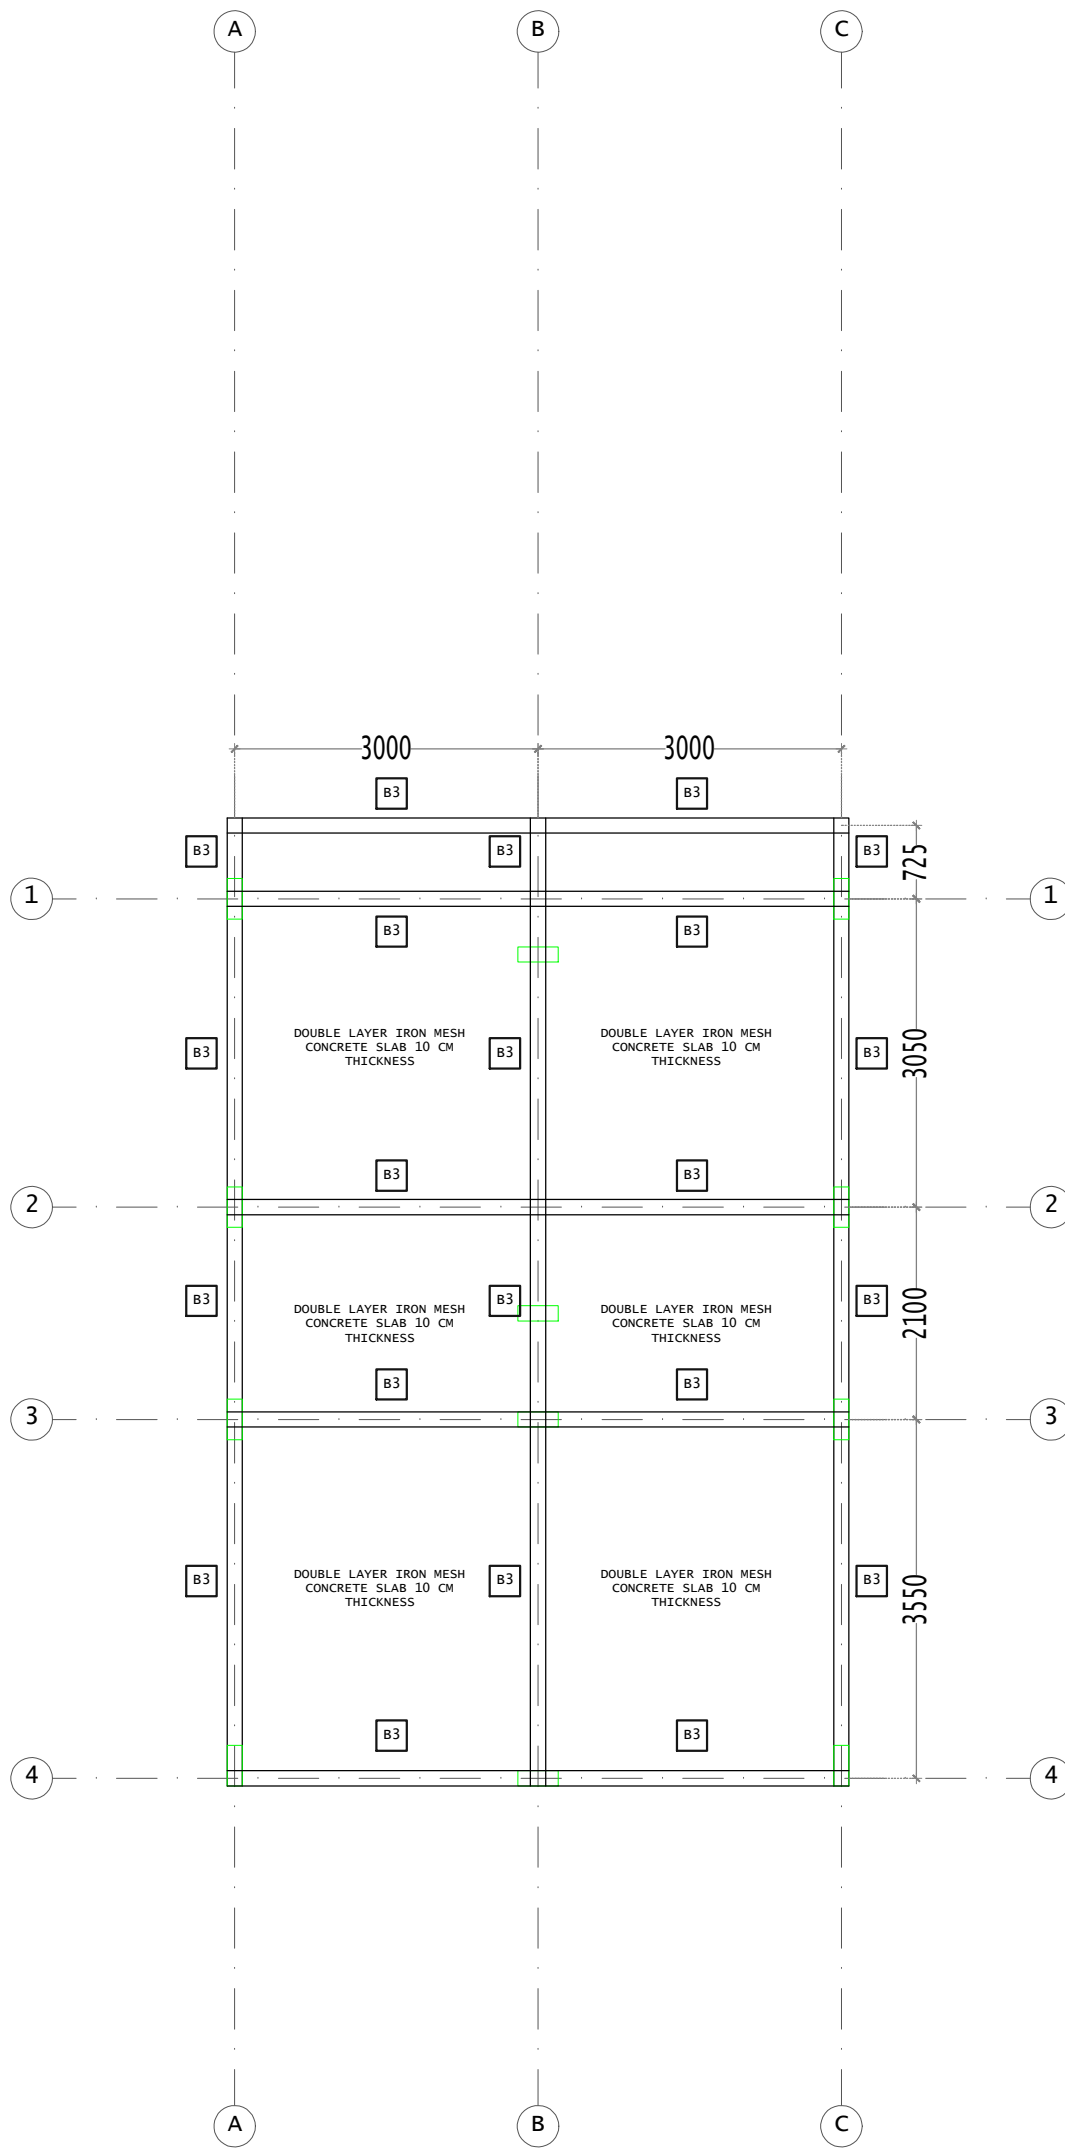

ROOF BEAM PLAN  
SCALE 1:75

LEGEND	
PF	PILE CAP FOUNDATION
TB	TIE BEAM 15X30
C1	STRUCTURE COLUMN 1 25X65
C2	STRUCTURE COLUMN 2 15X40
B1	STRUCTURE BEAM 1 25X50
B2	STRUCTURE BEAM 2 15X40
B3	STRUCTURE BEAM 3 15X30
<span style="border: 1px solid magenta; display: inline-block; width: 10px; height: 10px;"></span>	COLUMN FIRST FLOOR
<span style="border: 1px solid green; display: inline-block; width: 10px; height: 10px;"></span>	COLUMN SECOND FLOOR

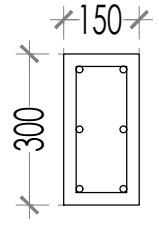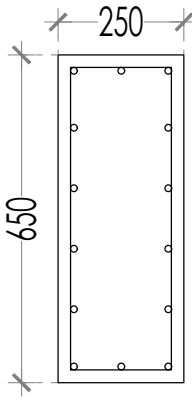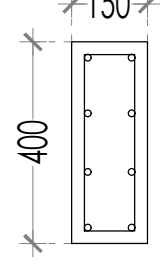
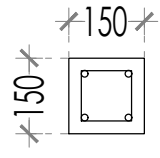
STRUCTURE TYPE	TB	C1	C2	
	TIE BEAM	COLUMN 1	COLUMN 2	PRACTICAL COLUMN
DESCRIPTION				
IRON SIZE	6 D13	14 D13	8 D13	4 D10
DISTANCE	Ø8-150	Ø8-150	Ø8-150	Ø6-150

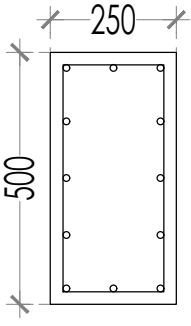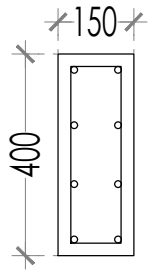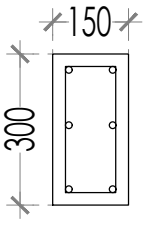STRUCTURE TYPE	B1	B2	B3
	BEAM 1	BEAM 2	BEAM 3
DESCRIPTION			
IRON SIZE	12 D13	8 D13	8 D13
DISTANCE	Ø8-150	Ø8-150	Ø8-150

COLUMN & BEAM DETAIL STRUCTURE

SCALE 1:15



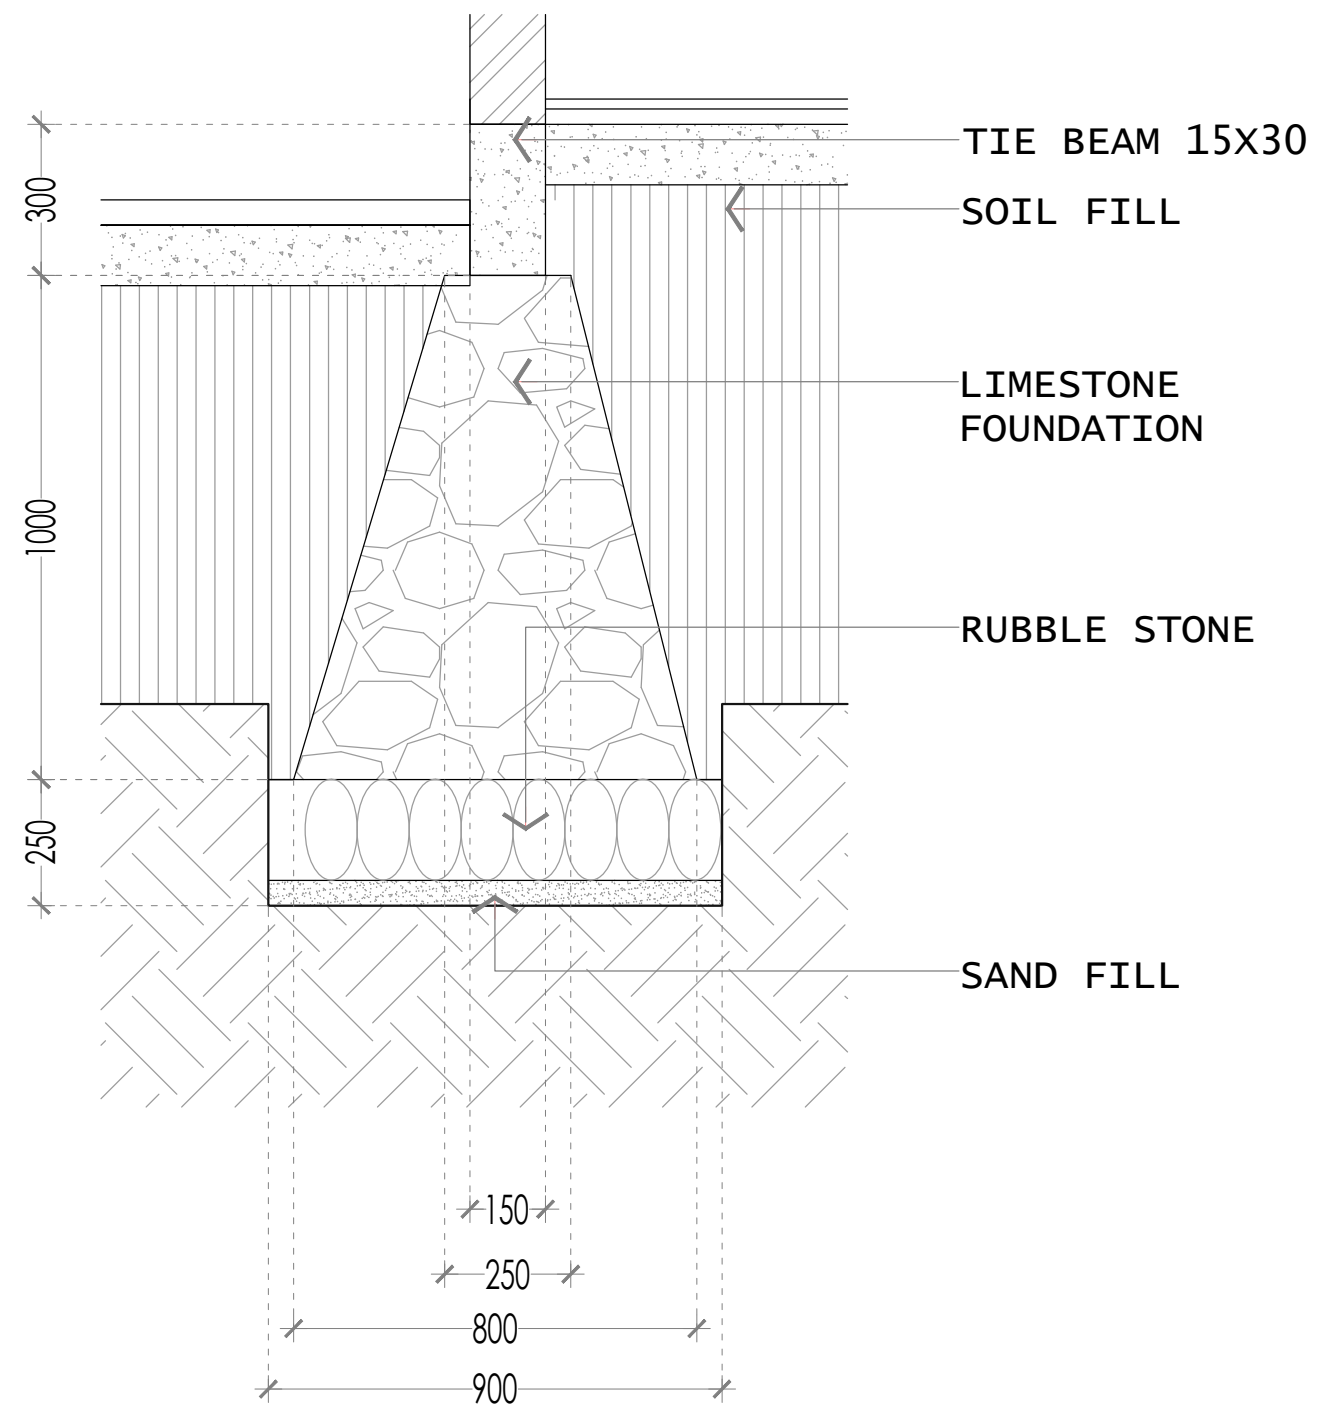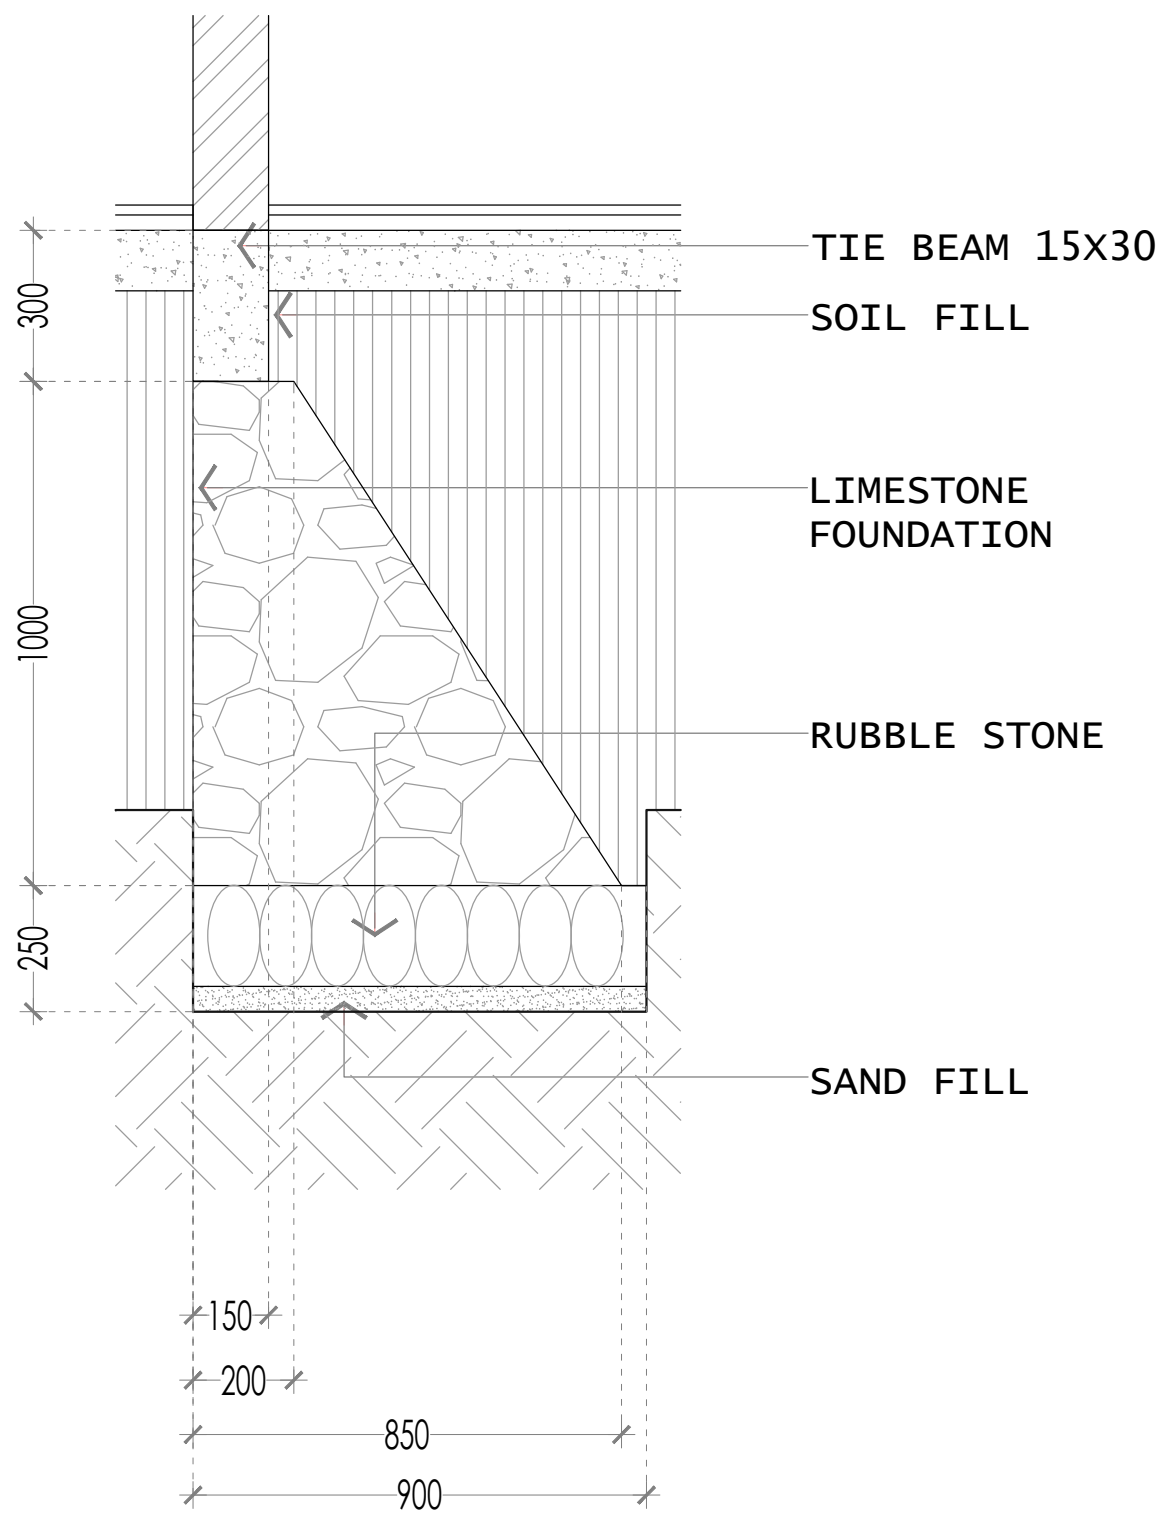

RIVERSTONE DETAIL FOUNDATION

SCALE 1:15



UNGASAN VILLA  
MAY 2024

Pemilik :

Lokasi :



Nama Gambar :

Skala :

Revisi :

Arsitek :


Paraf :

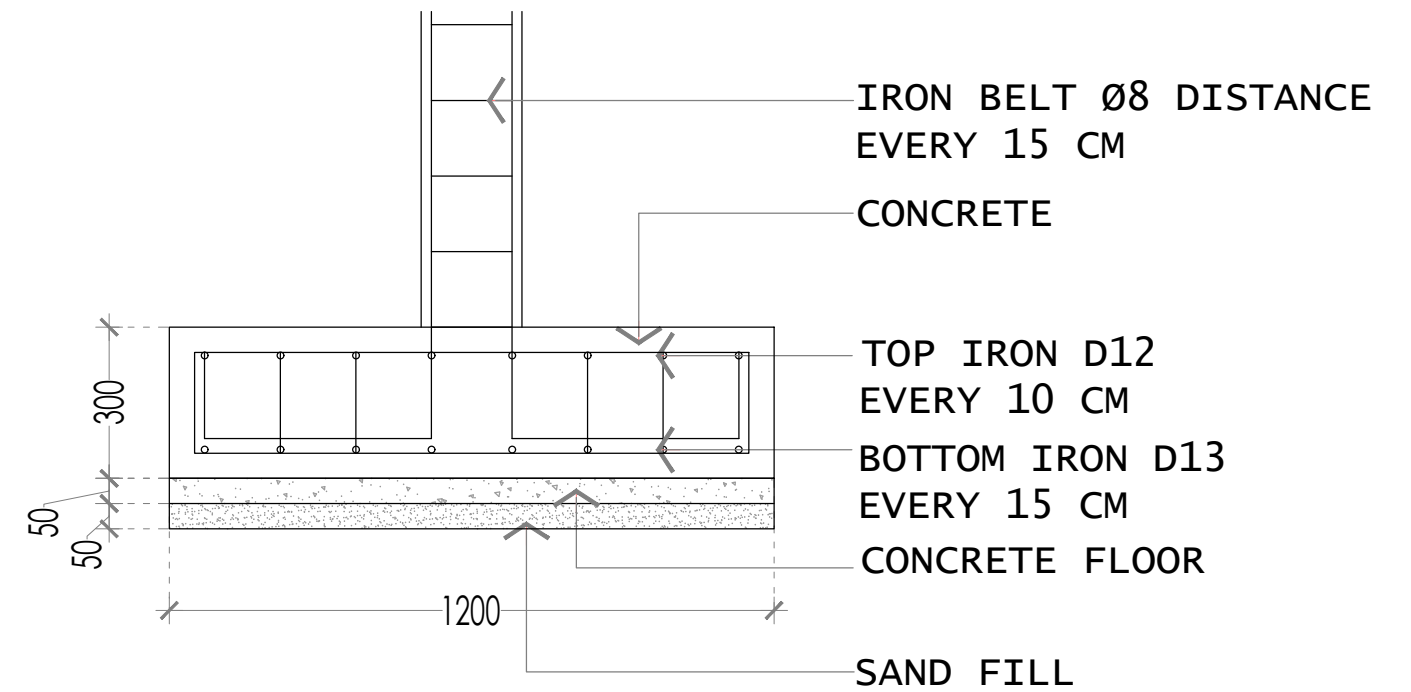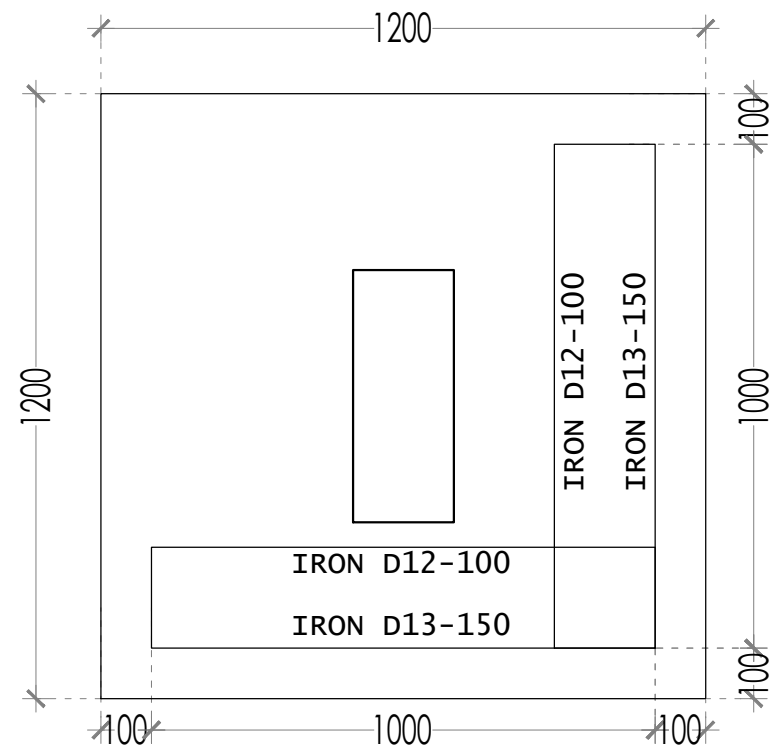

PILE CAP FOUNDATION DETAIL

SCALE 1:15



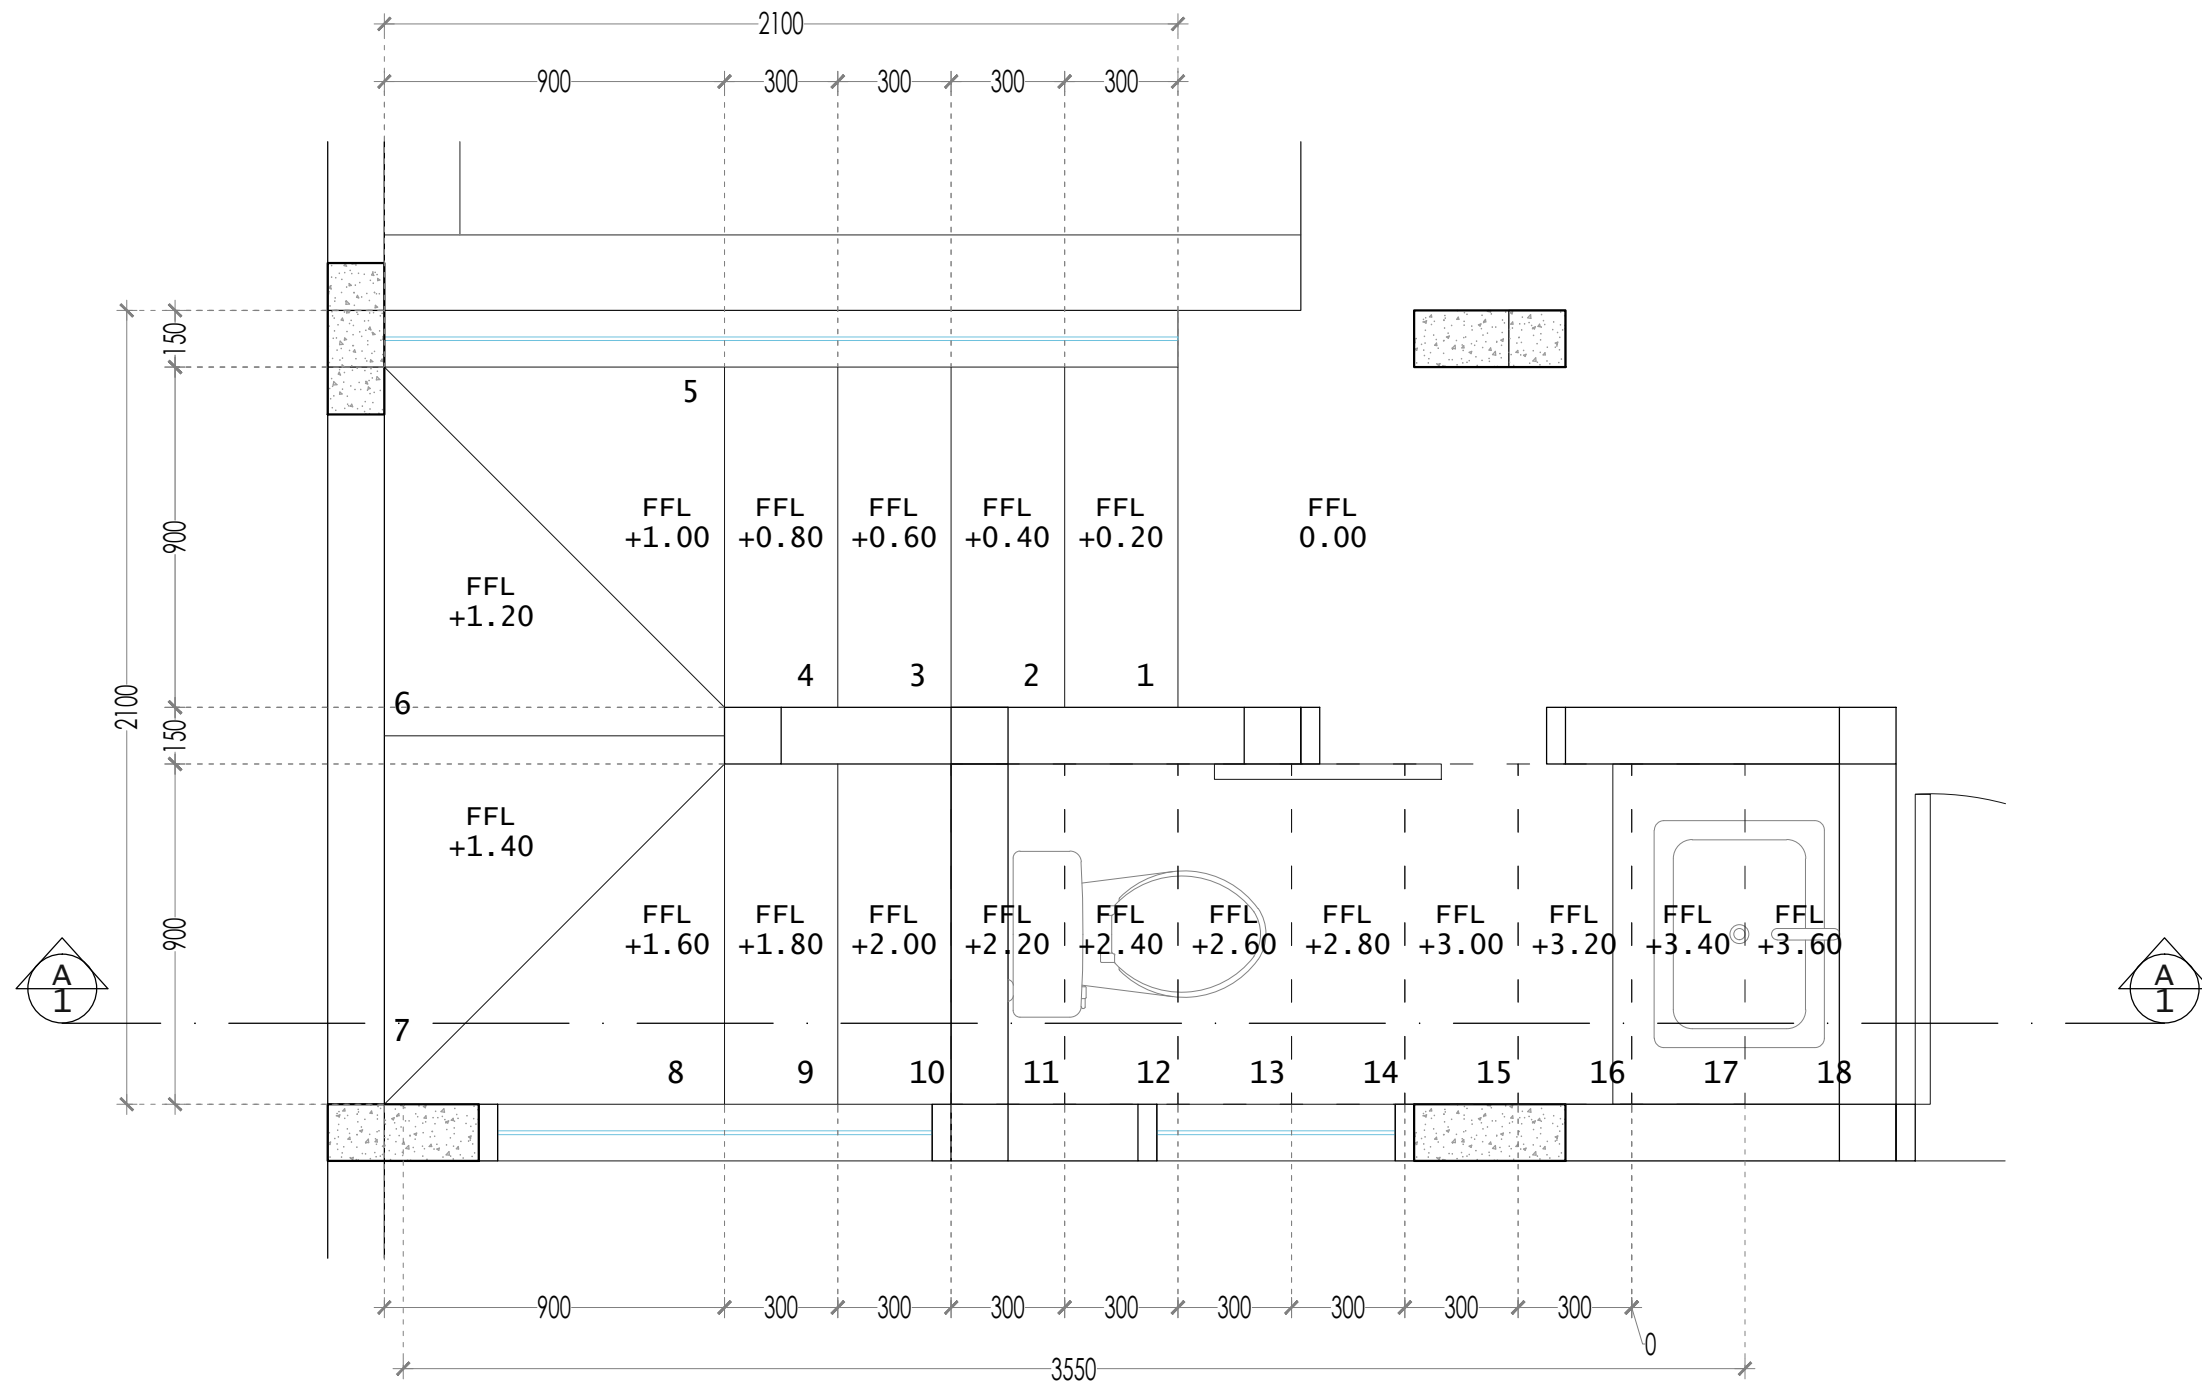

# STAIRCASE PLAN

SCALE 1:20



UNGASAN VILLA  
MAY 2024

Pemilik :

Lokasi :

Nama Gambar :


Skala :

Revisi :

Arsitek :

Paraf :



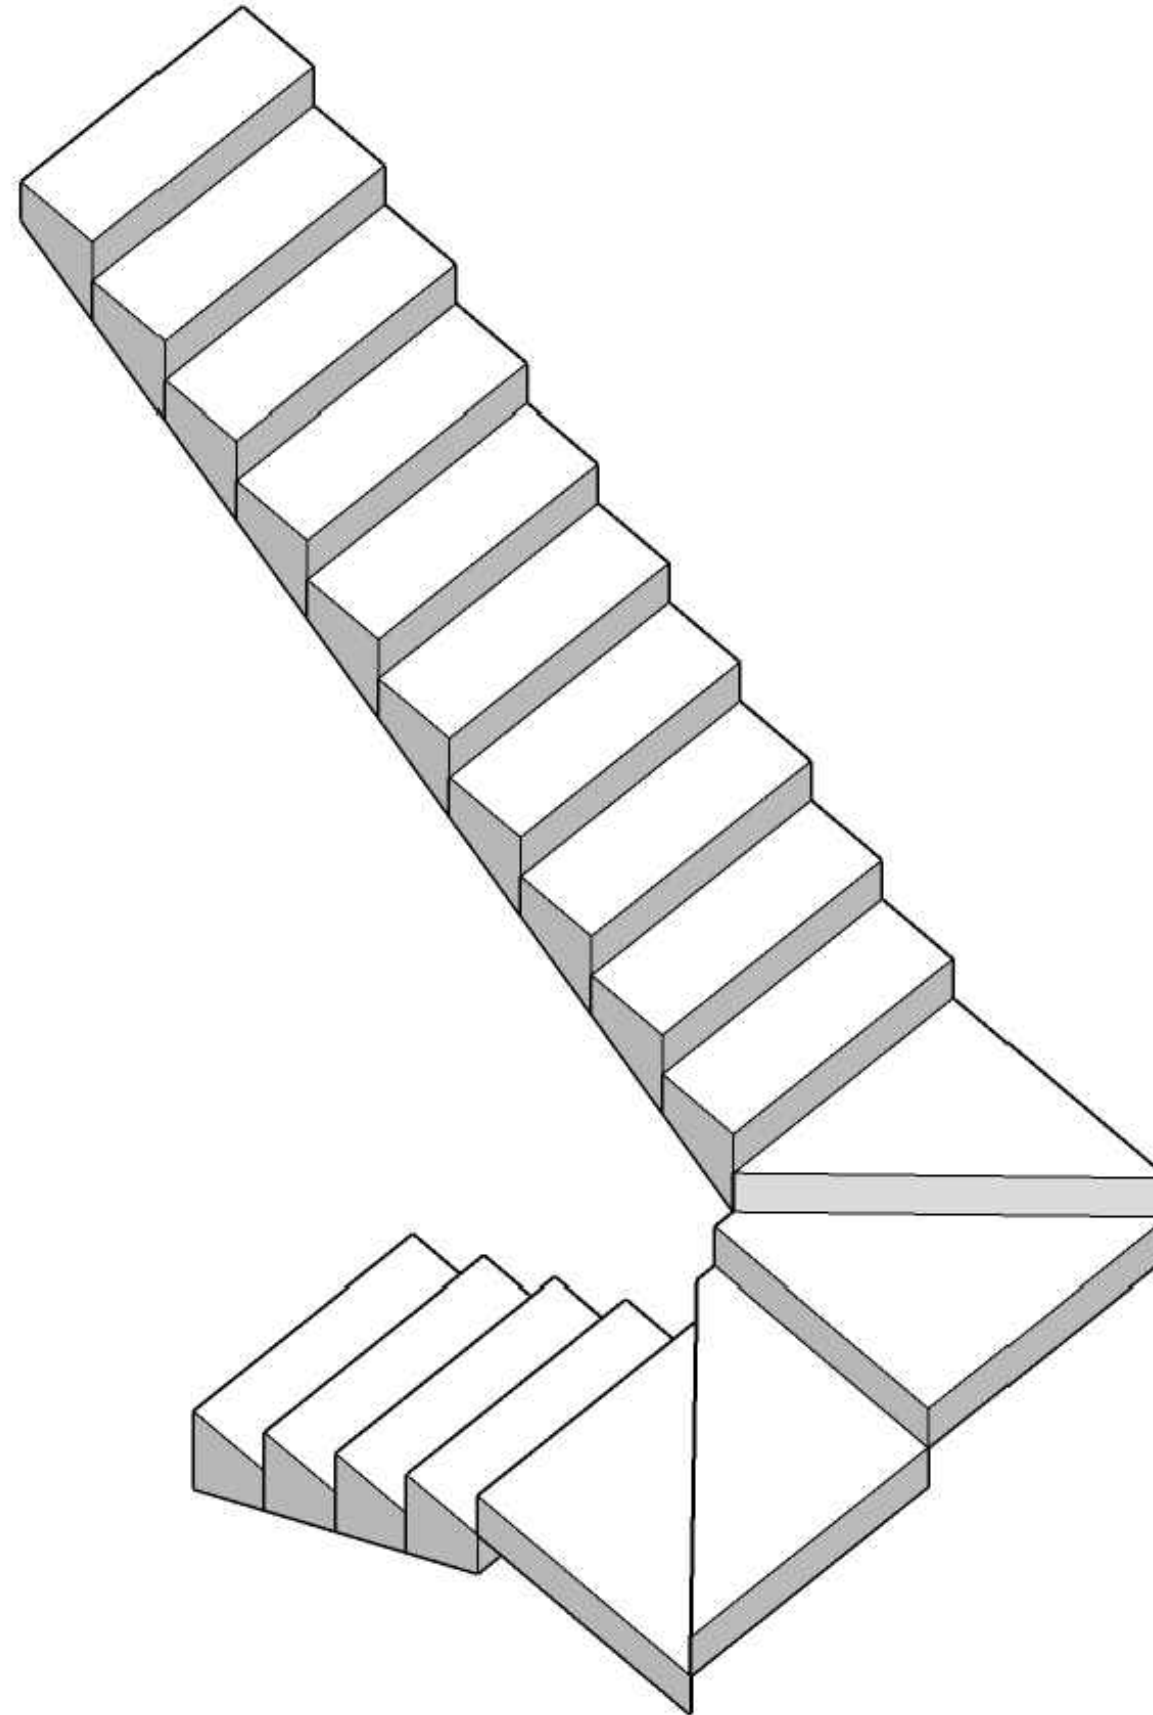

3D PERSPECTIVE  
SCALE NTS 

UNGASAN VILLA  
MAY 2024

Pemilik :

Lokasi :


Nama Gambar :

Skala :


Revisi :

Arsitek :

Paraf :

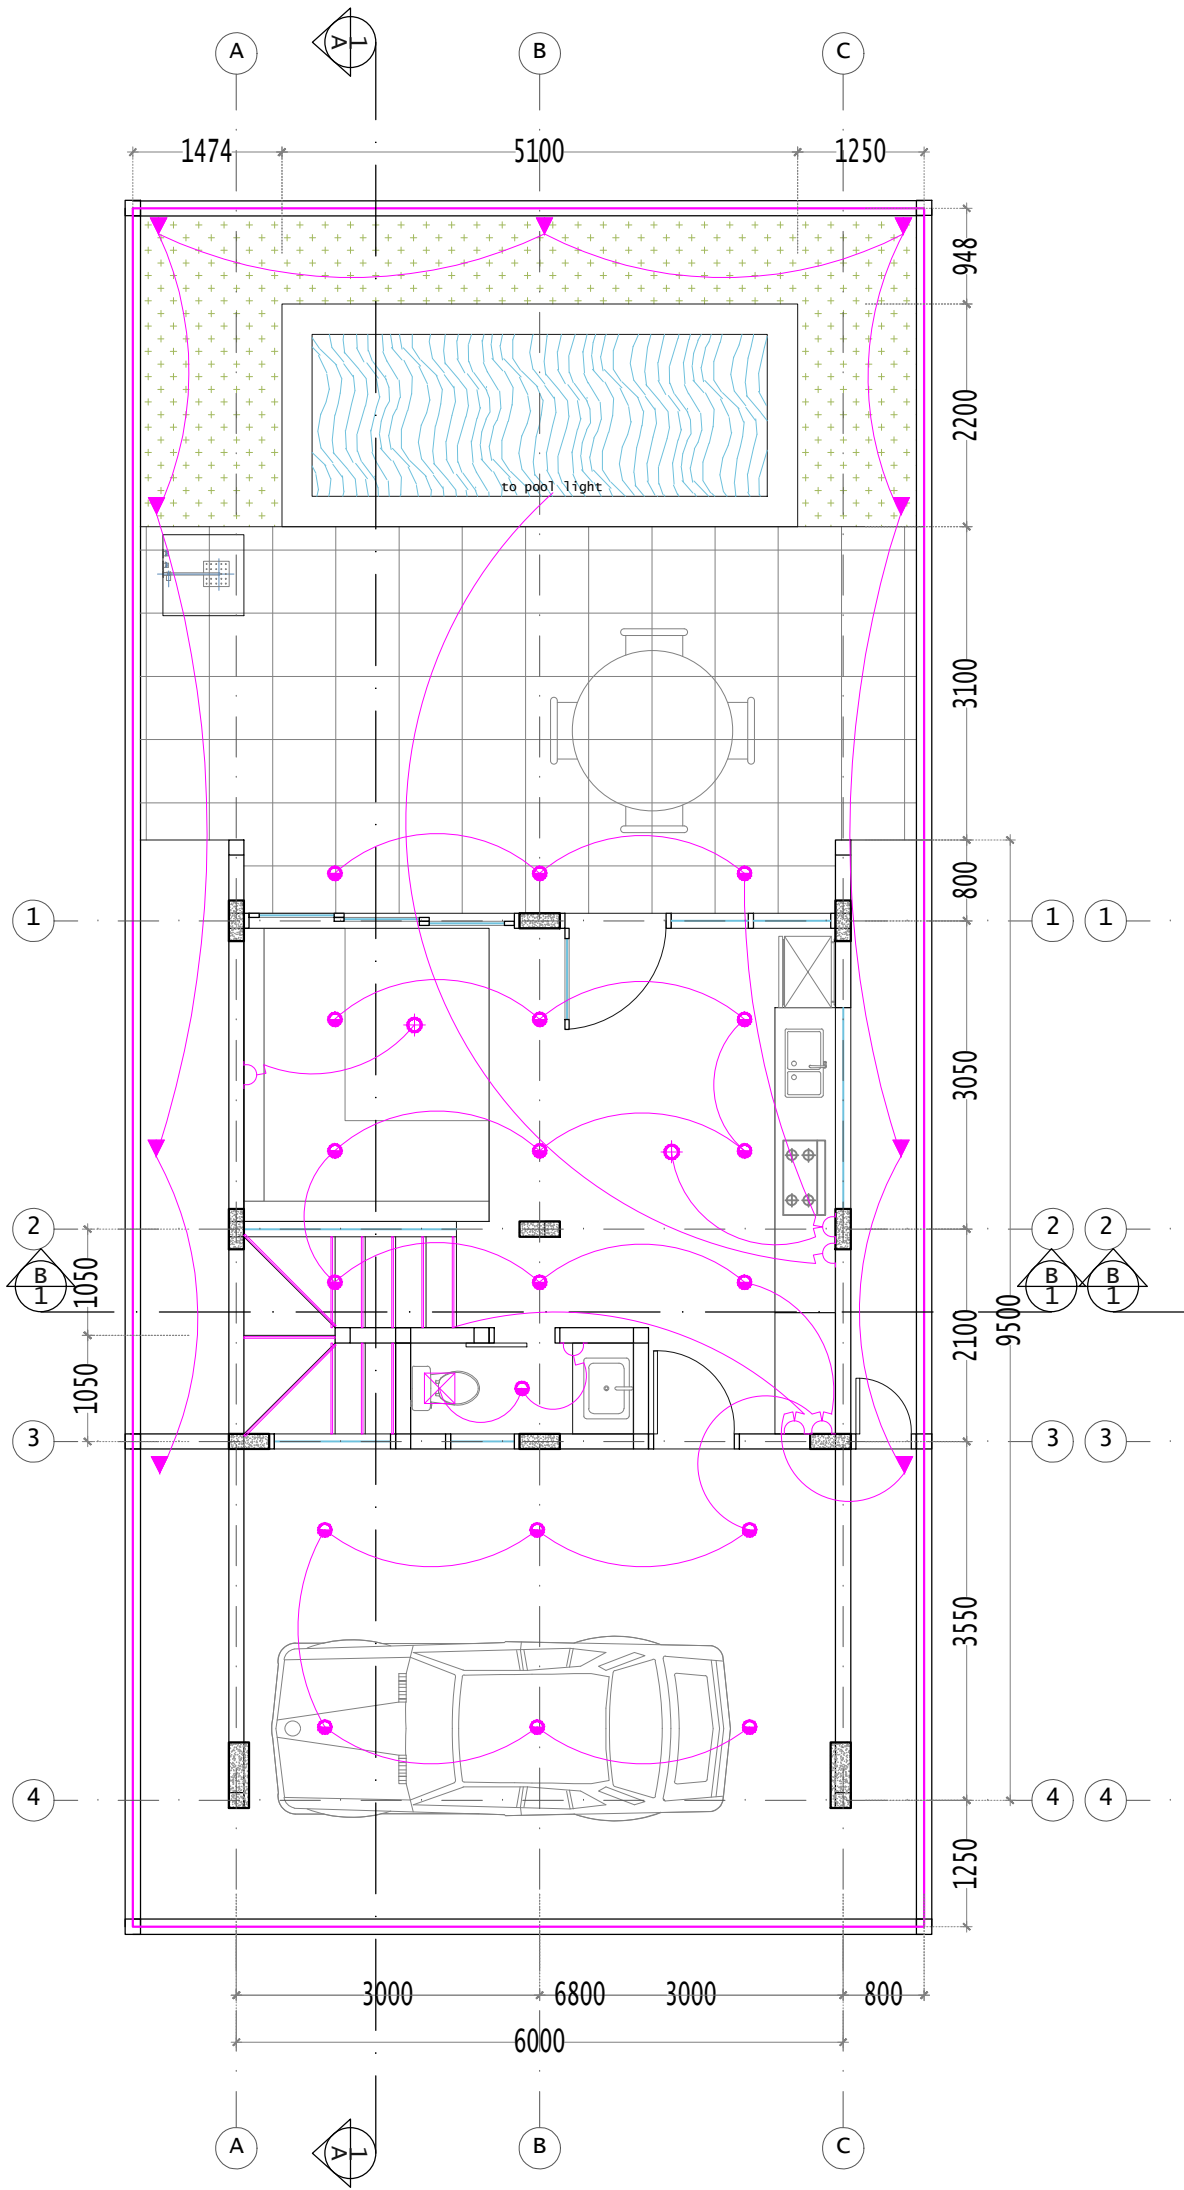


GROUND FLOOR  
LIGHTING PLAN | SCALE 1 : 75

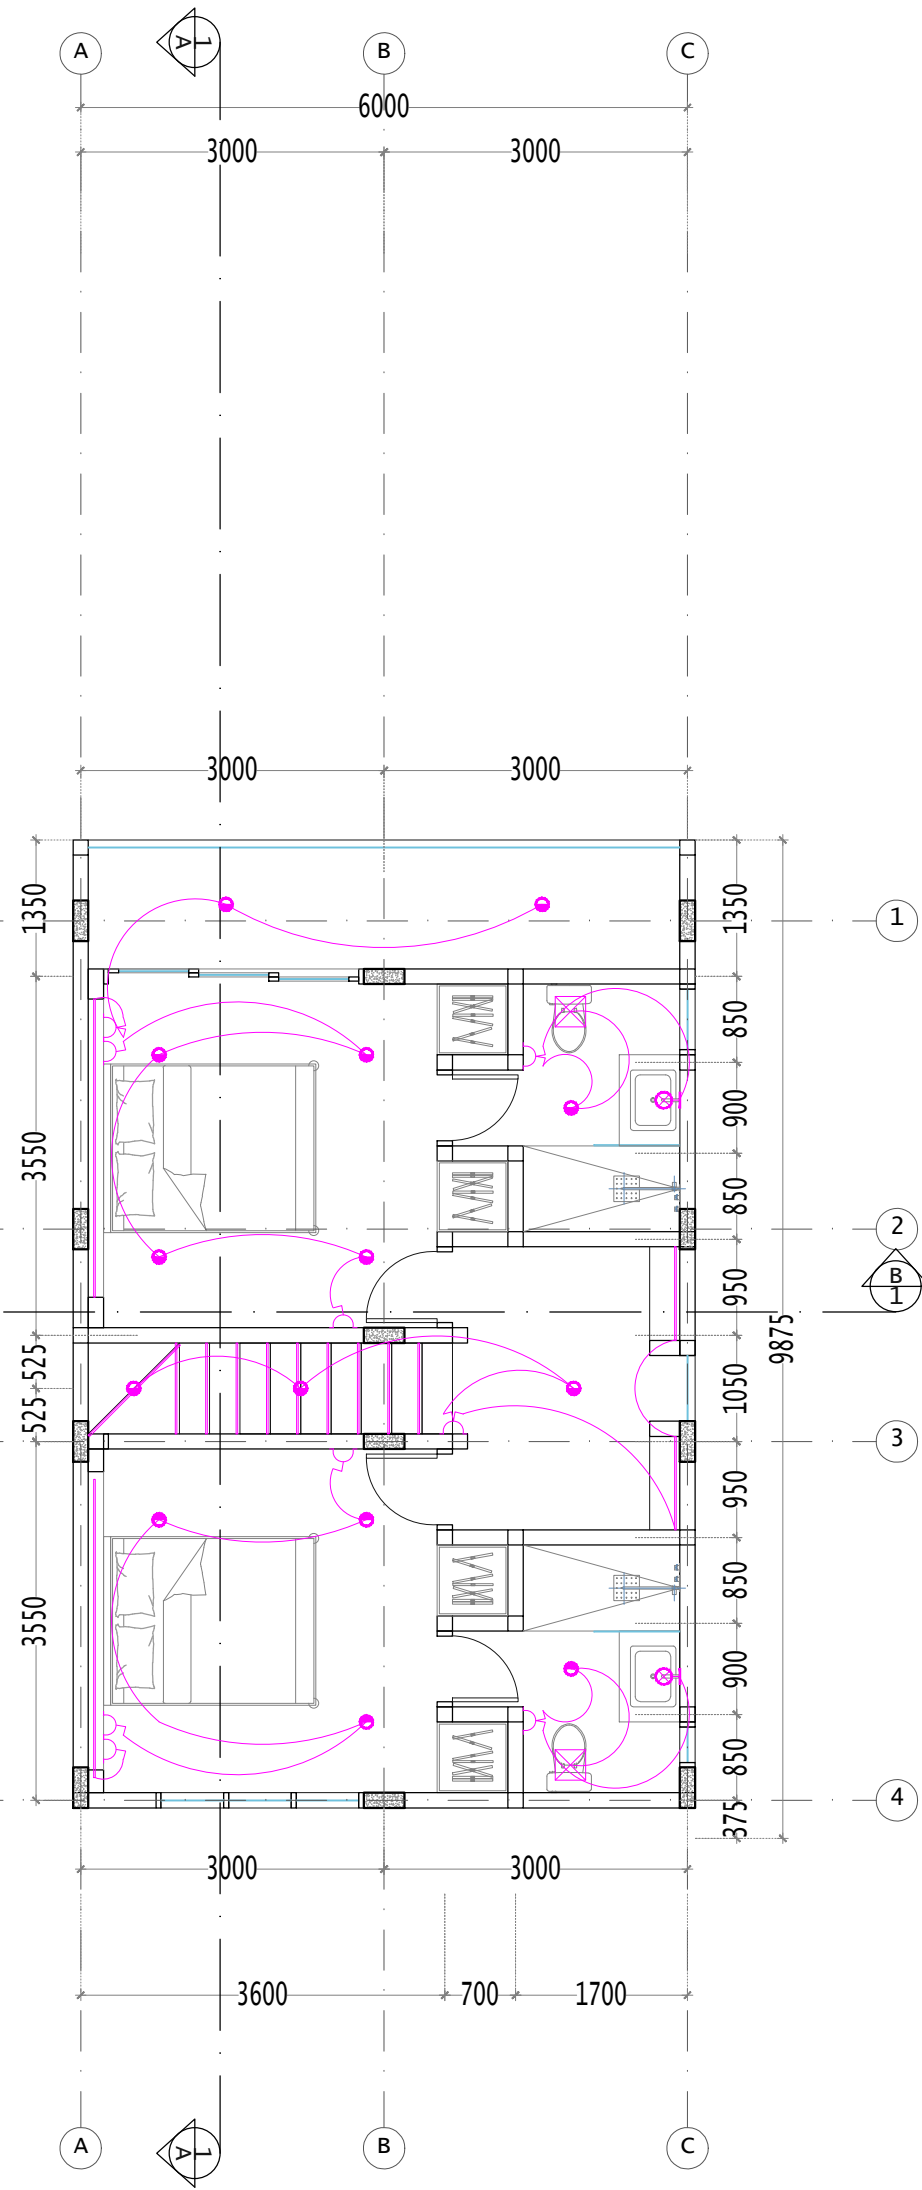


SECOND FLOOR  
LIGHTING PLAN | SCALE 1 : 75

LEGEND	
	DOWNLIGHT
	LED STRIP LIGHT
	WALL LIGHT
	GARDEN LIGHT
	SINGLE HANGING LIGHT
	CEILING EXHAUST

LEGEND	
	SINGLE SWITCH
	DOUBLE SWITCH
	HOTEL SWITCH
	PLUG
	OUTDOOR PLUG
	LAN PLUG

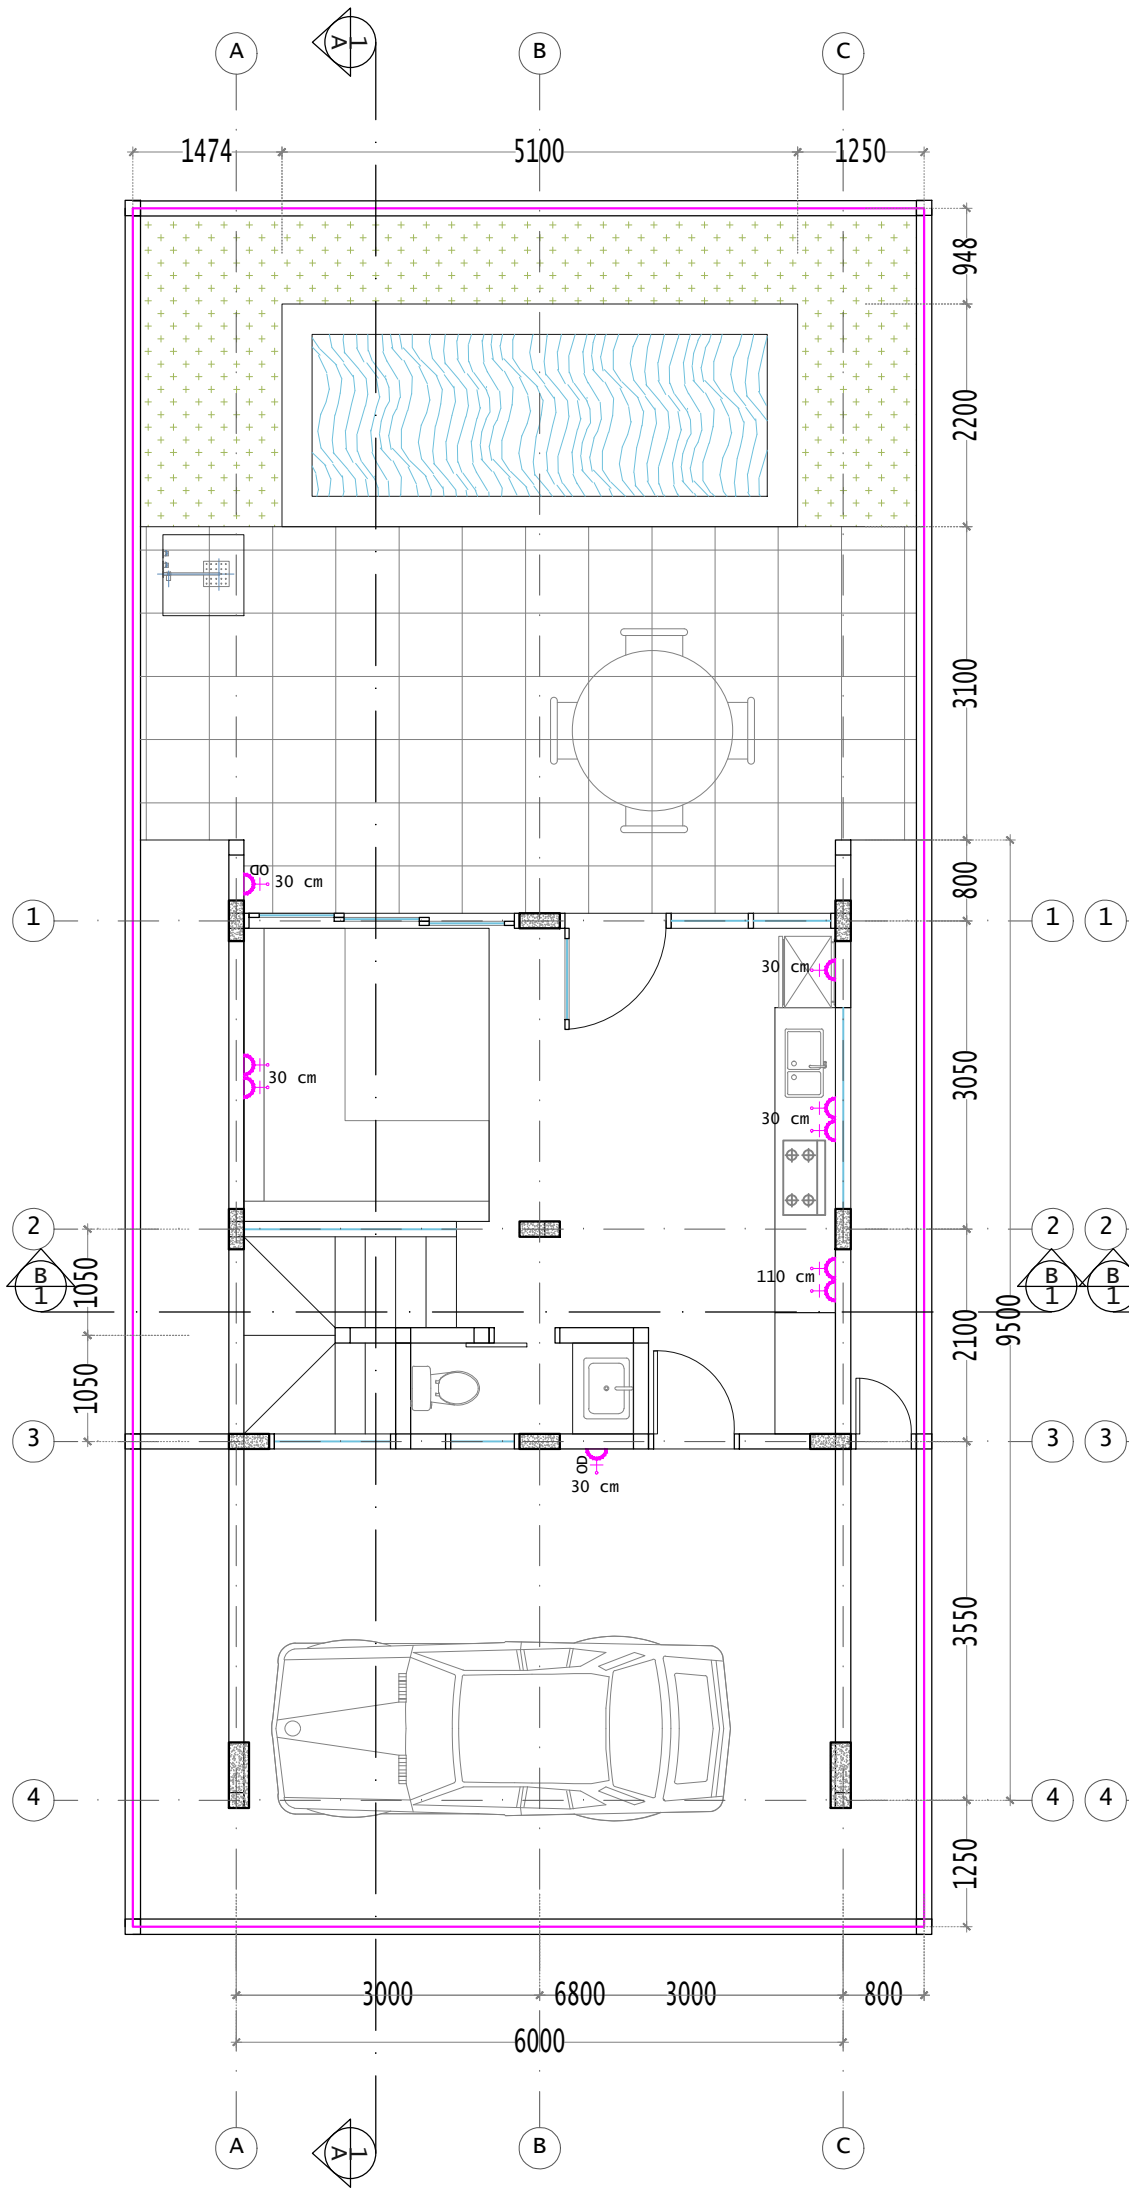



GROUND FLOOR  
SCALE 1 : 75

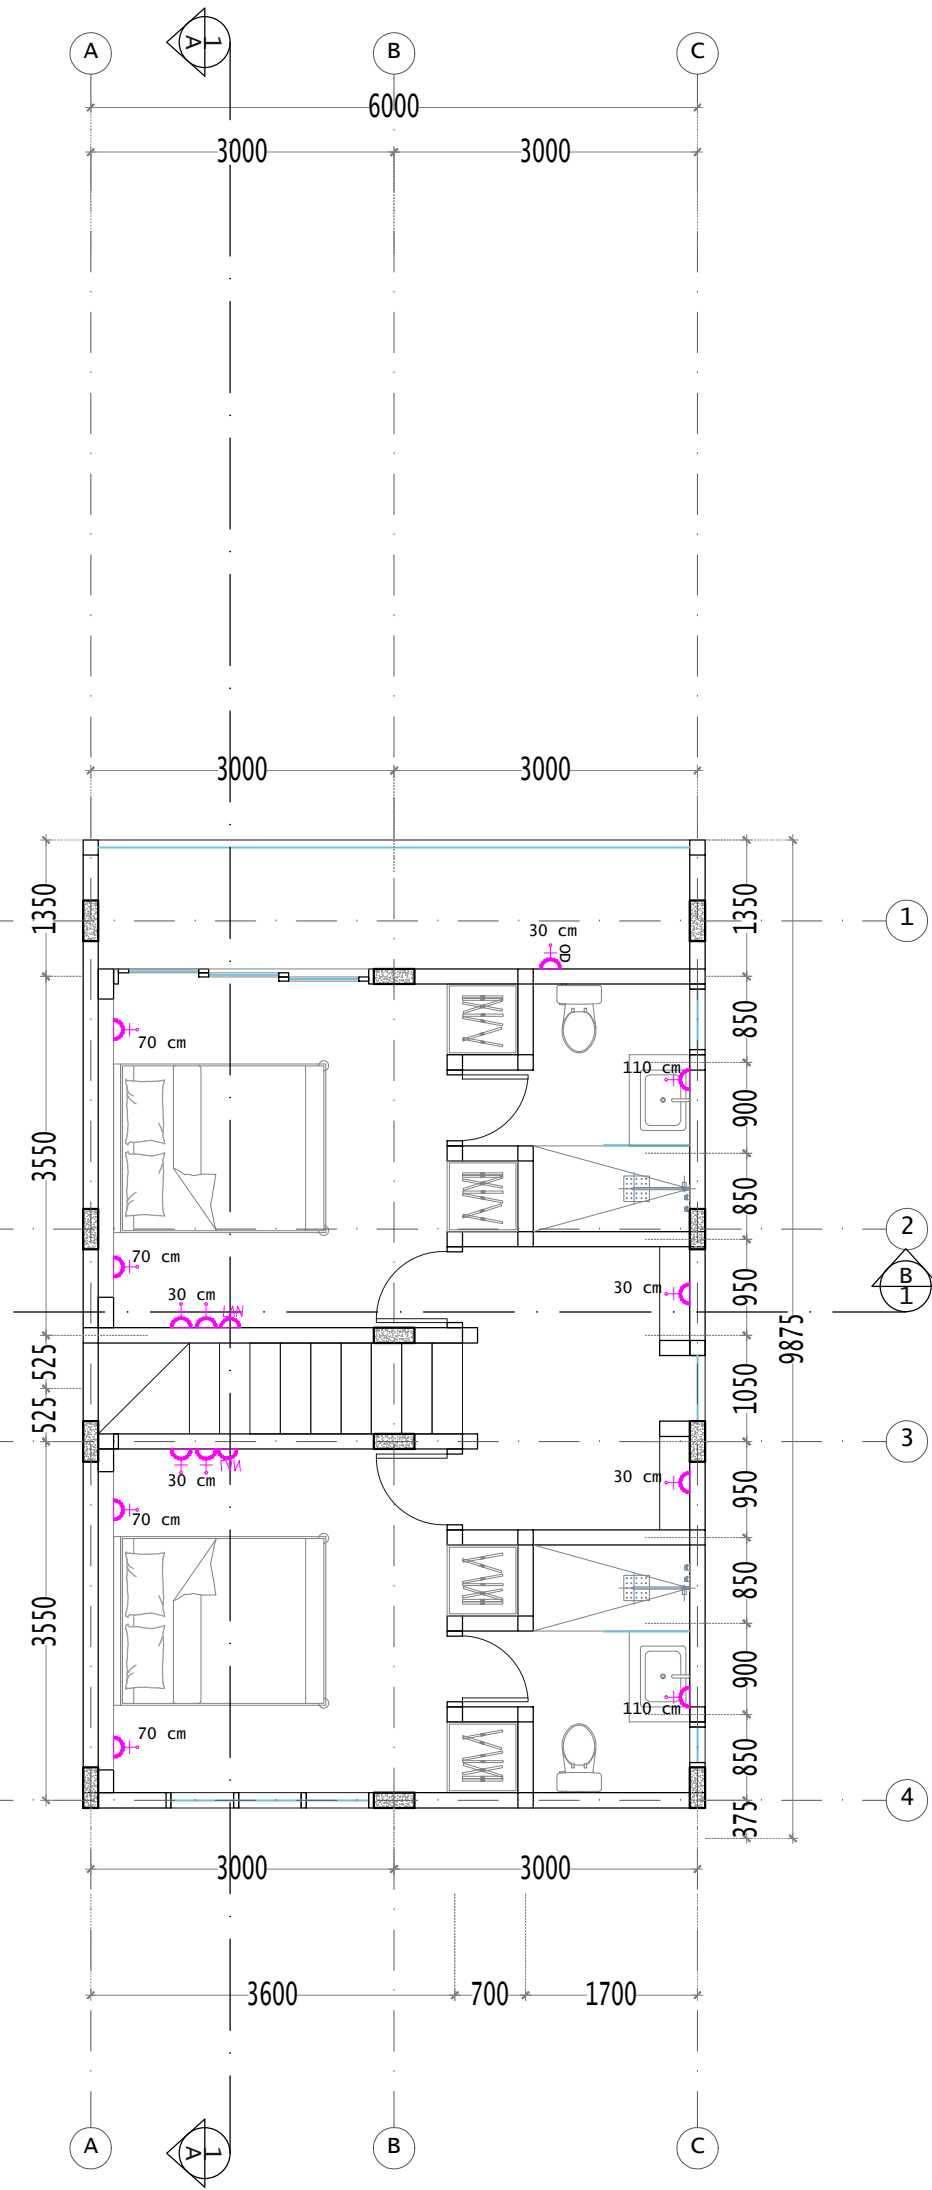


SECOND FLOOR  
SCALE 1 : 75

LEGEND	
	DOWNLIGHT
	LED STRIP LIGHT
	WALL LIGHT
	GARDEN LIGHT
	SINGLE HANGING LIGHT
	CEILING EXHAUST

LEGEND	
	SINGLE SWITCH
	DOUBLE SWITCH
	PLUG
	OUTDOOR PLUG
	LAN PLUG

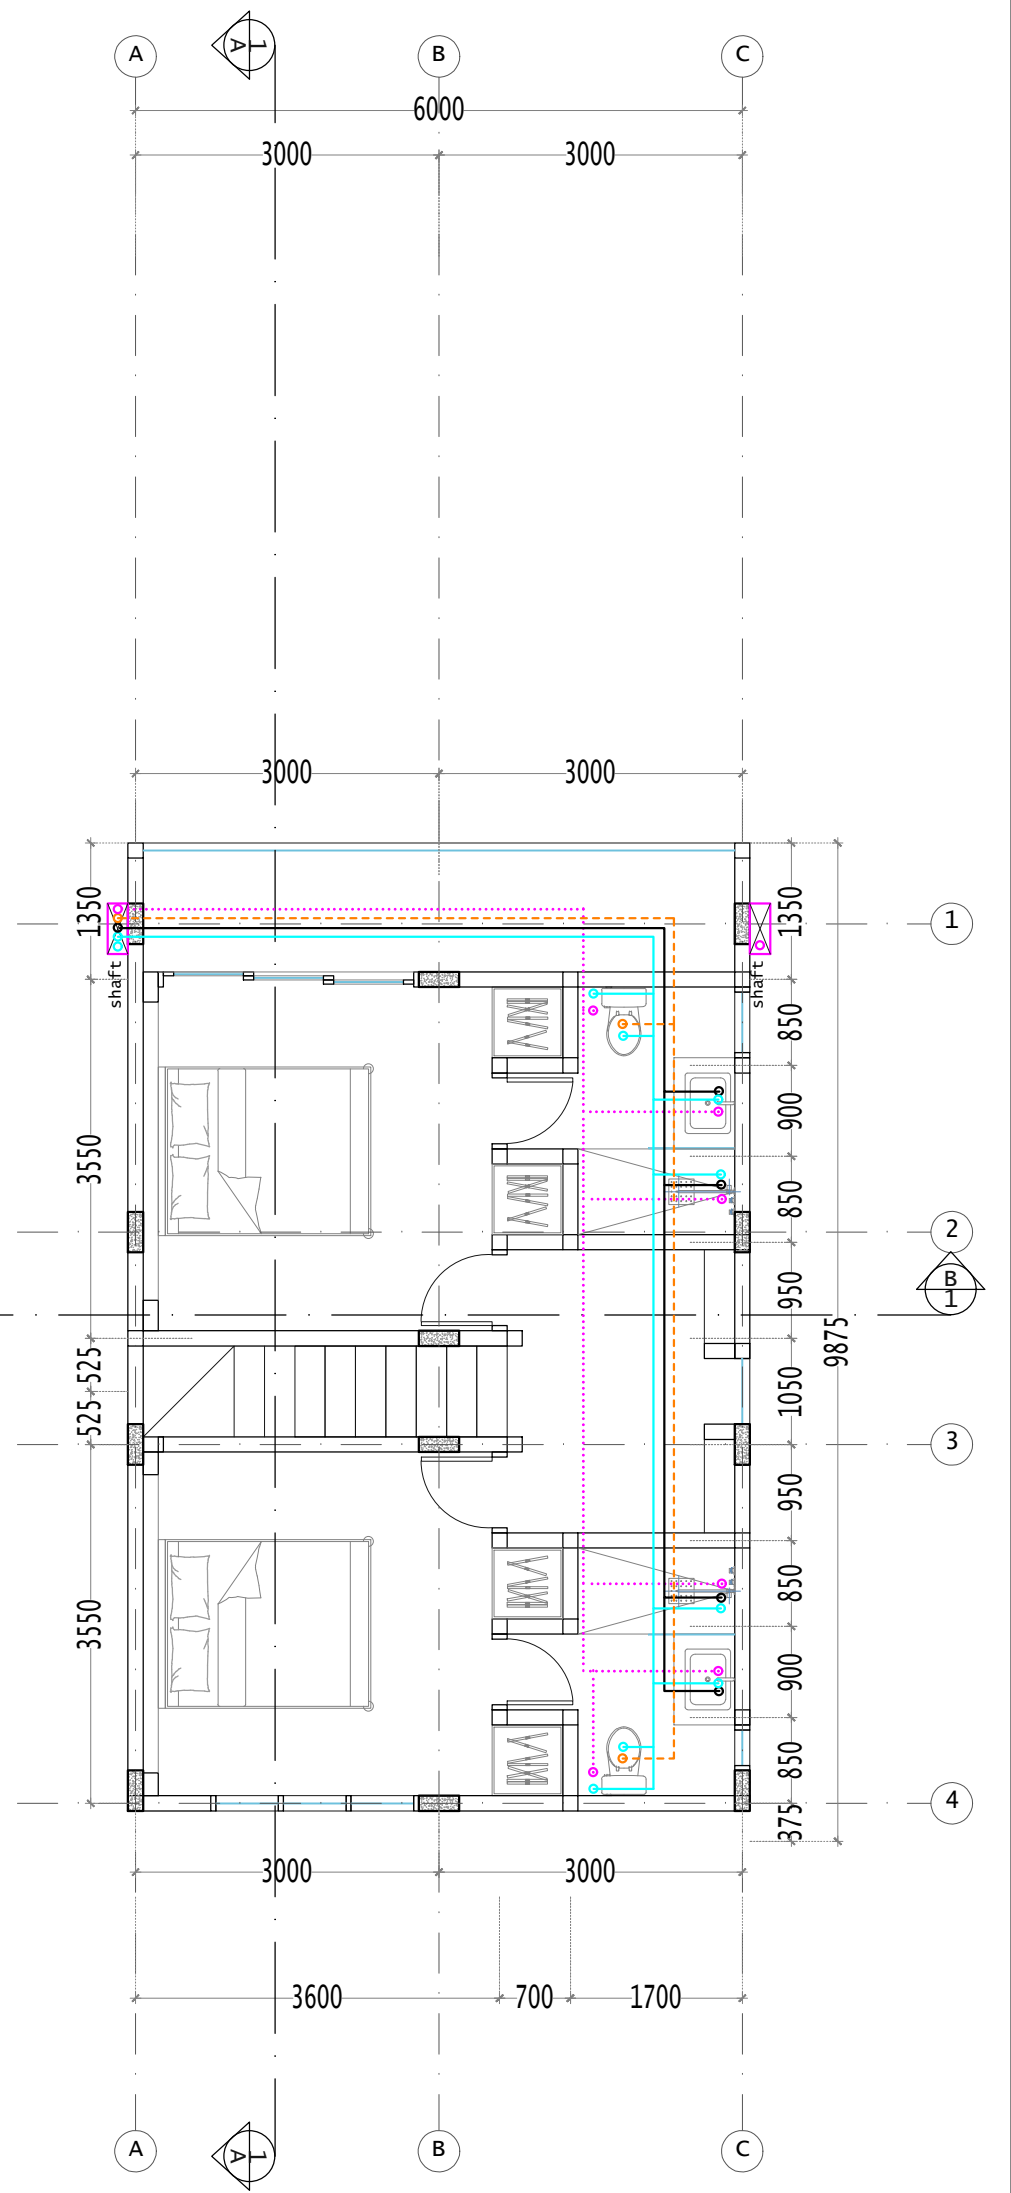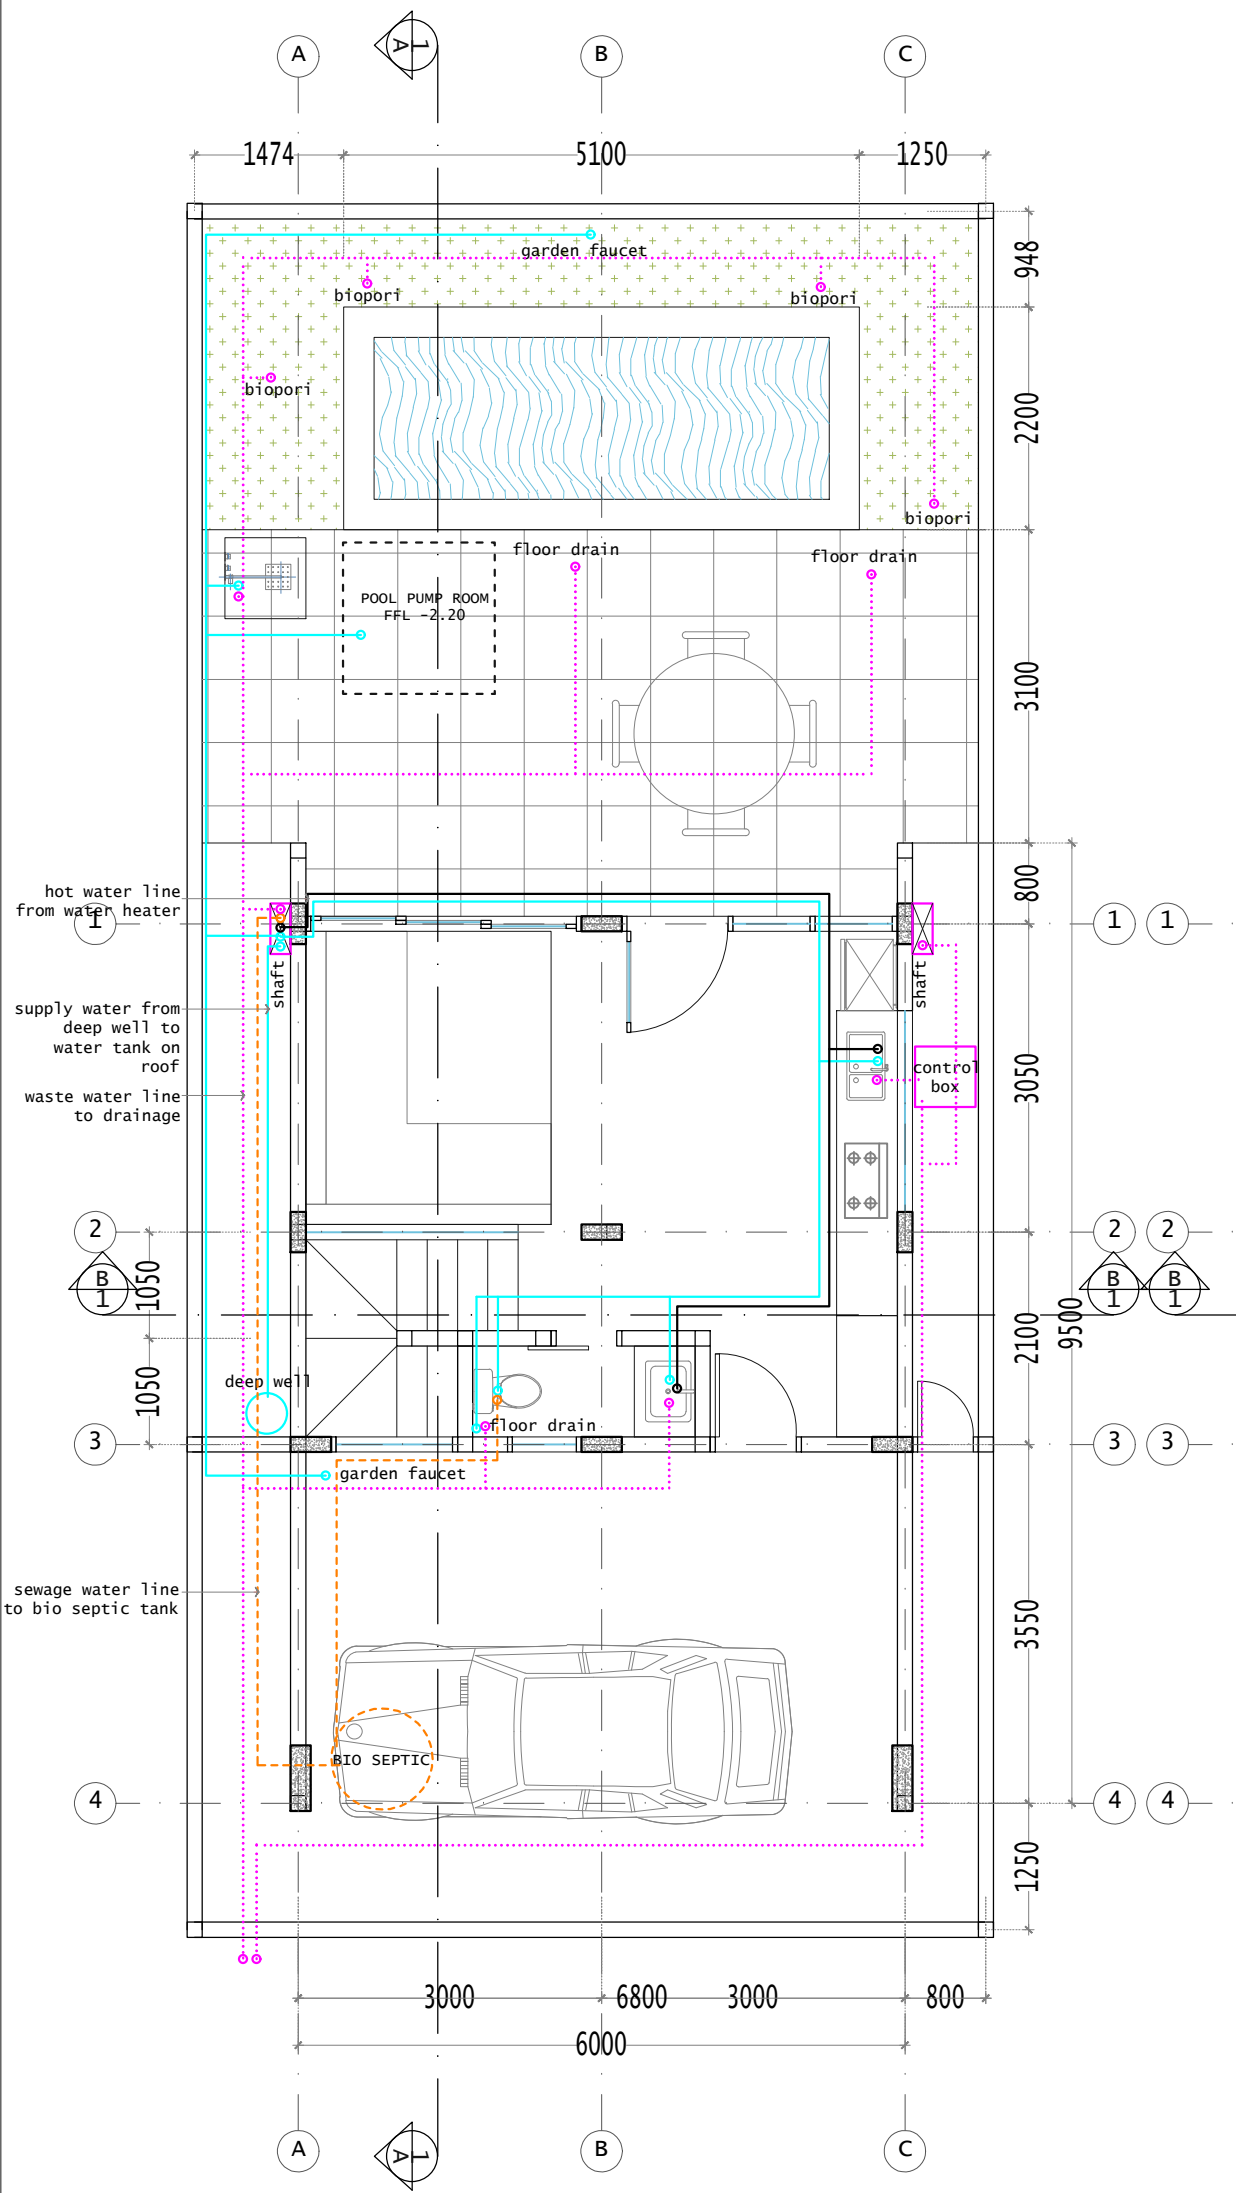

LEGEND	
	CLEAR WATER LINE
	SEWAGE WATER LINE
	WASTE WATER LINE

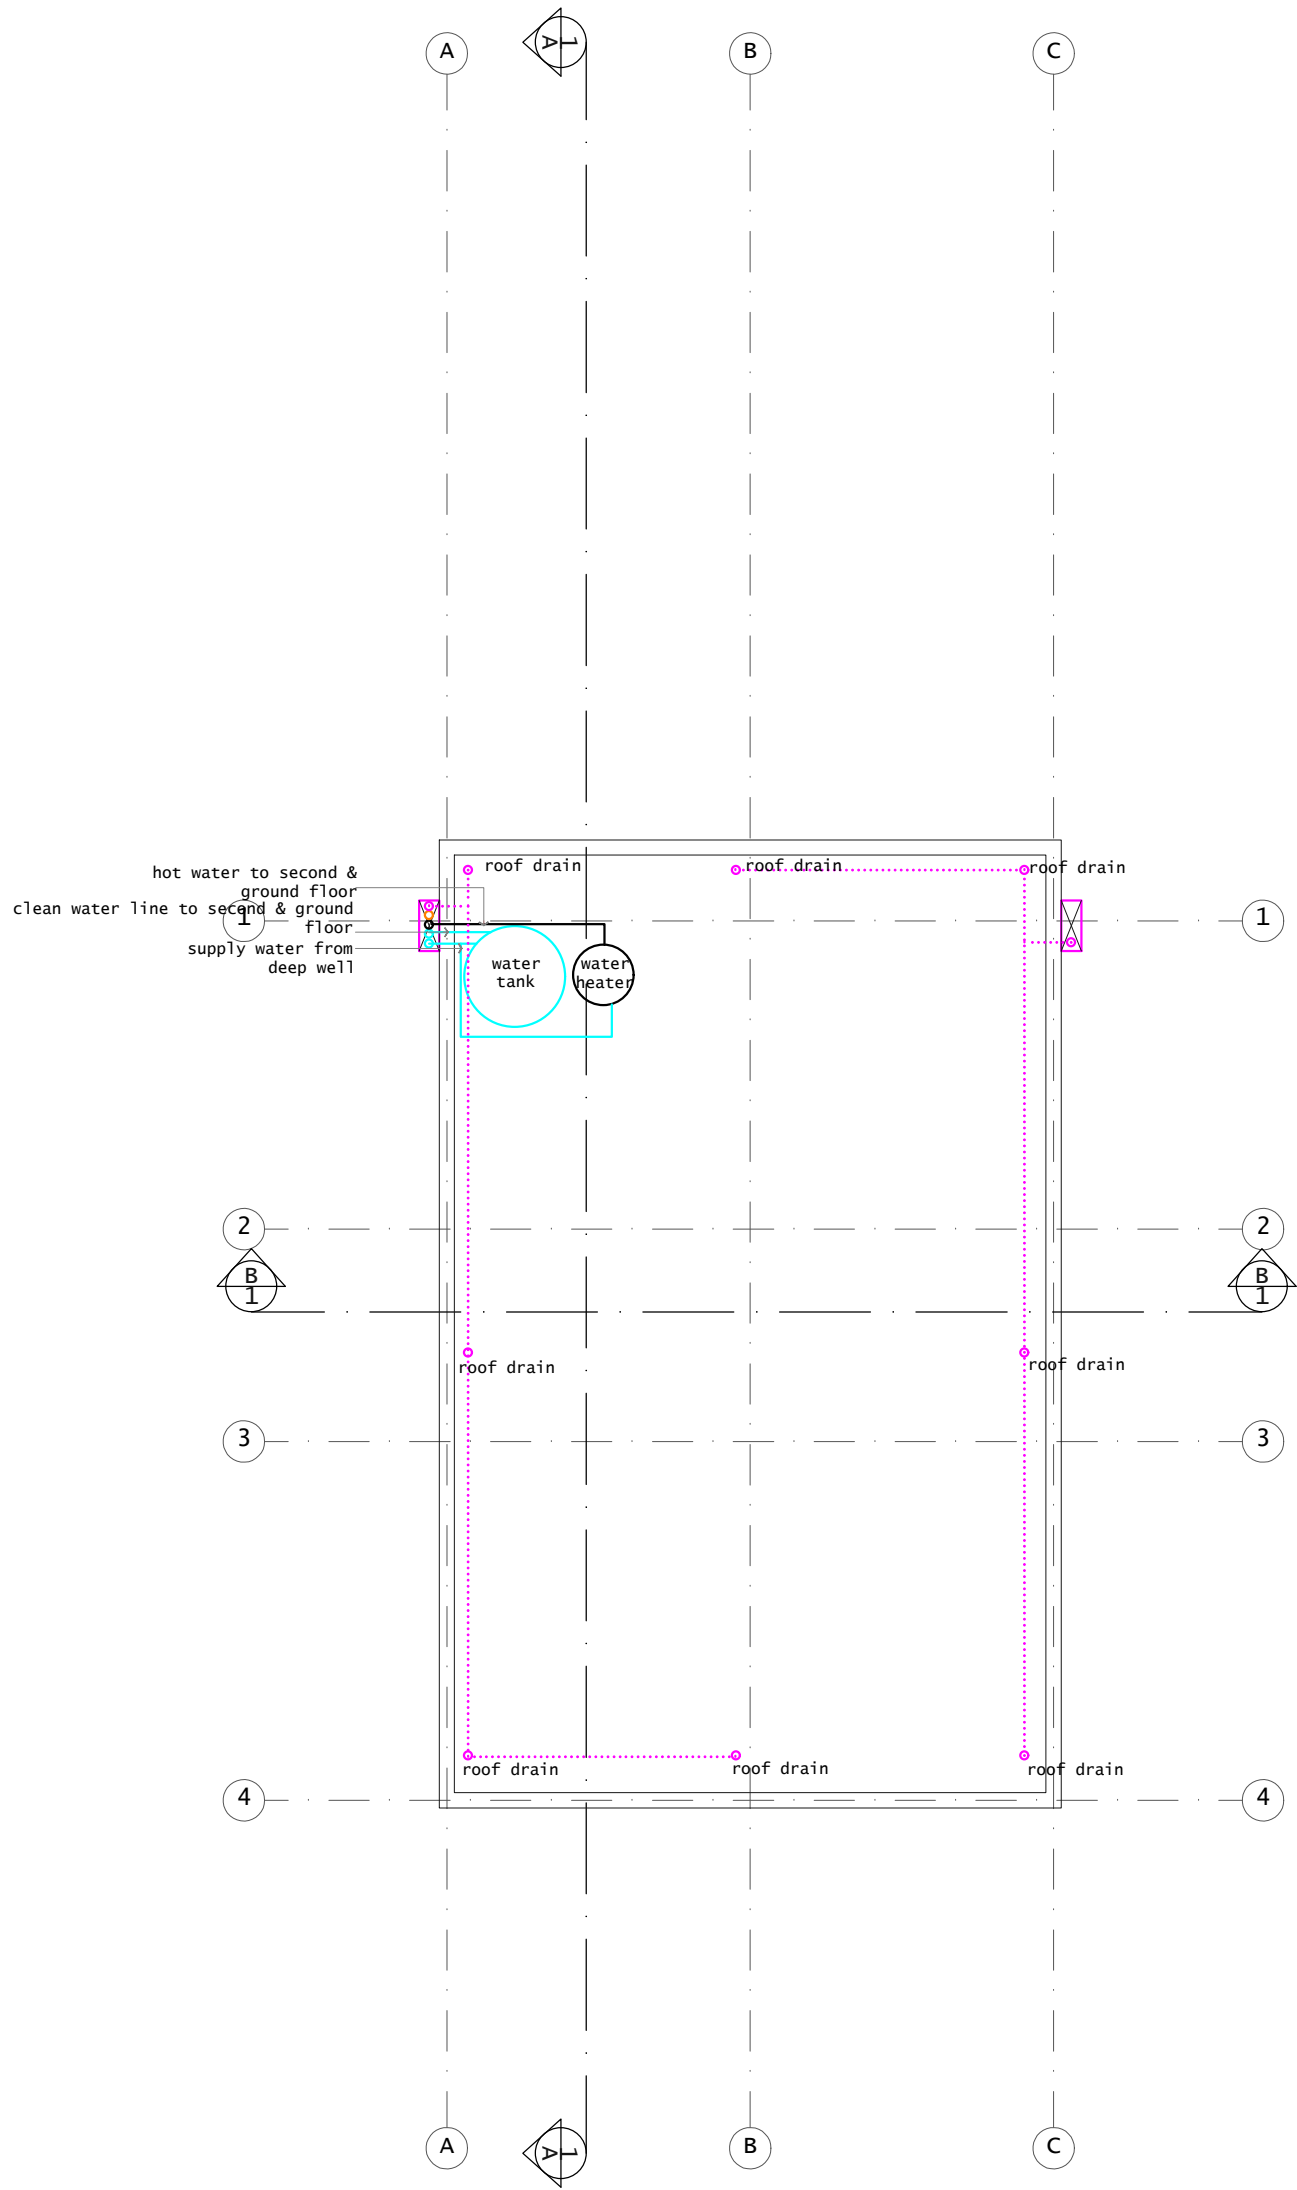

LEGEND	
	CLEAR WATER LINE
	SEWAGE WATER LINE
	WASTE WATER LINE