


WALL SCHEDULE	
2D SYMBOL	WALL TYPE
	SIDING-6
	INTERIOR-4
	INTERIOR RAILING
	ROOM DIVIDER
	8" CONCRETE STEM WALL

ELECTRICAL SCHEDULE		
2D SYMBOL	DESCRIPTION	COMMENTS
	CO/SMOKE DETECTOR	
	EXHAUST FAN	

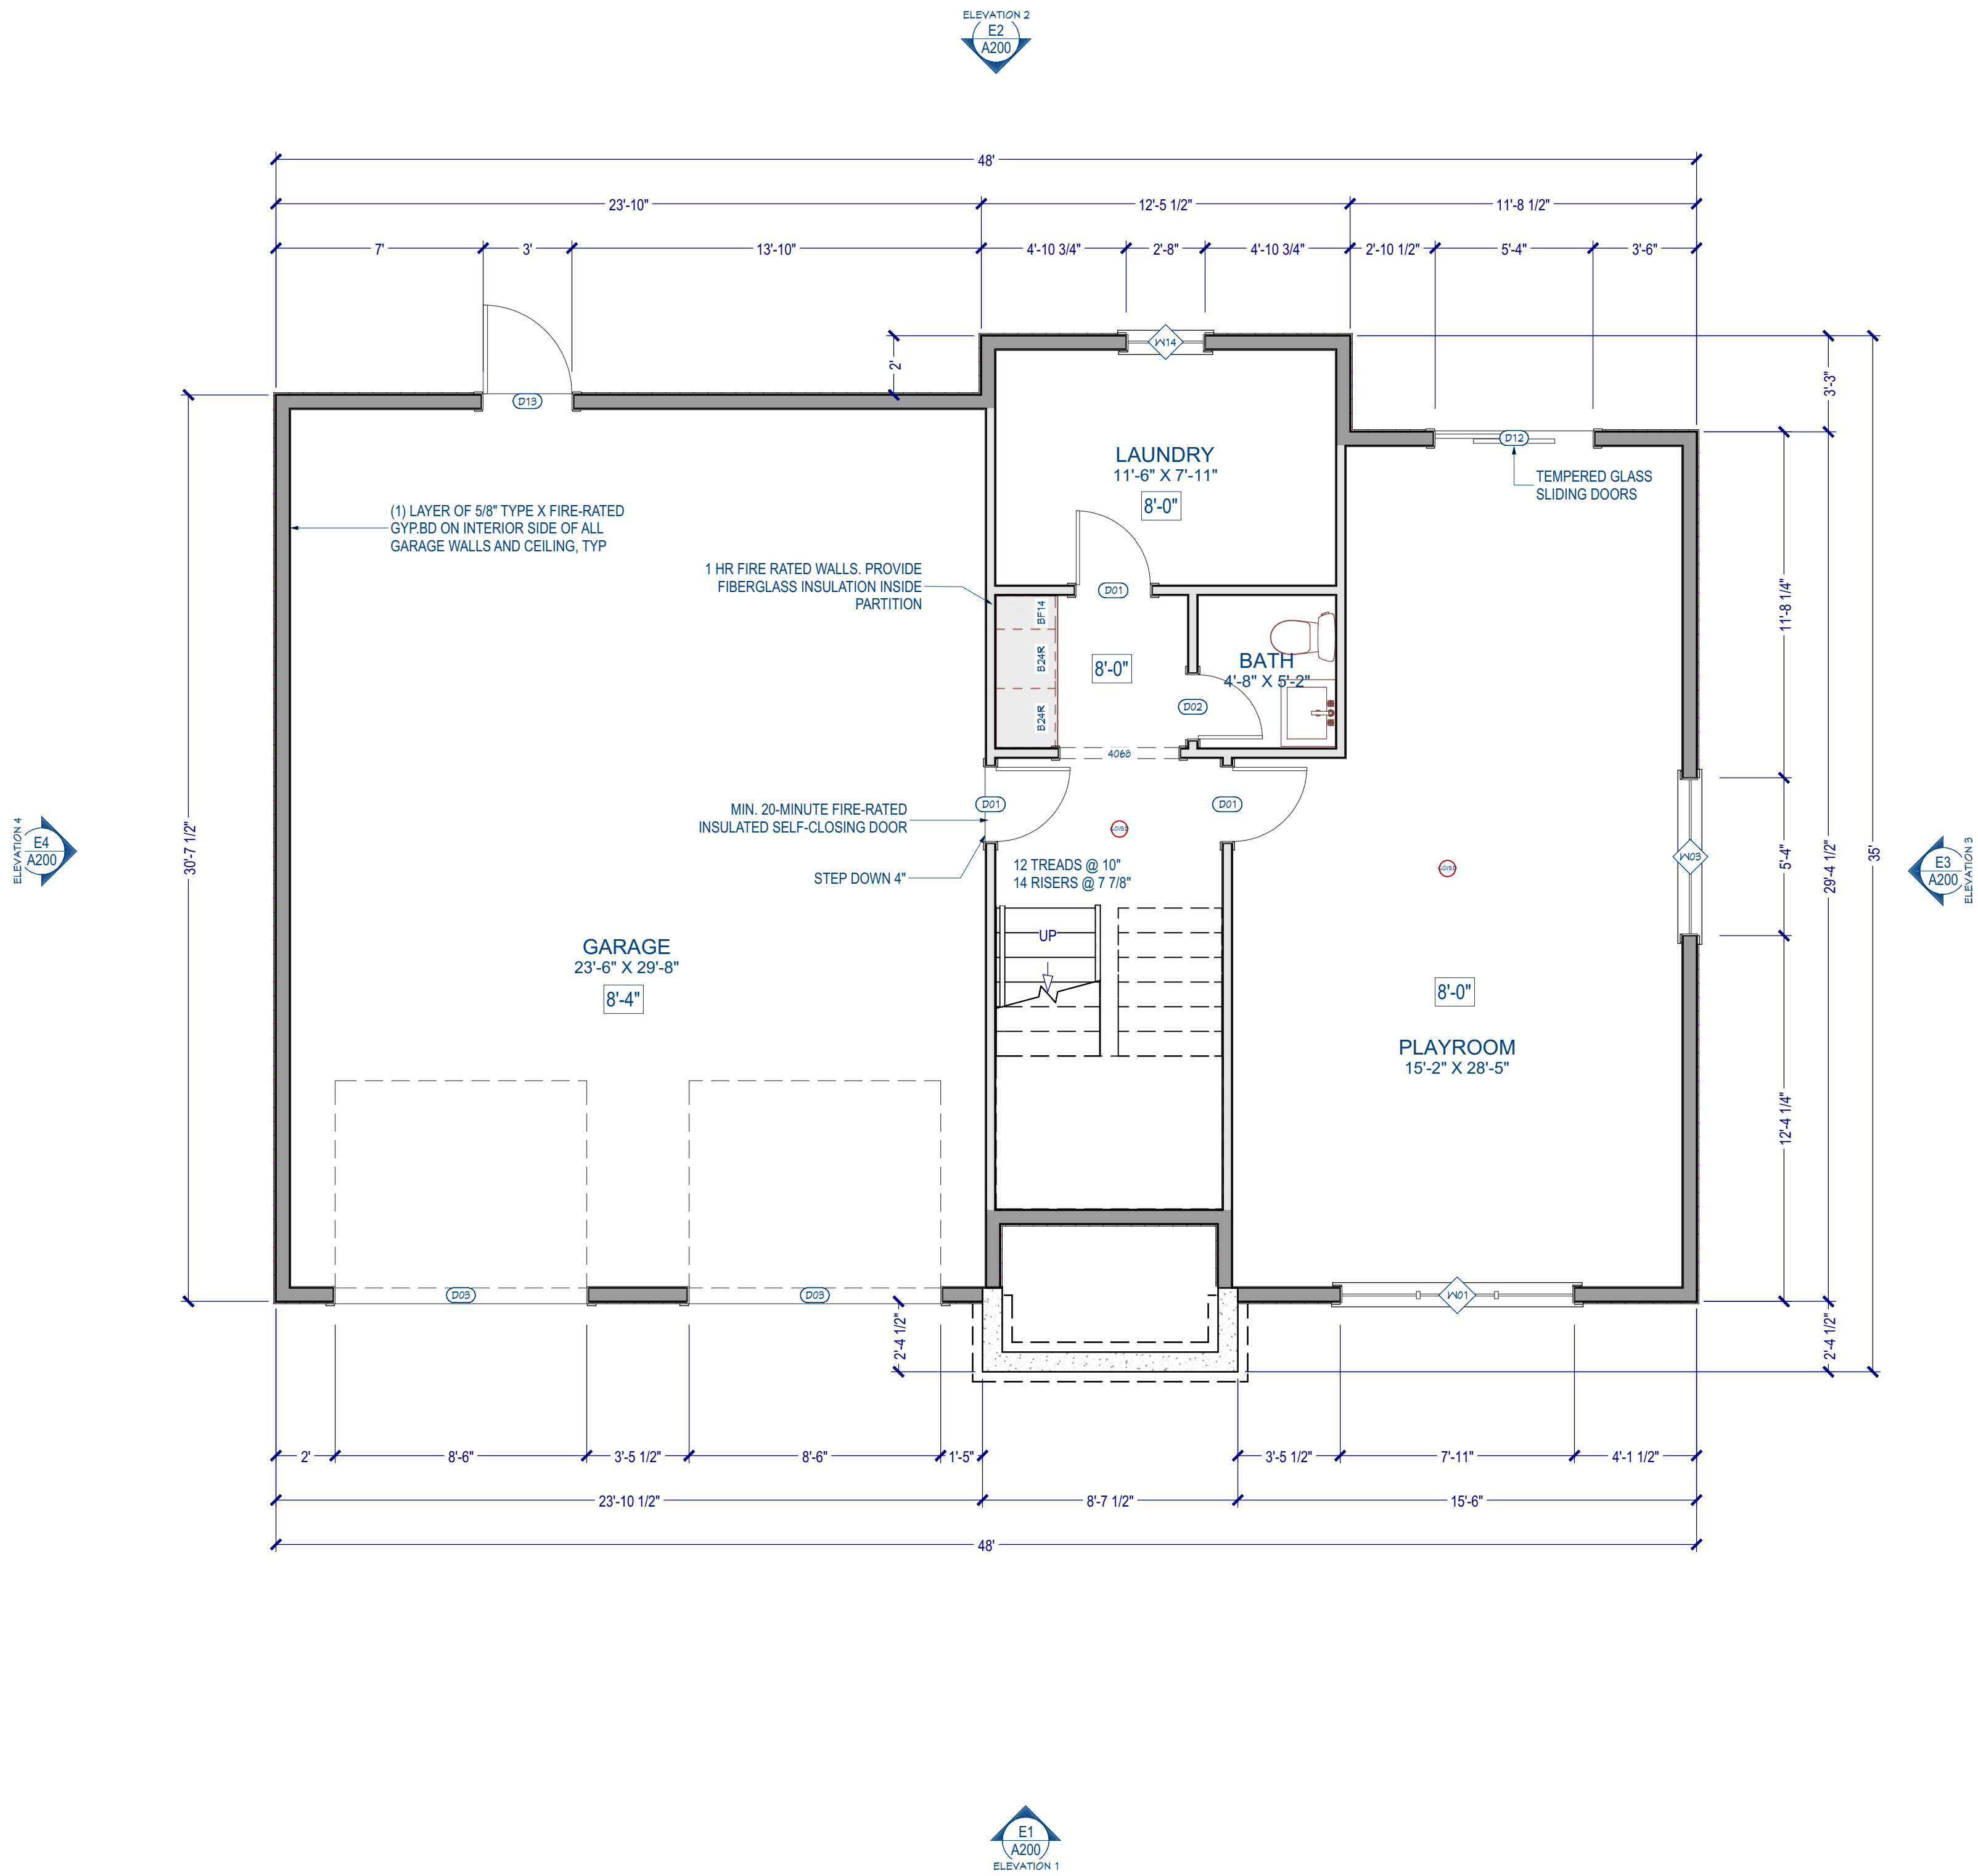


BASEMENT FLOOR PLAN

JIA HUA
ARCHITECT

REVISION TABLE	
NUMBER	DATE

295 JAMES FARM RD
STRATFORD CT
NEW
CONSTRUCTION

FLOOR PLANS

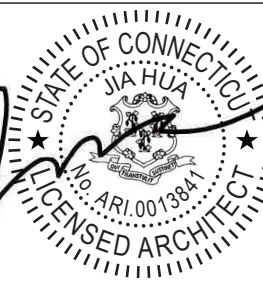

DRAWINGS PROVIDED BY:

DATE:

12/17/2024

SCALE:


1/4"=1'-0"

SHEET:

A101

WALL SCHEDULE		
2D SYMBOL	WALL TYPE	
	SIDING-6	
	INTERIOR-4	
	INTERIOR RAILING	
	ROOM DIVIDER	
	8" CONCRETE STEM WALL	

ELECTRICAL SCHEDULE		
2D SYMBOL	DESCRIPTION	COMMENTS
	CO/SMOKE DETECTOR	
	EXHAUST FAN	

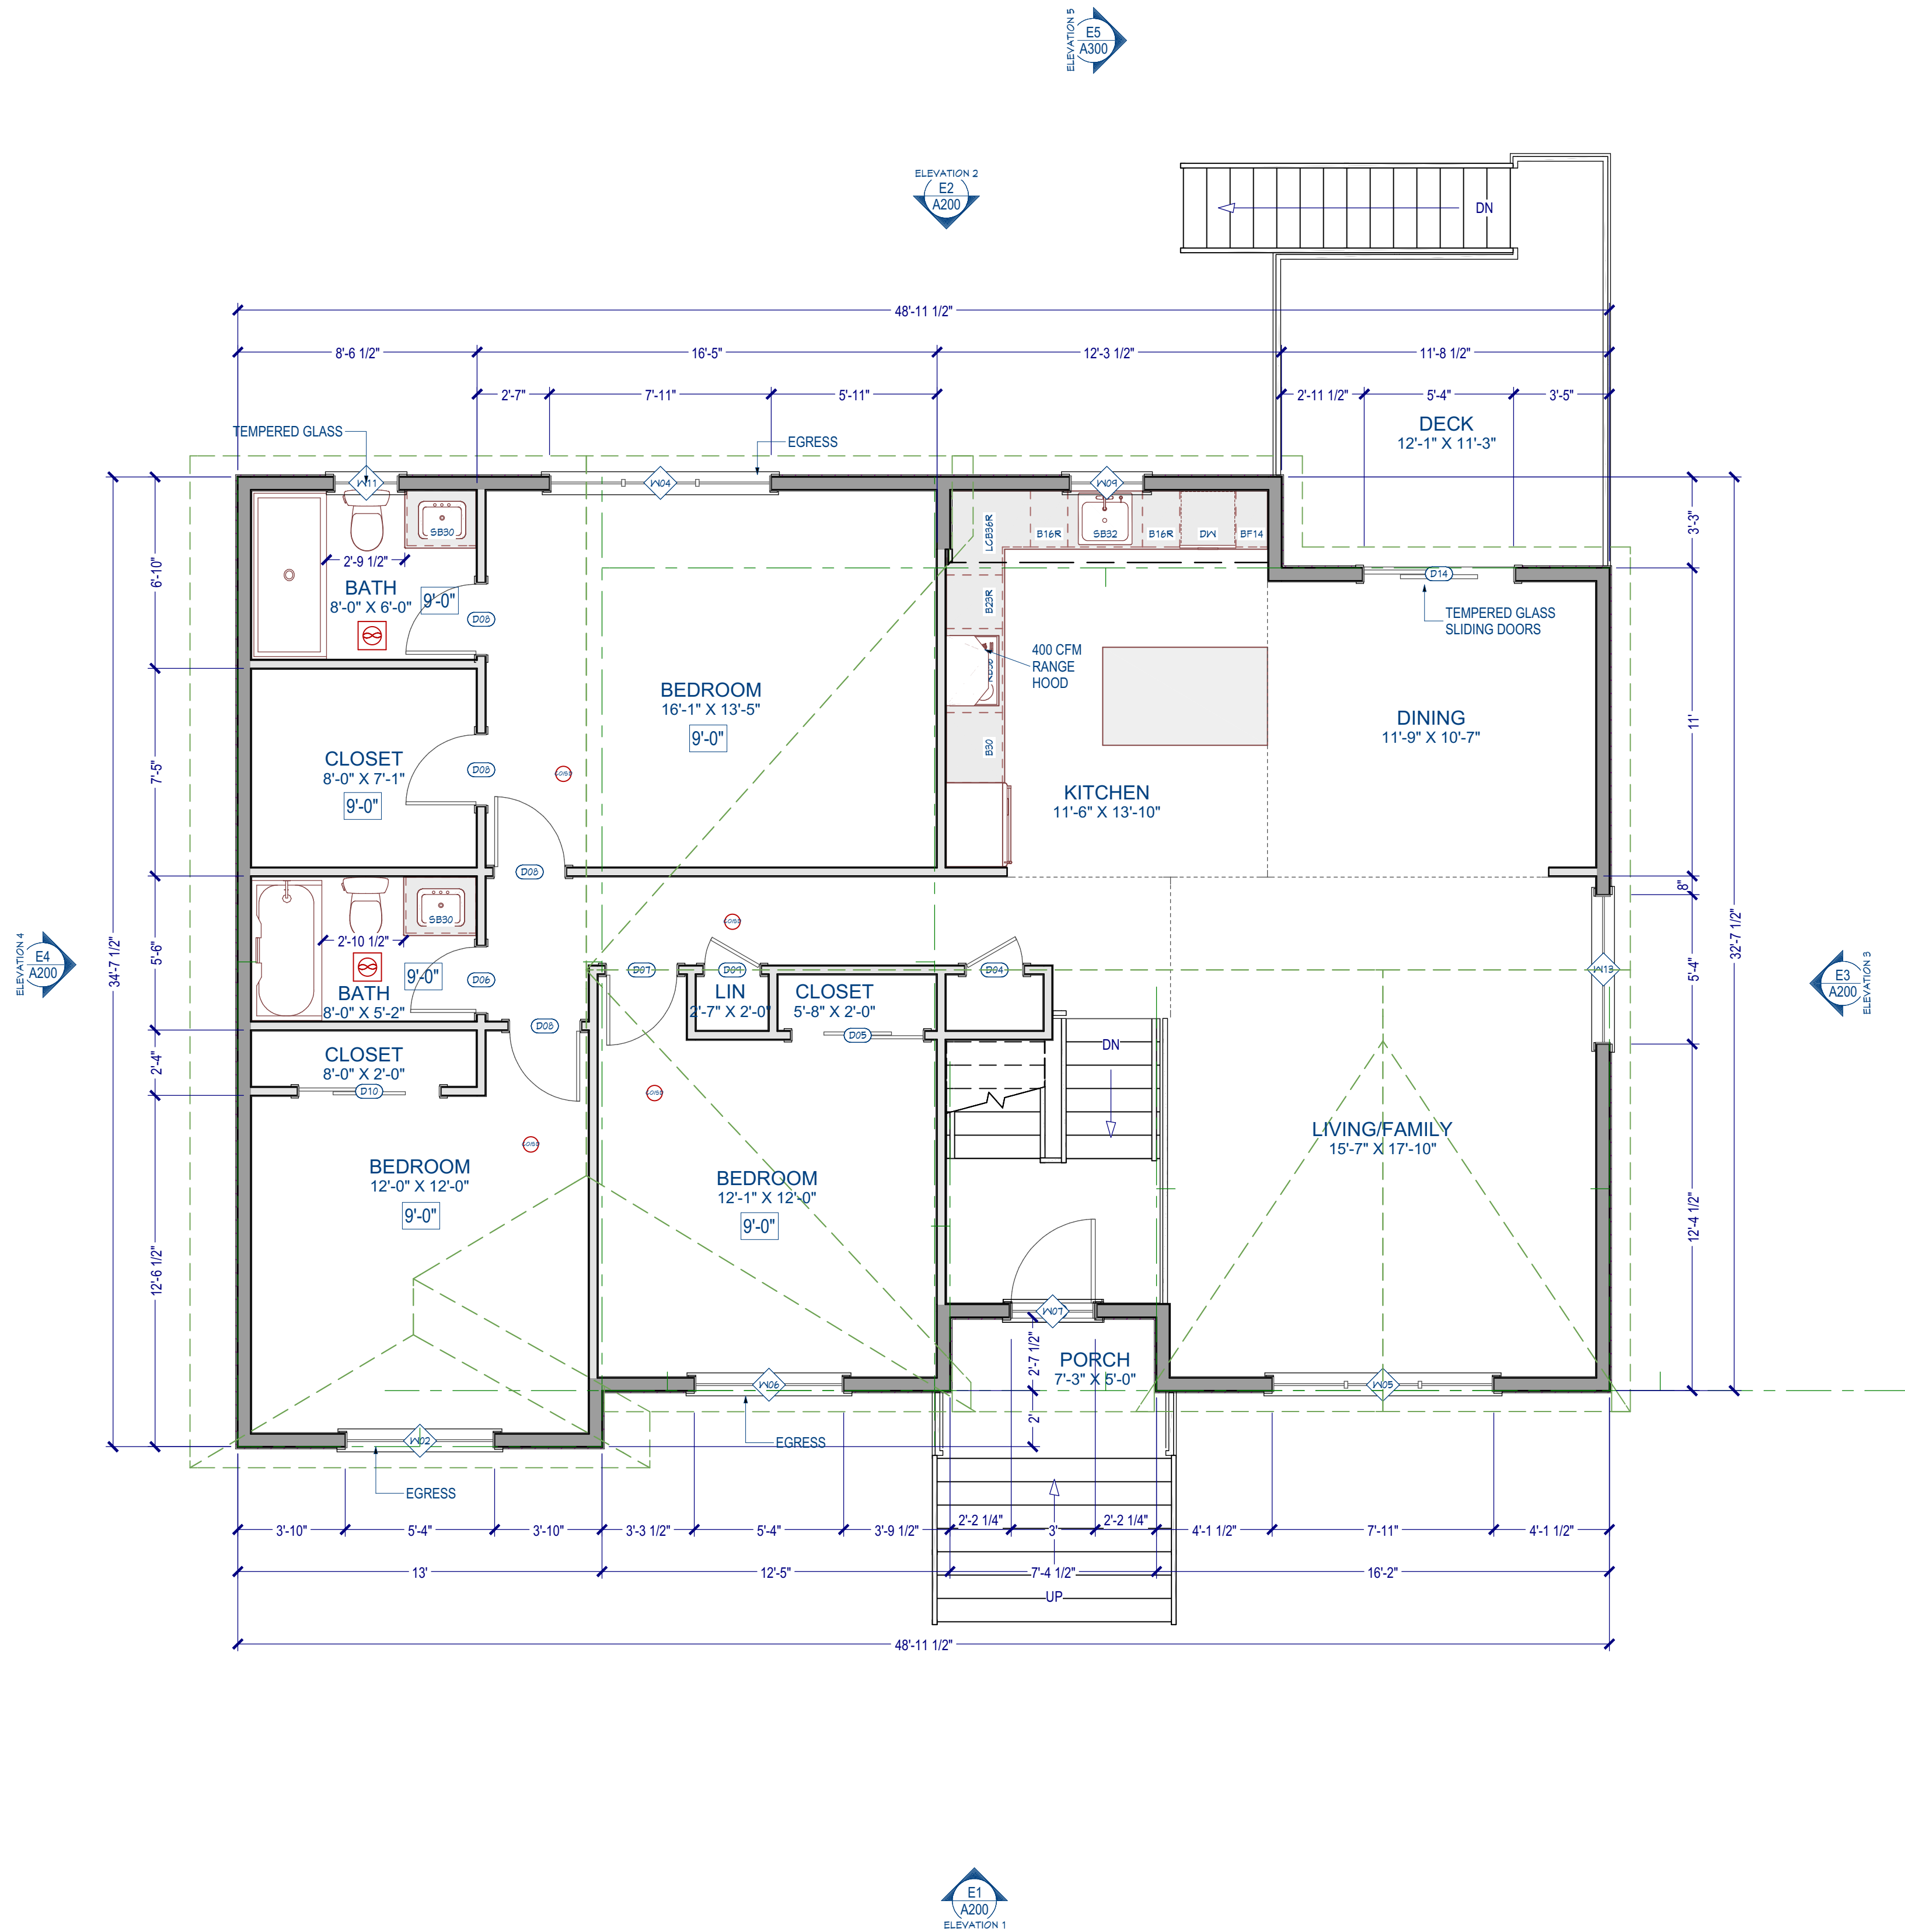

FIRST FLOOR PLAN

JIA HUA
ARCHITECT

REVISION TABLE		DESCRIPTION
NUMBER	DATE	REVIS

295 JAMES FARM RD
STRATFORD CT
NEW
CONSTRUCTION

FLOOR PLANS

DRAWINGS PROVIDED BY:

DATE:

12/17/2024

SCALE:

1/4"=1'-0"

SHEET:

A102