




OPTI-RK2A/NM
OPTI-FLOAT® LEVEL DETECTOR
2 FLOAT RETRO KIT CONTROL PANEL


Cox Research and Technology, Inc.
PO Box 77808
Baton Rouge, LA. 70879
(225) 756-3271 Fax (225) 755-1030

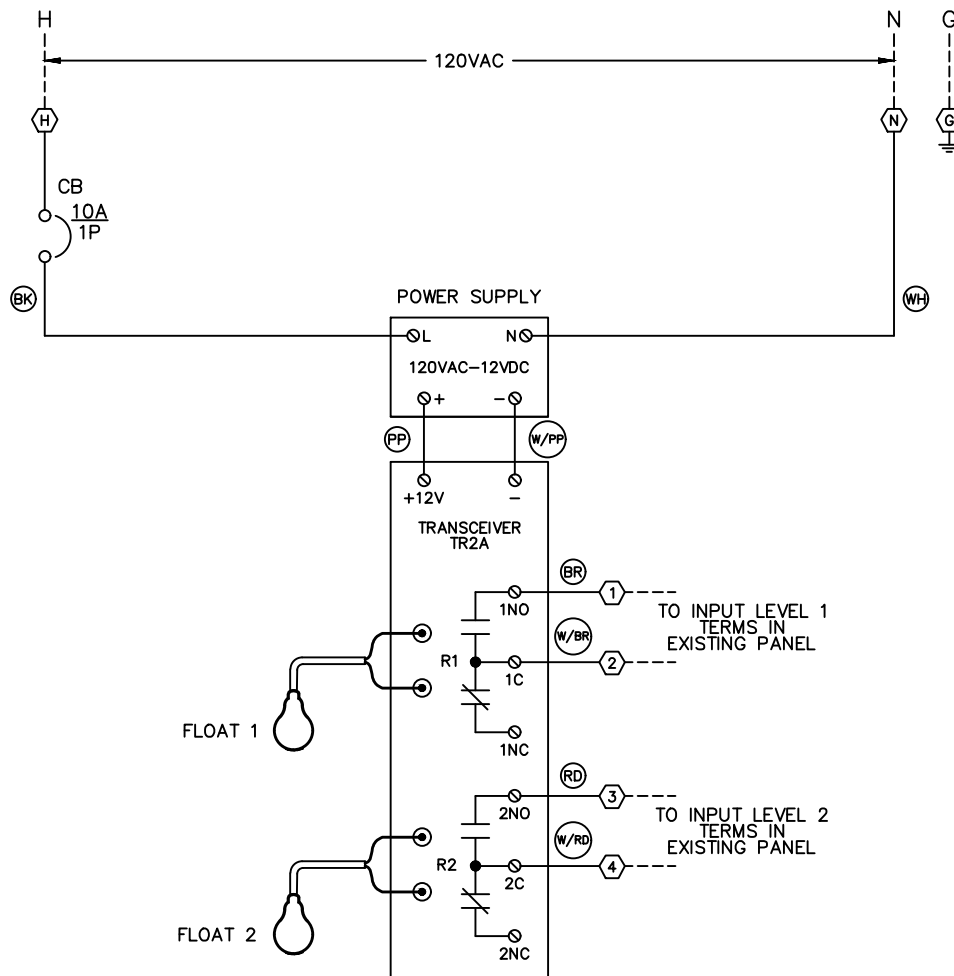

	Drawing Title							
	CONTROL DIAGRAM							
		OPTI-RK2		TR2 REPLACE TO TR2A		02/26/19		C.C.
		REFERENCE DRAWING	NO.	REVISION - LOCATION	ECN	DATE		BY
DATE: 02/12/26		S/N	Sales Engineer C.C.	Application Engineer C.C.	DRAWN BY: JCF	APPROVED BY:	DATE:	
	Project Title					PURCHASE ORDER NUMBER		
	OPTI-RK2A/NM					DRAWING NUMBER OPTI-RK2A/NM		
SCALE: N.T.S.						SHEET NUMBER		
						1		

COX[®]
RESEARCH

P.O. Box 77808
Baton Rouge, LA
70879
Ph. (225) 756-3271
Fax (225) 755-1030

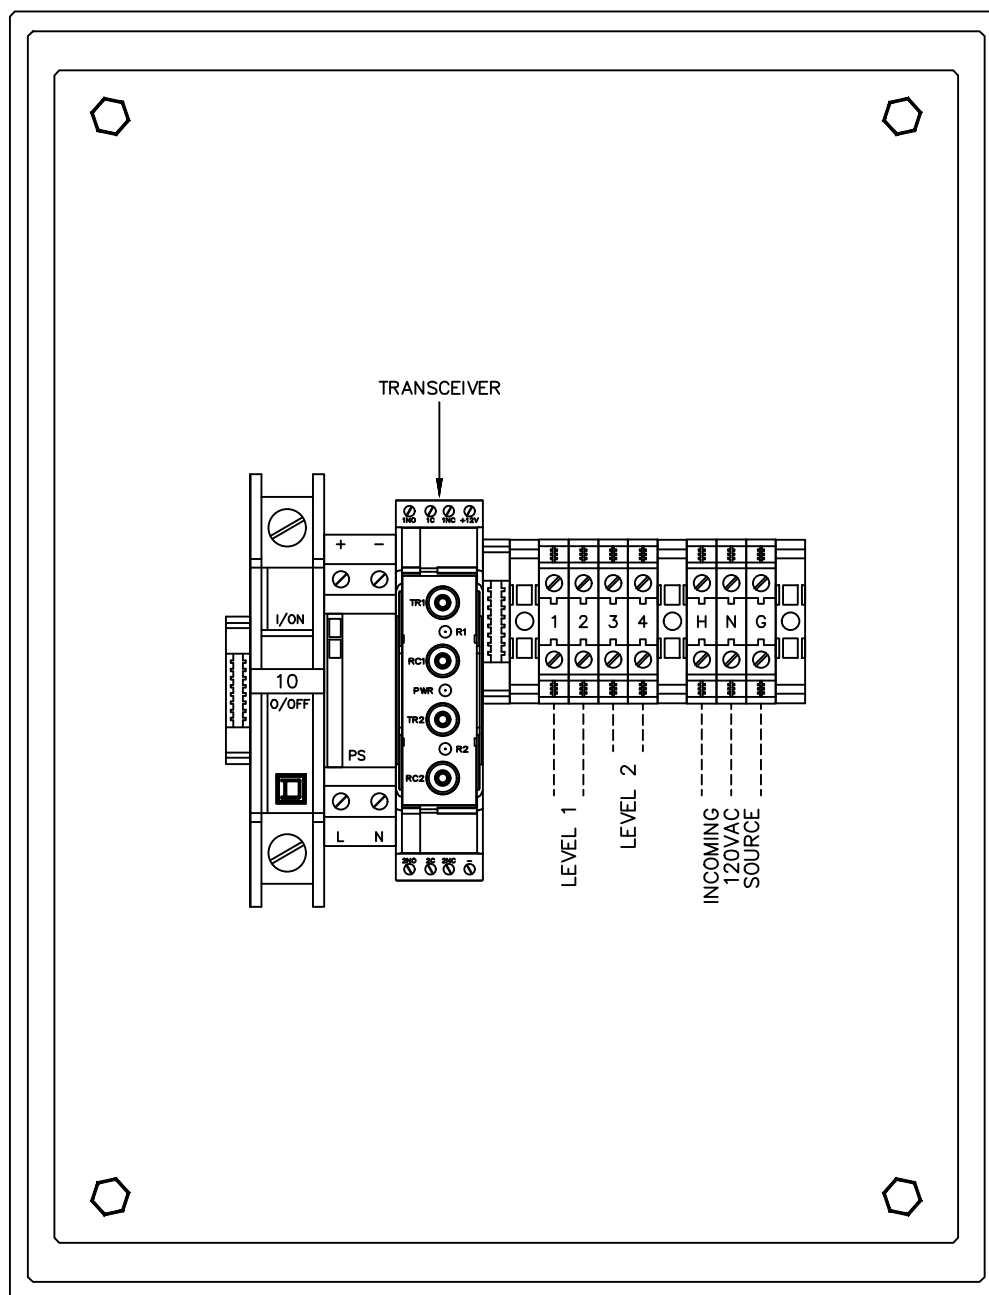


NON-METALLIC ENCLOSURE 12.07"H X 10.2"W X 7.3"D
 304 STAINLESS STEEL ENCLOSURE 11.5"H X 8.3"W X 7.8"D
 KEEP PANEL POWERED OFF UNTIL OPTI-FLOATS ARE COMPLETELY CONNECTED

	Drawing Title								
	EXTERNAL CONNECTIONS								
		OPTI-RK2			TR2 REPLACE TO TR2A			02/26/19	C.C.
		REFERENCE DRAWING	NO.	REVISION - LOCATION			ECN	DATE	BY
DATE: 02/12/26		S/N	Sales Engineer C.C.	Application Engineer C.C.	DRAWN BY: JCF		APPROVED BY: DATE:		
	Project Title				P.O. Box 77808 Baton Rouge, LA 70879 Ph. (225) 756-3271 Fax (225) 755-1030		PURCHASE ORDER NUMBER		
	OPTI-RK2A/NM						DRAWING NUMBER OPTI-RK2A/NM		
SCALE: N.T.S.							SHEET NUMBER		
					2				

The OPTI-FLOAT[®] TR2A Transceiver

Release Date
January 2019

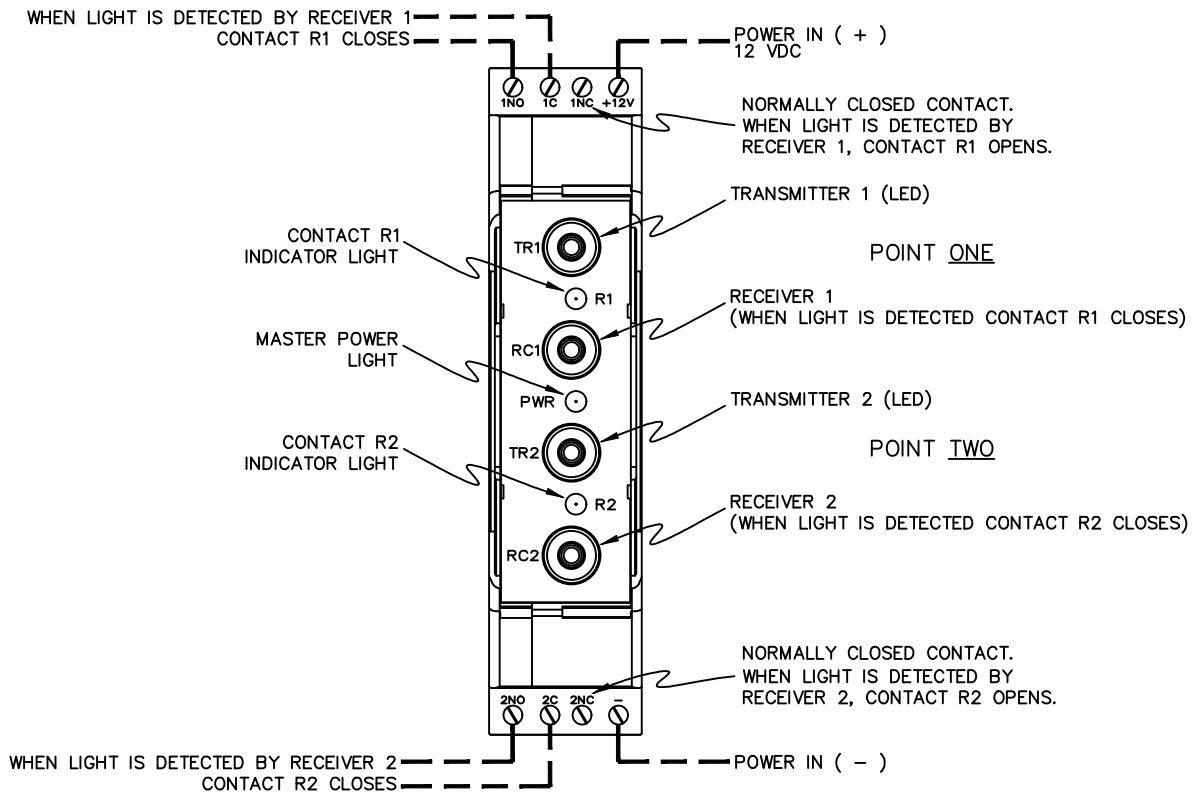

DATE: 02/12/26	Drawing Title TRANSCEIVER	REFERENCE DRAWING		NO.		REVISION - LOCATION		ECN	DATE	BY
		S/N		Sales Engineer C.C.		Application Engineer C.C.		DRAWN BY: JCF		APPROVED
		Project Title		P.O. Box 77808 Baton Rouge, LA 70879		Ph. (225) 756-3271 Fax (225) 755-1030		PURCHASE ORDER NUMBER		
		SCALE: N.T.S.		COX [®] RESEARCH		DRAWING NUMBER OPTI-RK2A/NM		SHEET NUMBER		3