





OPTI-RK2A/SS
OPTI-FLOAT® LEVEL DETECTOR
2 FLOAT RETRO KIT CONTROL PANEL

Cox Research and Technology, Inc.
PO Box 77808
Baton Rouge, LA. 70879
(225) 756-3271 Fax (225) 755-1030

OPTI-RK2A/SS

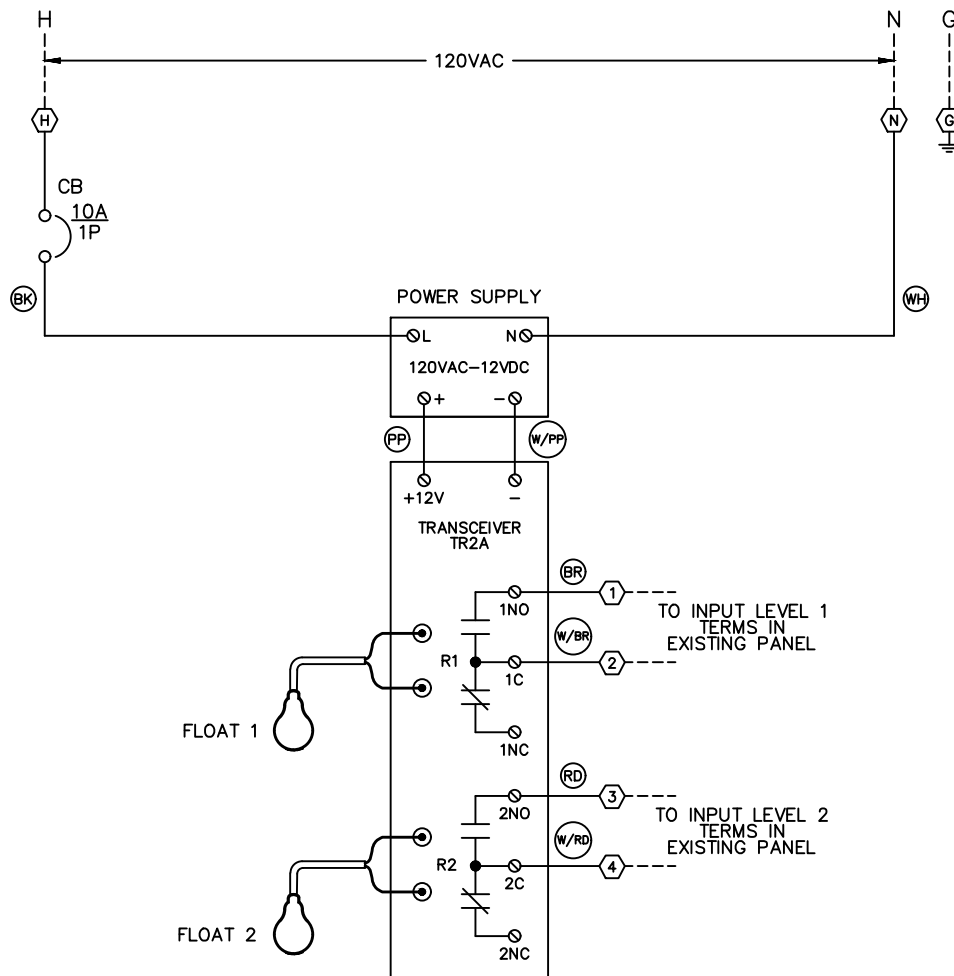

	Drawing Title							
	CONTROL DIAGRAM							
		OPTI-RK2		TR2 REPLACE TO TR2A		02/26/19	C.C.	
		REFERENCE DRAWING	NO.	REVISION - LOCATION	ECN	DATE	BY	
DATE: 02/12/26		S/N	Sales Engineer C.C.	Application Engineer C.C.	DRAWN BY: JCF	APPROVED BY:	DATE:	
	Project Title					PURCHASE ORDER NUMBER		
	OPTI-RK2A/SS					DRAWING NUMBER OPTI-RK2A/SS		
SCALE: N.T.S.						SHEET NUMBER 1		
		P.O. Box 77808 Baton Rouge, LA 70879 Ph. (225) 756-3271 Fax (225) 755-1030						

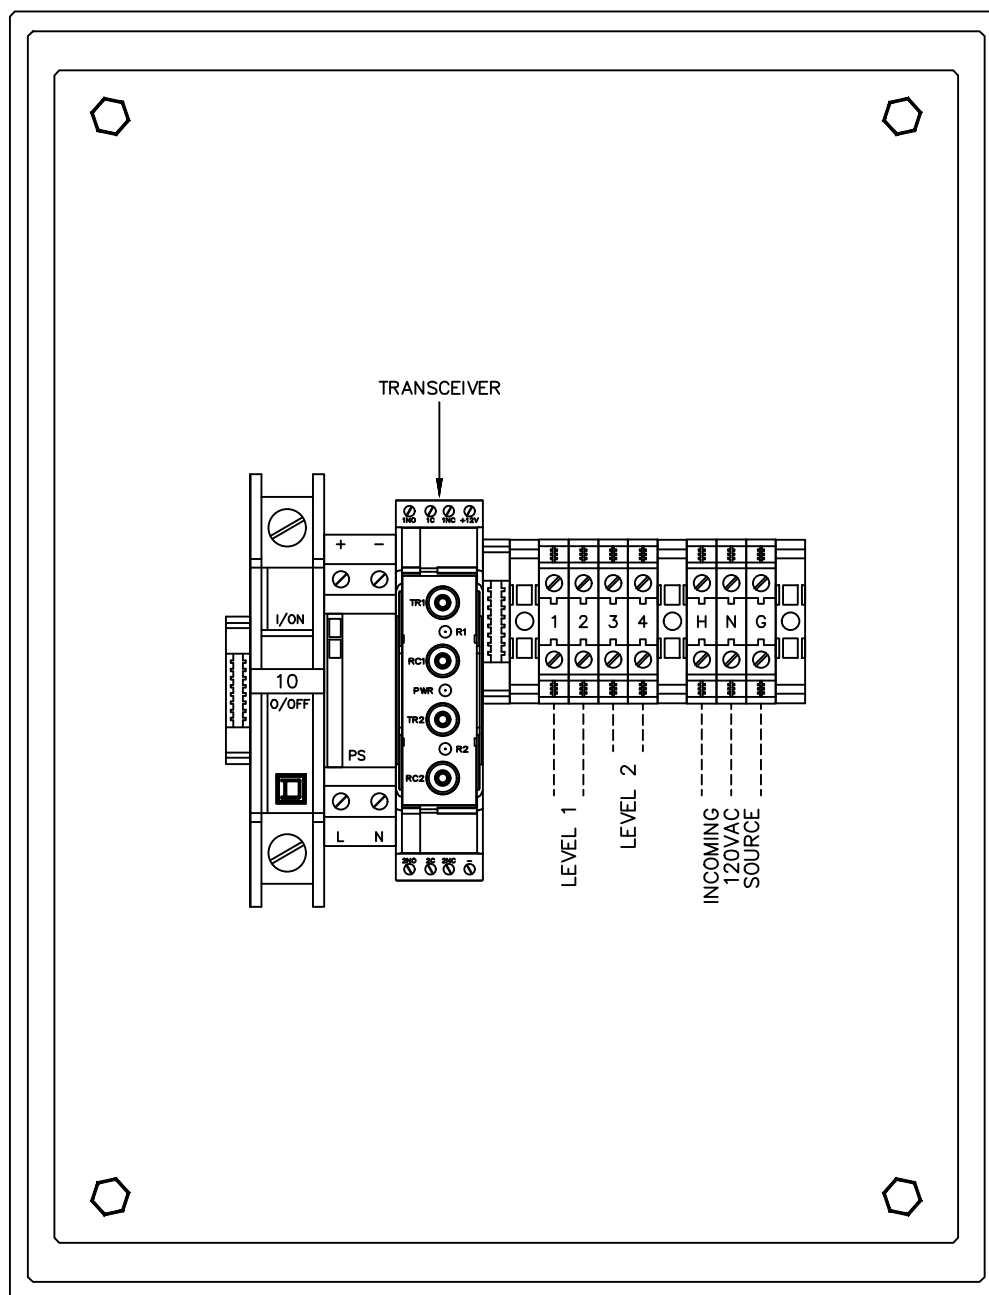


NON-METALLIC ENCLOSURE 12.07"H X 10.2"W X 7.3"D
 304 STAINLESS STEEL ENCLOSURE 11.5"H X 8.3"W X 7.8"D
 KEEP PANEL POWERED OFF UNTIL OPTI-FLOATS ARE COMPLETELY CONNECTED

	Drawing Title							
	EXTERNAL CONNECTIONS							
			OPTI-RK2		TR2 REPLACE TO TR2A		02/26/19	C.C.
		REFERENCE DRAWING	NO.	REVISION - LOCATION		ECN	DATE	BY
DATE: 02/12/26		S/N	Sales Engineer C.C.	Application Engineer C.C.	DRAWN BY: JCF	APPROVED		
	Project Title					BY:	DATE:	
	OPTI-RK2A/SS					PURCHASE ORDER NUMBER		
						DRAWING NUMBER OPTI-RK2A/SS		
SCALE: N.T.S.						SHEET NUMBER 2		
		P.O. Box 77808 Baton Rouge, LA 70879 Ph. (225) 756-3271 Fax (225) 755-1030						

The OPTI-FLOAT® TR2A Transceiver

Release Date
January 2019

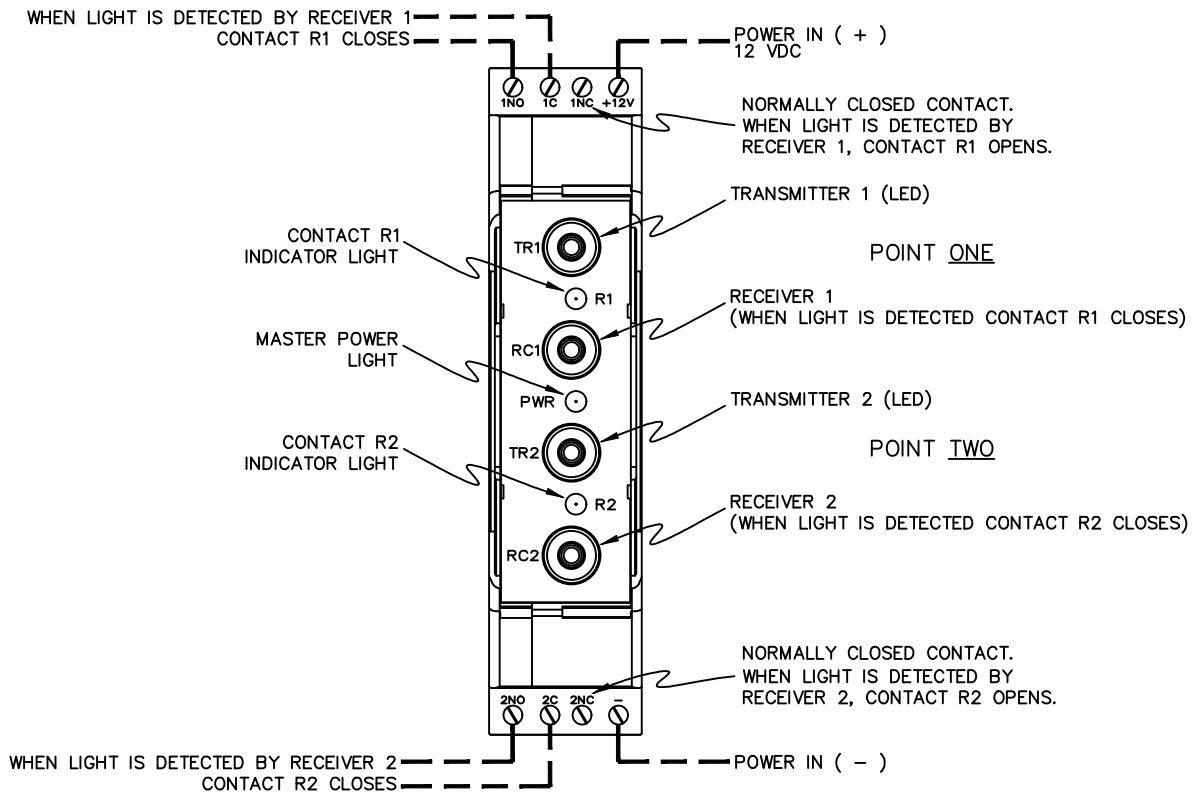

DATE: 02/12/26	Drawing Title TRANSCEIVER	REFERENCE DRAWING		NO.		REVISION - LOCATION		ECN	DATE	BY
		S/N		Sales Engineer C.C.		Application Engineer C.C.		DRAWN		APPROVED
								BY: JCF		BY: DATE:
SCALE: N.T.S.	Project Title OPTI-RK2A/SS			P.O. Box 77808 Baton Rouge, LA 70879 Ph. (225) 756-3271 Fax (225) 755-1030		PURCHASE ORDER NUMBER				
						DRAWING NUMBER				
						OPTI-RK2A/SS				
						SHEET NUMBER				3