





OPTI-RK4A/SS
OPTI-FLOAT® LEVEL DETECTOR
4 FLOAT RETRO KIT CONTROL PANEL

Cox Research and Technology, Inc.
PO Box 77808
Baton Rouge, LA. 70879
(225) 756-3271 Fax (225) 755-1030

OPTI-RK4A/SS

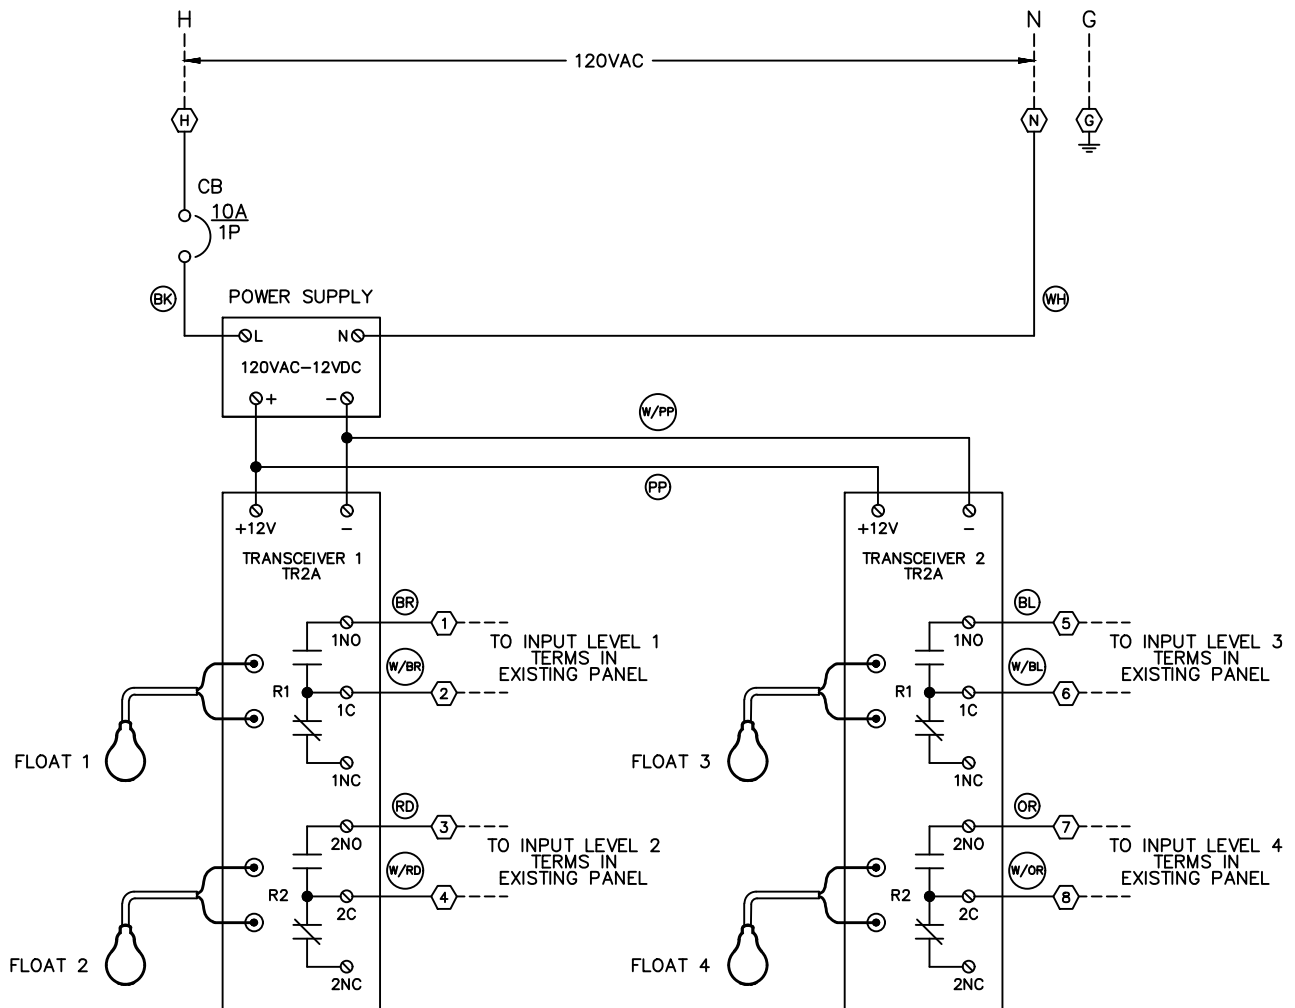

	Drawing Title							
	CONTROL DIAGRAM							
		OPTI-RK4		TR2 REPLACE TO TR2A		02/26/19	C.C.	
DATE: 08/14/26		REFERENCE DRAWING	NO.	REVISION - LOCATION	ECN	DATE	BY	
	Project Title	S/N	Sales Engineer C.C.	Application Engineer C.C.	DRAWN BY: JCF	APPROVED BY:	DATE:	
	OPTI-RK4A/SS				P.O. Box 77808 Baton Rouge, LA 70879	PURCHASE ORDER NUMBER		
SCALE: N.T.S.					Ph. (225) 756-3271 Fax (225) 755-1030	DRAWING NUMBER OPTI-RK4A/SS		
						SHEET NUMBER 1		

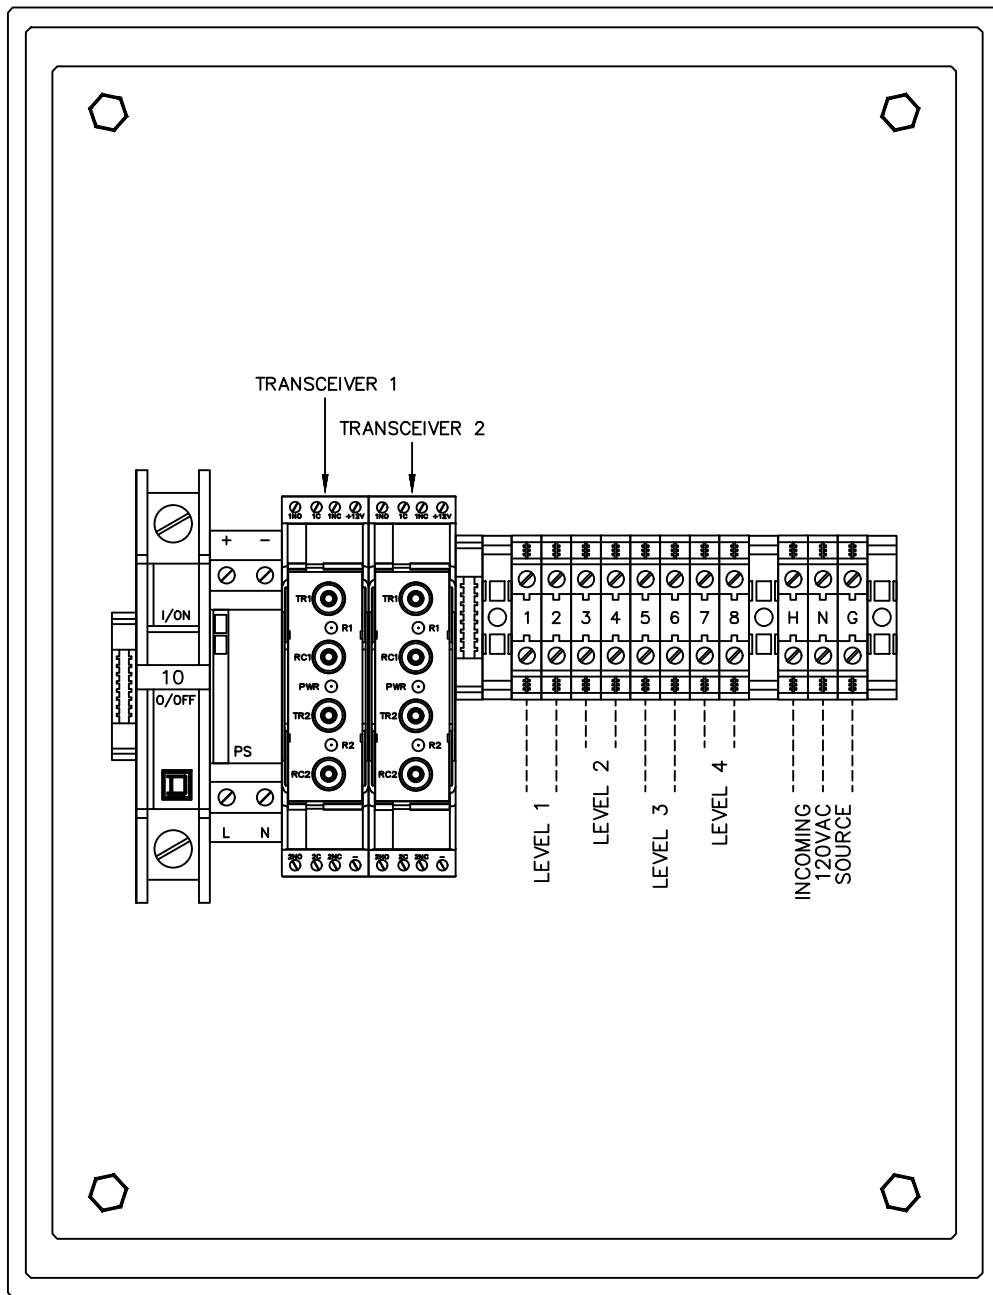


NON-METALLIC ENCLOSURE 10.551"H X 8.543"W X 7.283"D
 304 STAINLESS STEEL ENCLOSURE 11.5"H X 8.3"W X 7.8"D
 KEEP PANEL POWERED OFF UNTIL OPTI-FLOATS ARE COMPLETELY CONNECTED

	Drawing Title						
	EXTERNAL CONNECTIONS	OPTI-RK4		TR2 REPLACE TO TR2A		02/26/19	C.C.
DATE: 08/14/26		REFERENCE DRAWING	NO.	REVISION - LOCATION	ECN	DATE	BY
	Project Title	S/N	Sales Engineer C.C.	Application Engineer C.C.	DRAWN BY: JCF	APPROVED BY:	DATE:
	OPTI-RK4A/SS				P.O. Box 77808 Baton Rouge, LA 70879	PURCHASE ORDER NUMBER	
SCALE: N.T.S.					Ph. (225) 756-3271 Fax (225) 755-1030	DRAWING NUMBER OPTI-RK4A/SS	
						SHEET NUMBER 2	

The OPTI-FLOAT® TR2A Transceiver

Release Date
January 2019

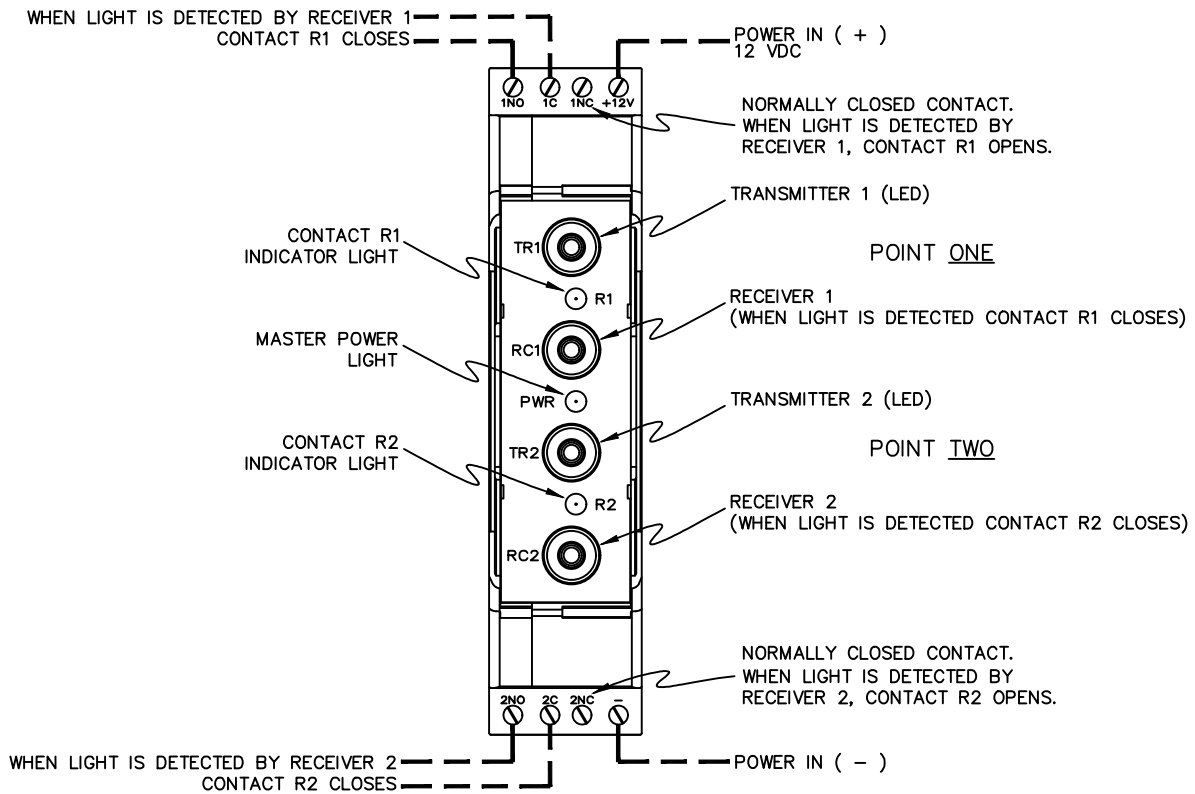

	Drawing Title							
	TRANSCEIVER	OPTI-RK4		TR2 REPLACE TO TR2A		02/26/19	C.C.	
		REFERENCE DRAWING	NO.	REVISION - LOCATION	ECN	DATE	BY	
DATE: 08/14/26		S/N	Sales Engineer C.C.	Application Engineer C.C.	DRAWN BY: JCF	APPROVED BY:	DATE:	
	Project Title				P.O. Box 77808 Baton Rouge, LA 70879	PURCHASE ORDER NUMBER		
	OPTI-RK4A/SS				Ph. (225) 756-3271 Fax (225) 755-1030	DRAWING NUMBER OPTI-RK4A/SS		
SCALE: N.T.S.						SHEET NUMBER 3		